



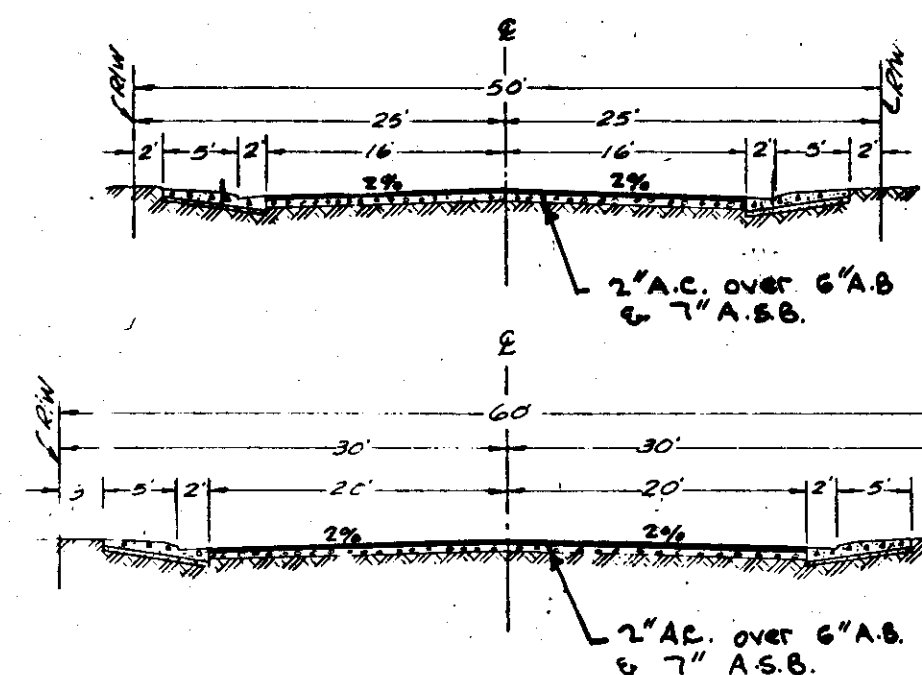


TYPICAL SUBDIVISION STREETS

NOTE:
1. The structural section shall be determined by Improvement Standard No. A-1
2. For curb, gutter and sidewalk details see Improvement Standard No. B-1 & No. B-2

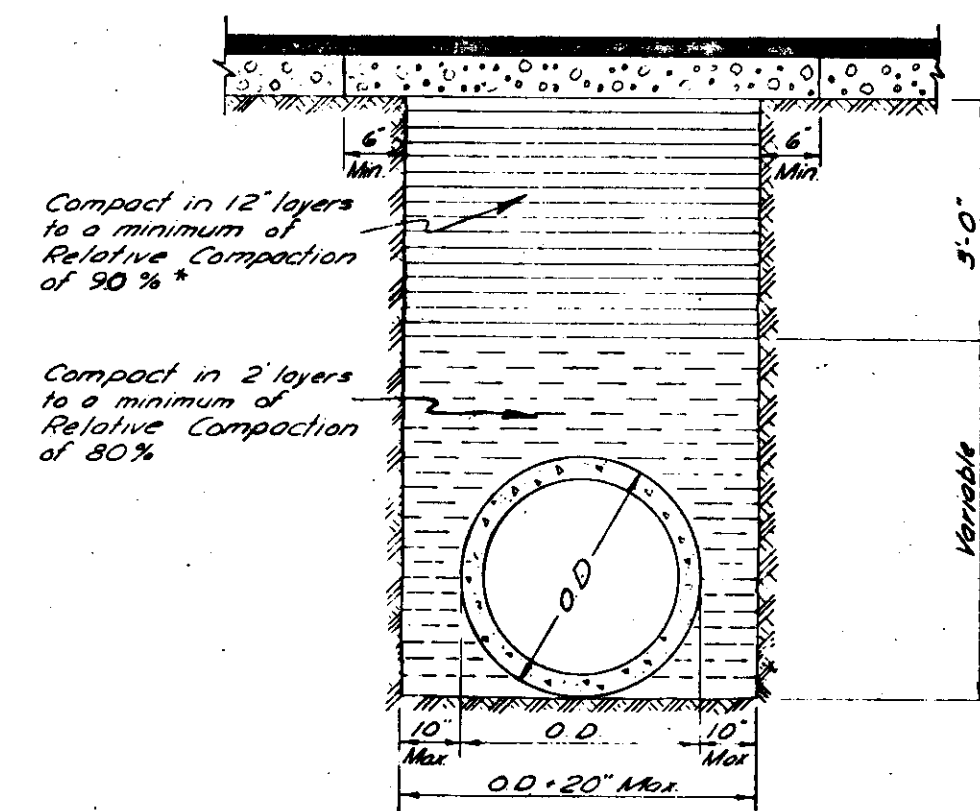


TYPICAL TRENCH BACKFILL DETAIL


- NOTES:
1. Relative Compaction of materials shall be tested by State of California Dept. of Public Works, Division of Highways Test Method No. California B16F.
 2. All existing pavement shall be neatly cut to line prior to trench excavation.
 3. No jacking or ponding shall be permitted.

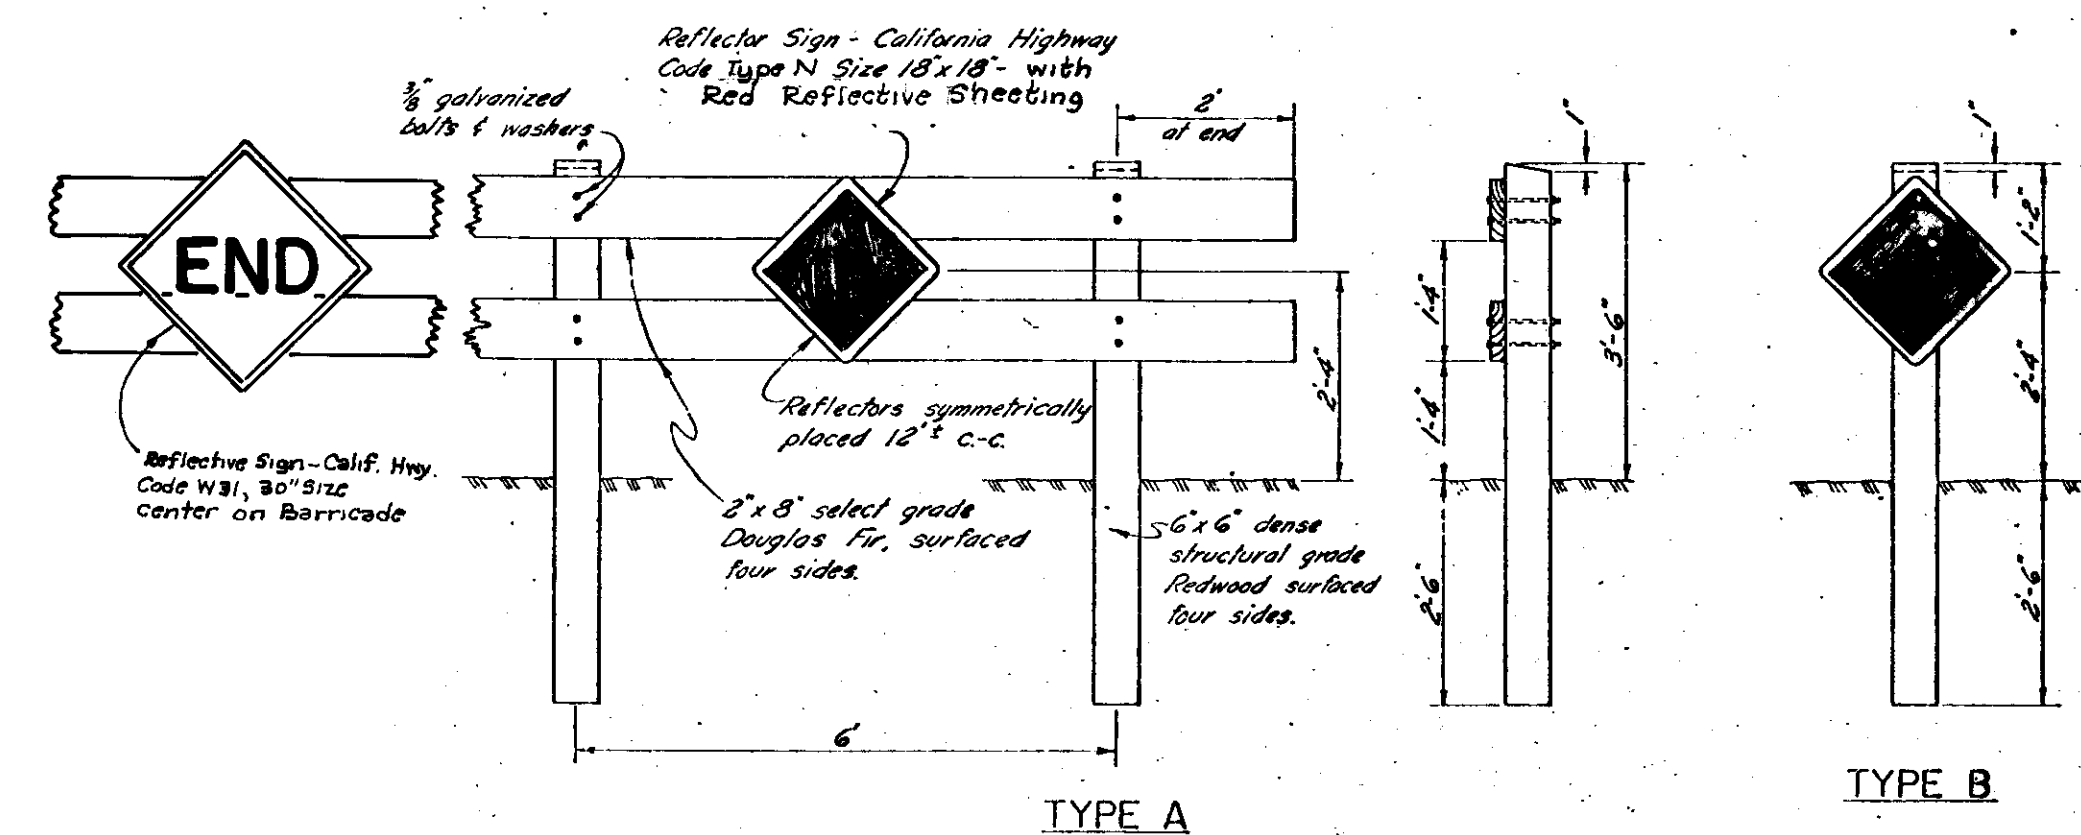


BARRICADES FOR TERMINATING STREETS

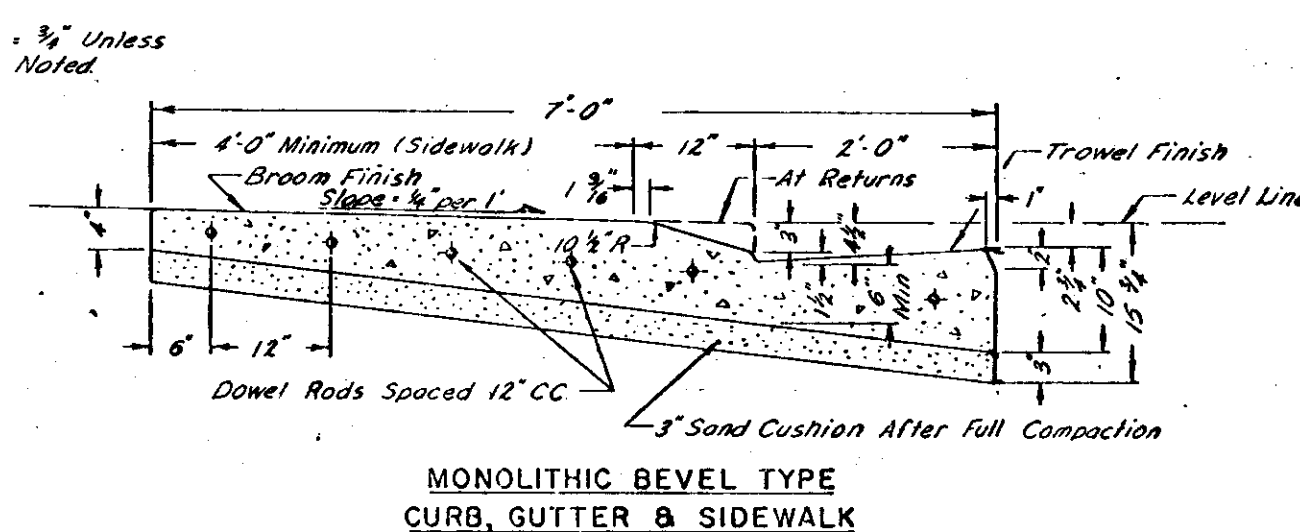


CURB, GUTTER & SIDEWALK SUBDIVISION STREETS

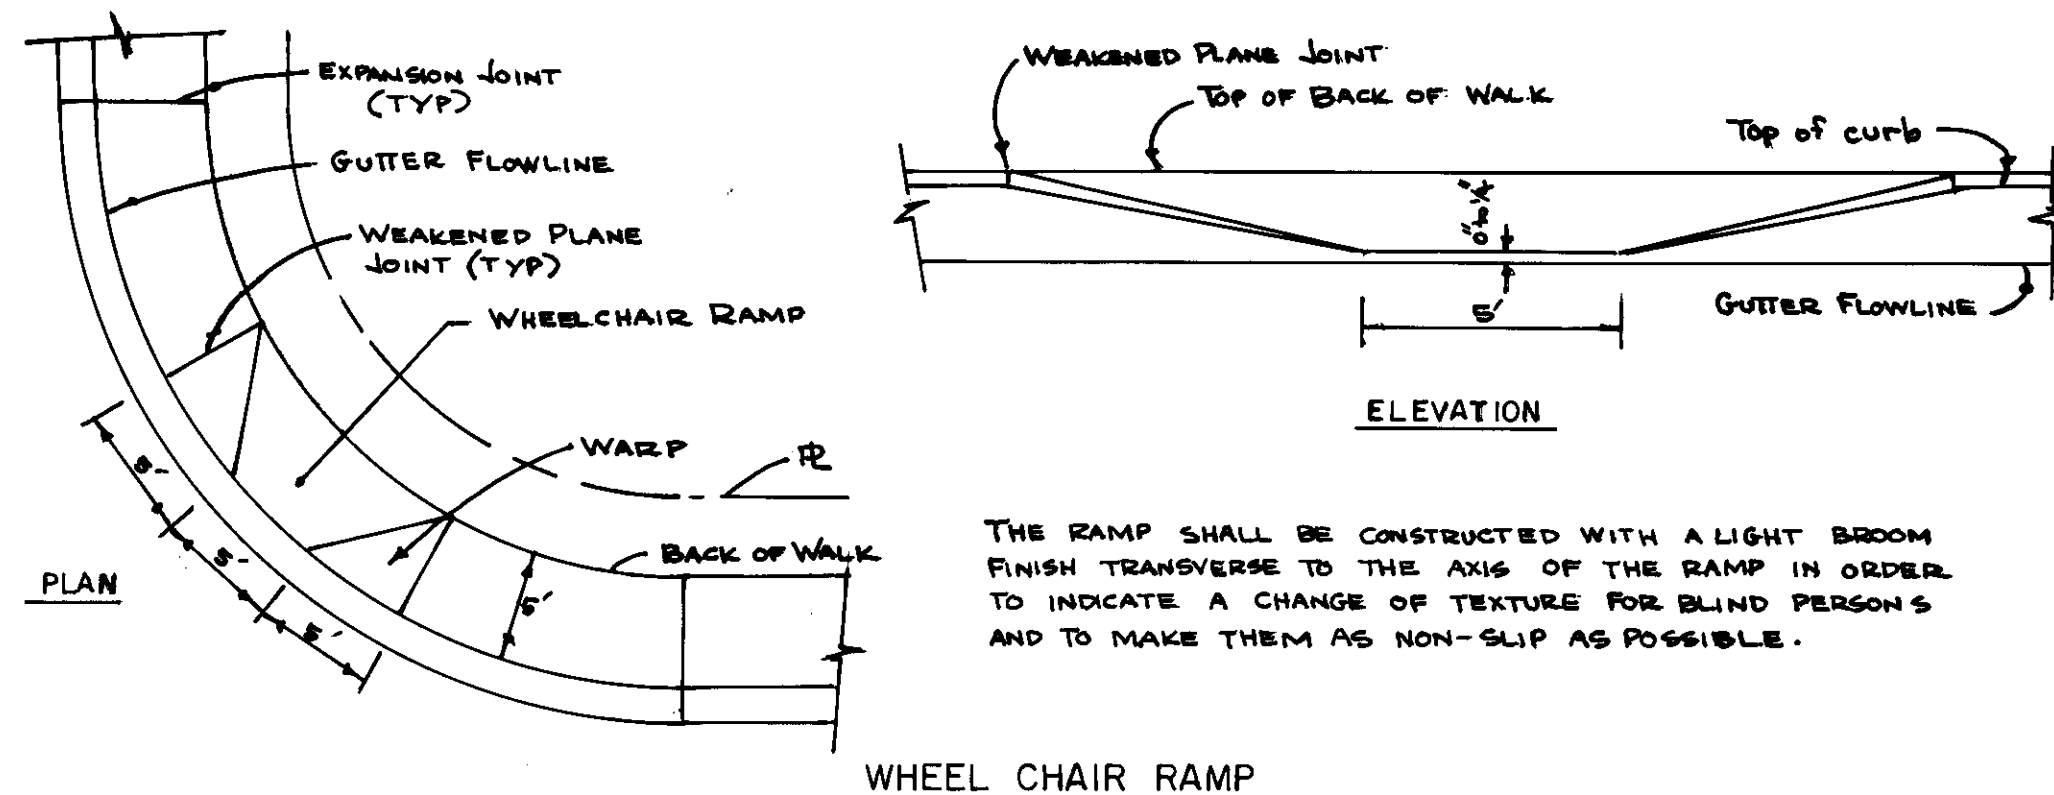

WHEEL CHAIR RAMP

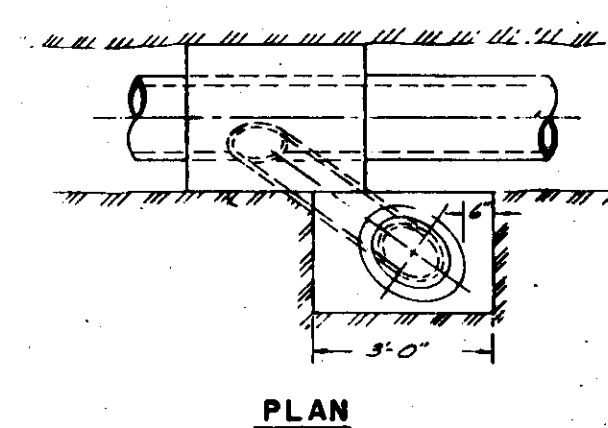


PLAN

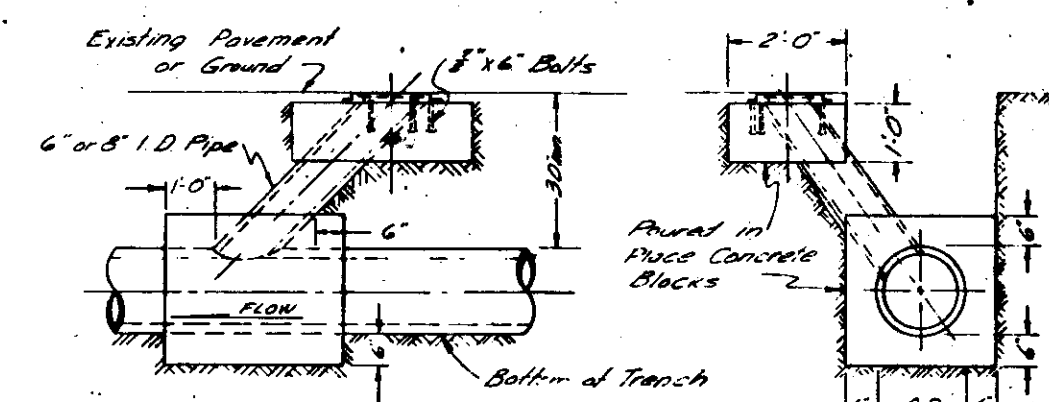


TYPICAL LAMPHOLE INSTALLATION


TYPICAL SANITARY SEWER DETAILS

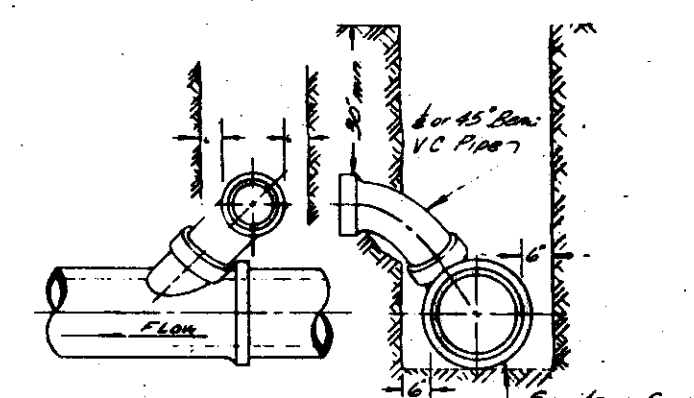

TYPICAL "Y" JOINT SERVICE CONNECTION

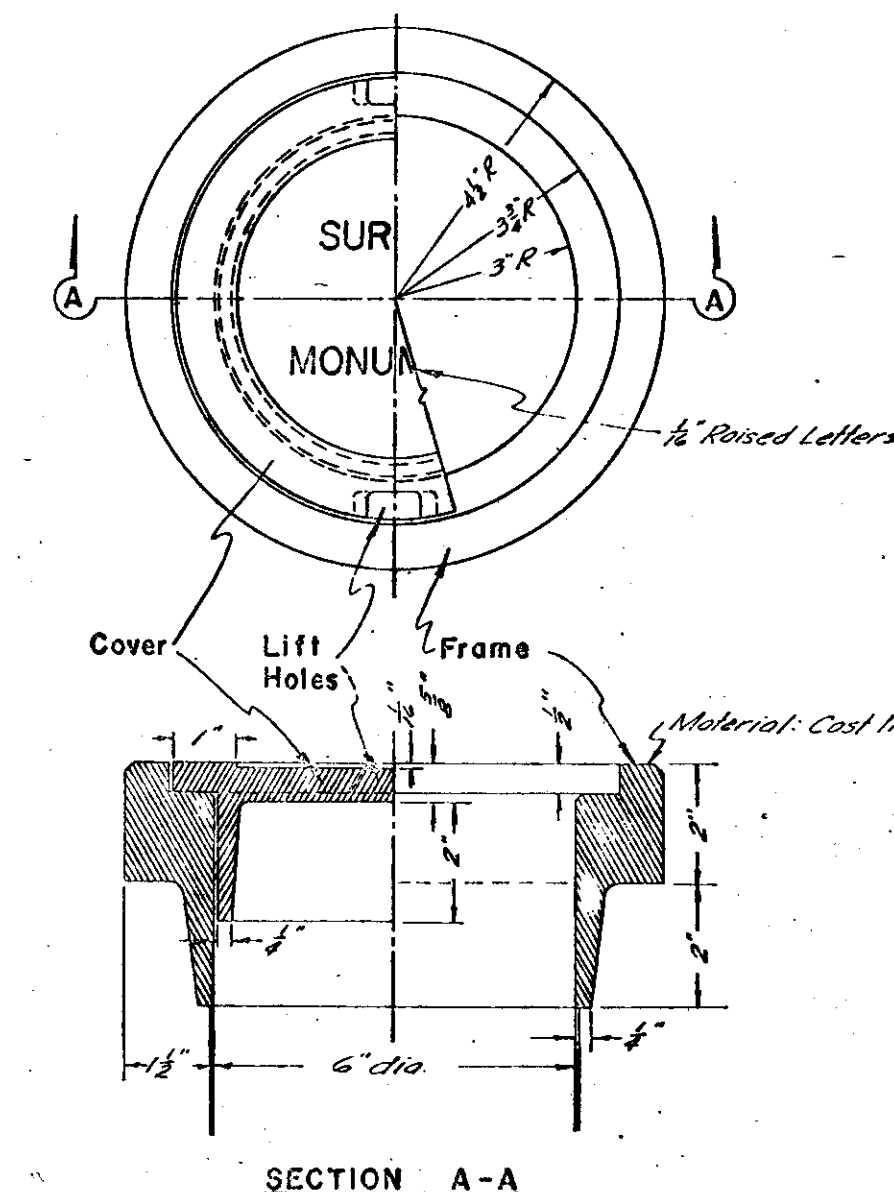


SECTION A-A

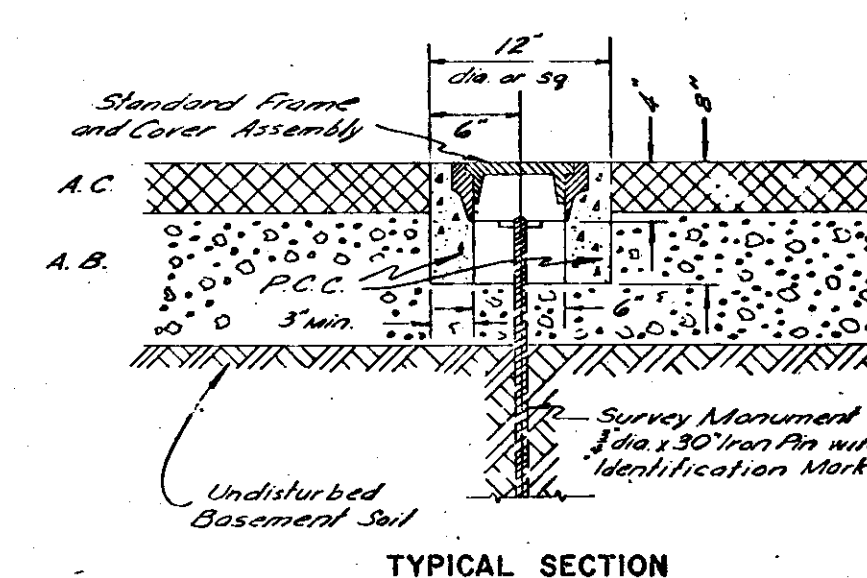


TYPICAL SECTION

SURVEY MONUMENT FRAME AND COVER ASSEMBLY

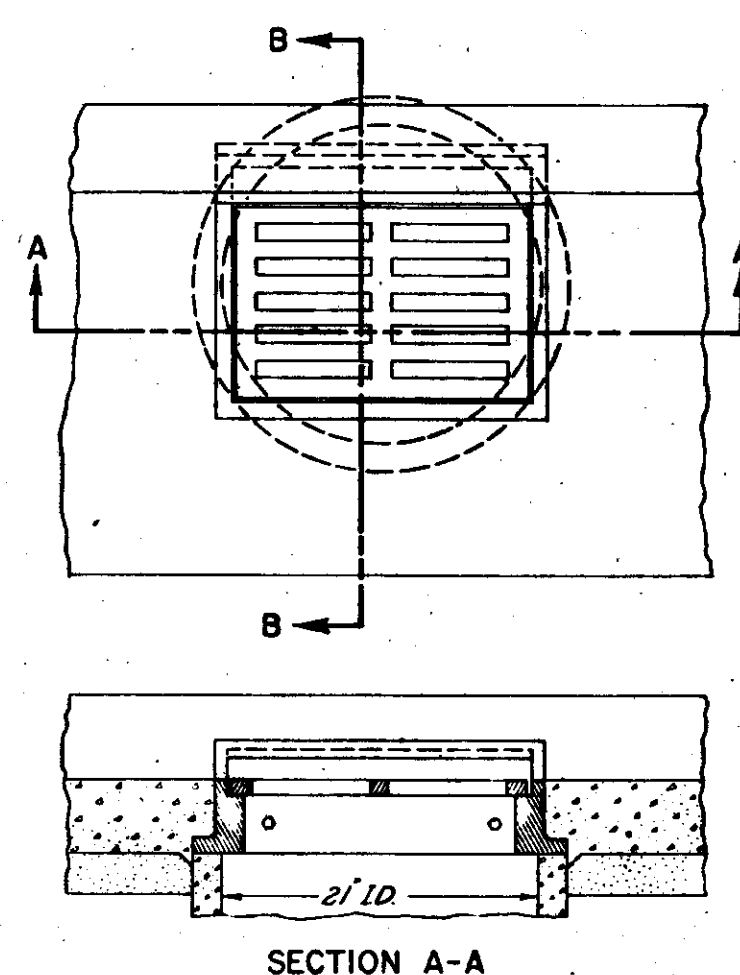


SECTION A-A


STANDARD STORM DRAIN INLET

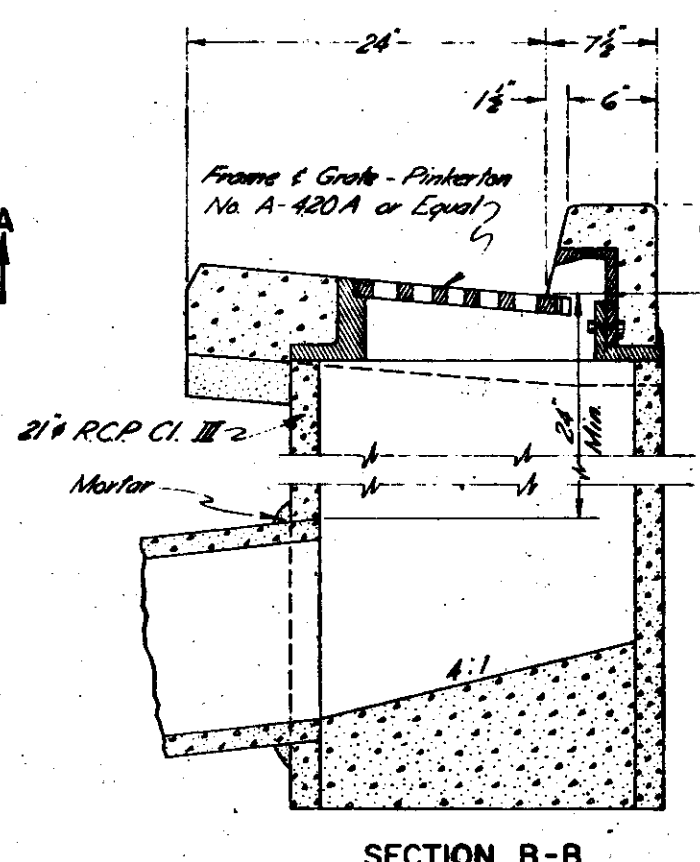


SECTION B-B

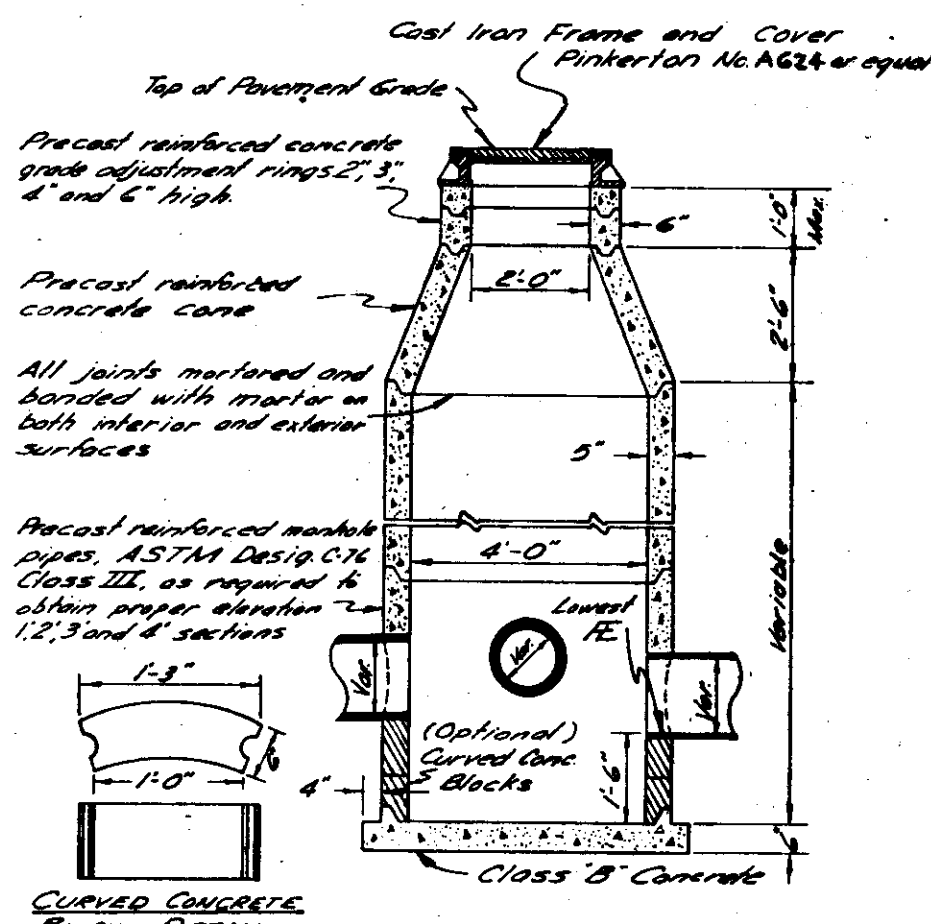

TYPICAL STORM SEWER MANHOLE

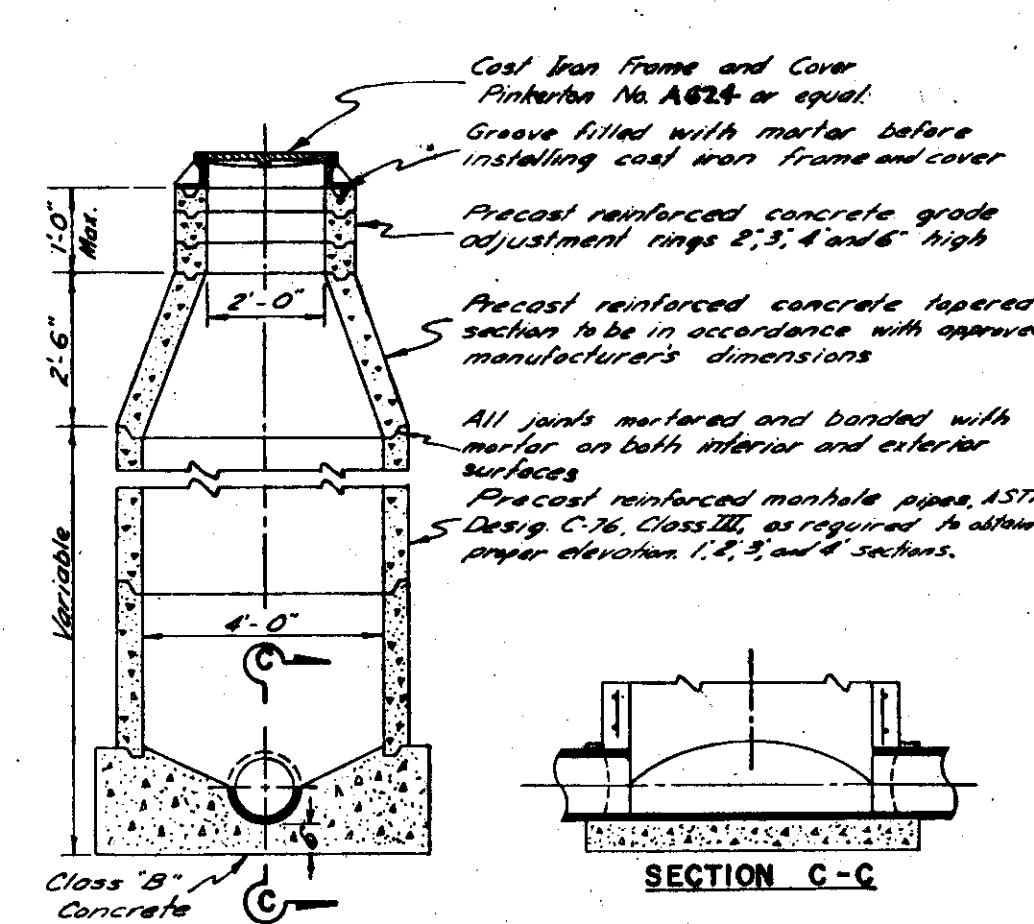


TYPICAL SANITARY SEWER MANHOLE

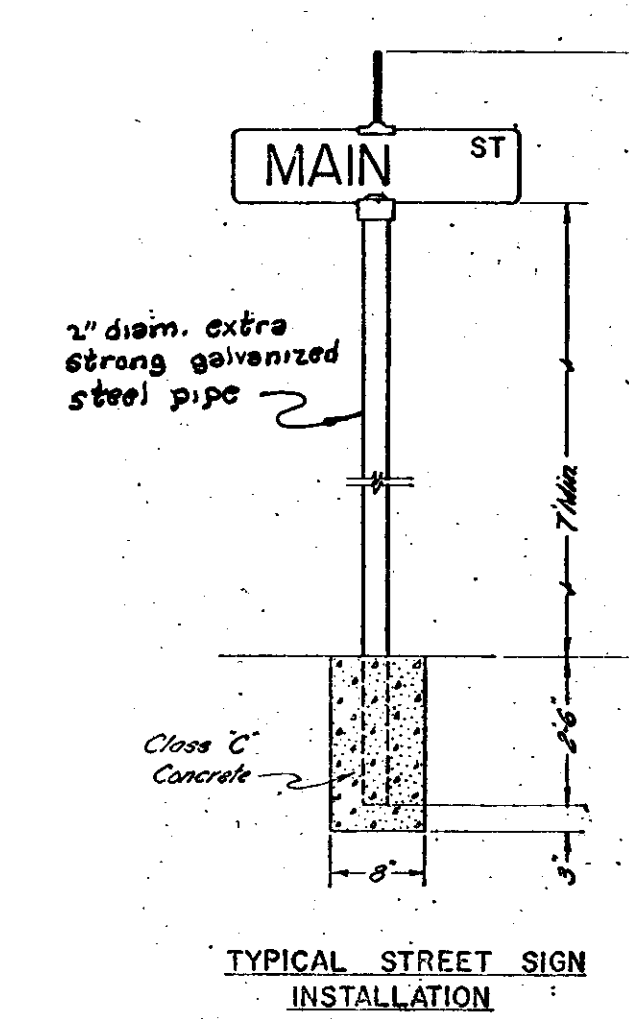

TYPICAL STREET SIGN INSTALLATION

STANDARD STREET SIGN DETAILS

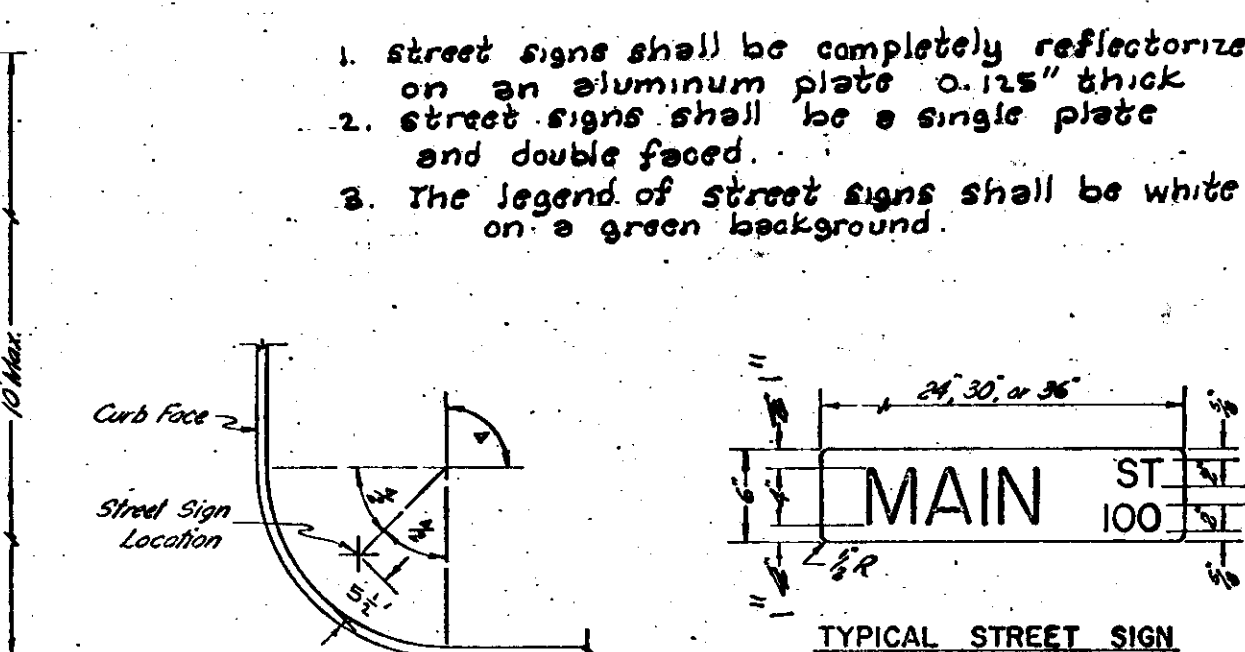

STREET SIGN POST LOCATION DETAIL

TYPICAL STREET SIGN

1. Street signs shall be completely reflectorized on an aluminum plate 0.125" thick.
2. Street signs shall be a single piece and double faced.
3. The legend of street signs shall be white on a green background.

Note: One street sign is required of each intersection.

APPROVED _____ 19 _____ APPROVED _____ June 10, 1977

William H. ...
S.J. County Director of Public Works

revisions
no. _____ description _____ date _____ by _____




WONG ENGINEERS
PLANNING • ENGINEERING • SURVEYING
STOCKTON, CALIFORNIA

R.C.E. No. 14269



job no. 1637
date _____
scale 1/8" = 1'-0"
drawn _____
design _____
check _____

TALLAHATCHY TERRACE UNIT NO. 1
DETAIL SHEET


SHEET
10
OF TEN
FILE

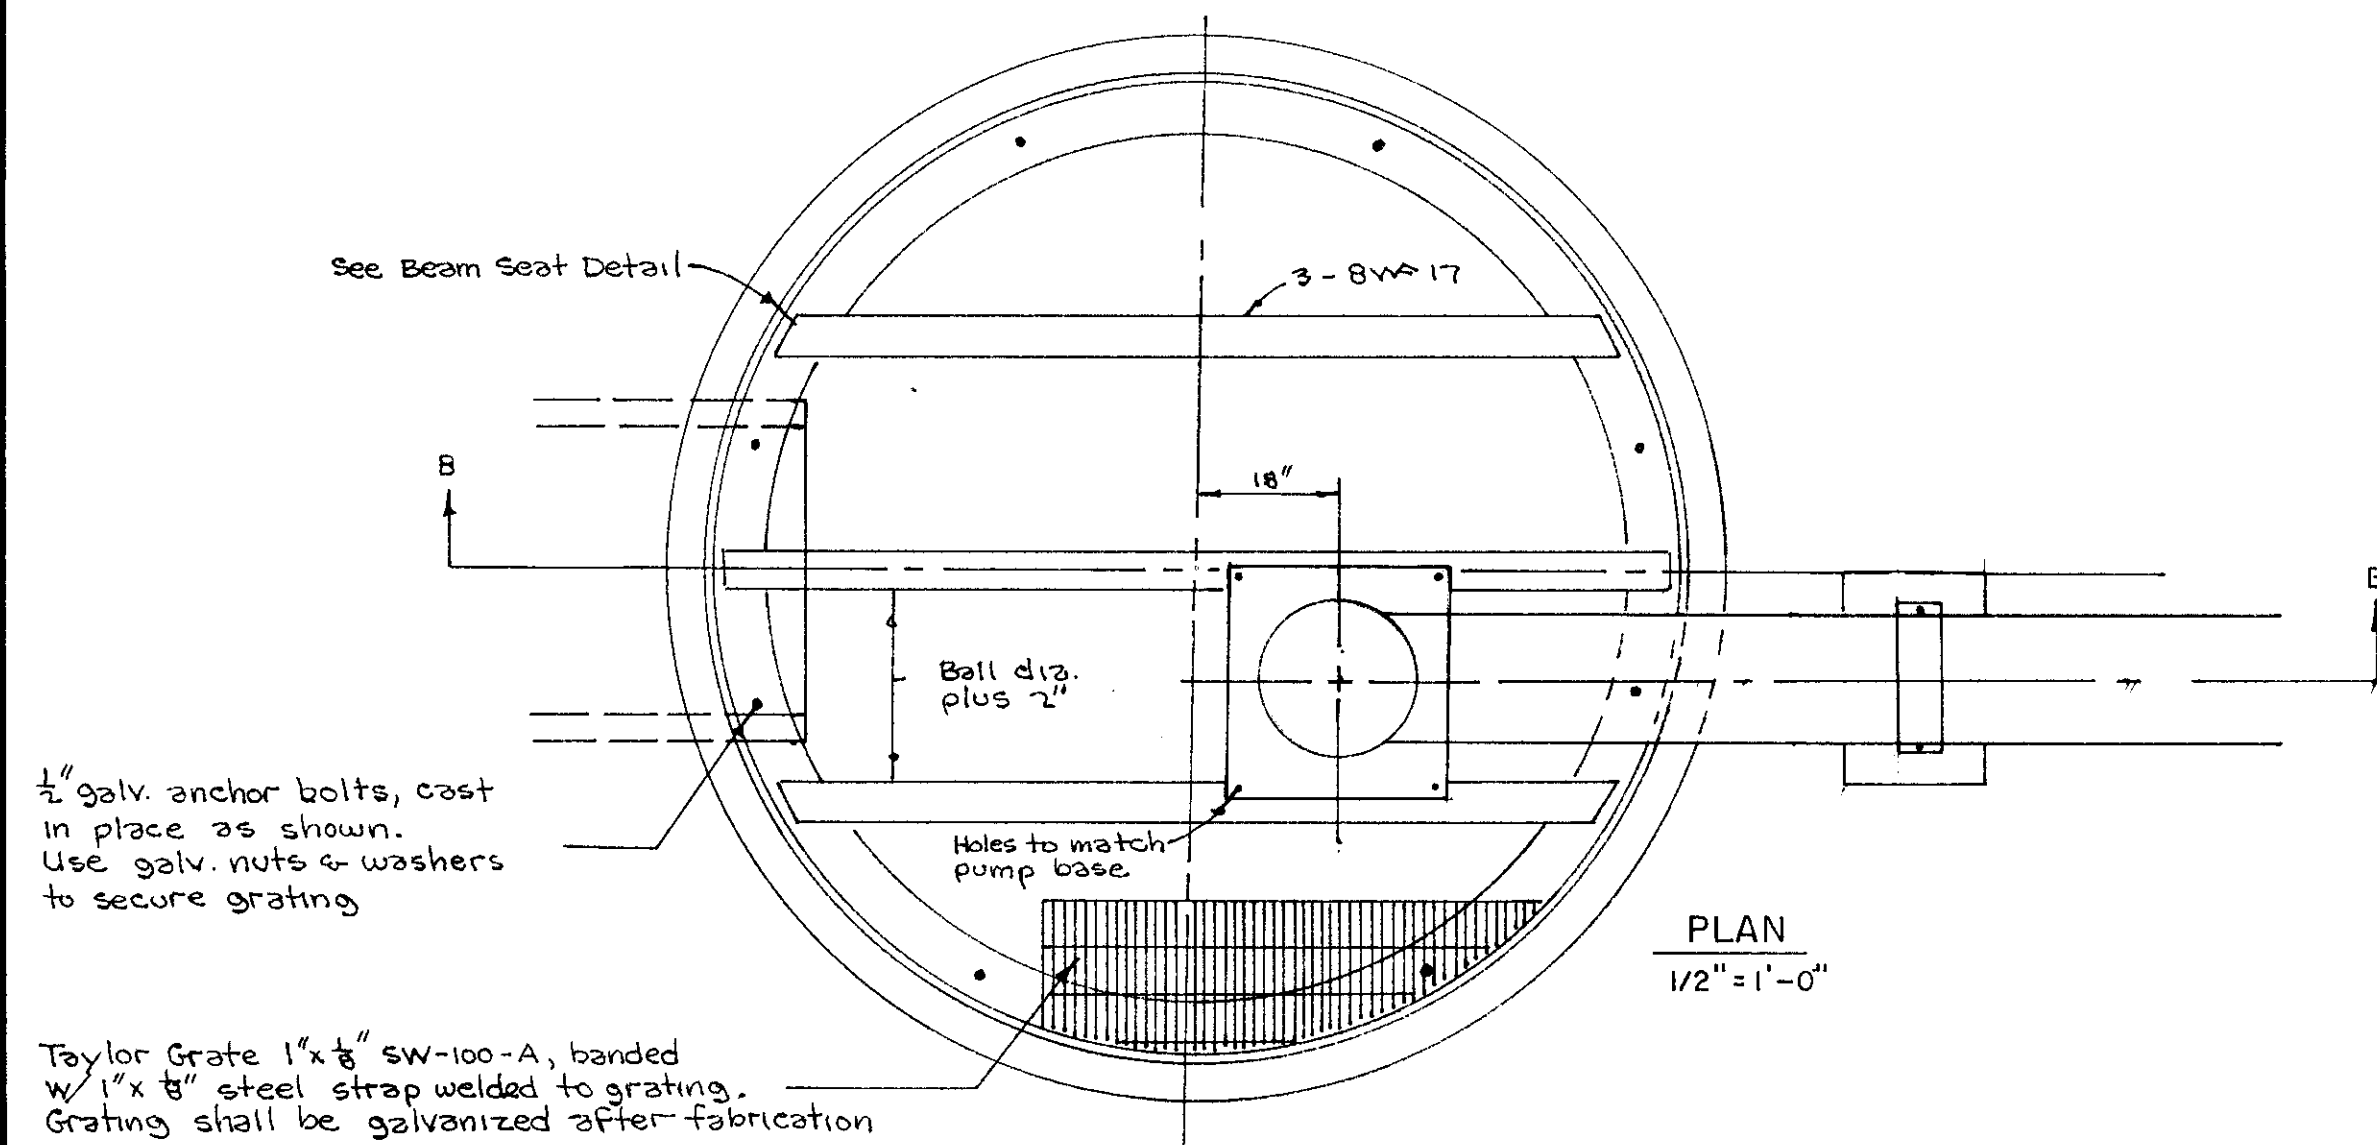

- 1- Vertical Hollowshaft Motor, weather protected, Type I, or equal, 40 H.P., 1170 RPM, w/self oiler.
- 1- Vertical propeller pump w/16" column to operate at 1175 RPM, equipped w/1 gal. solenoid operated lubricator. Pump shall be capable of pumping 4500 GPM @ 25.0' TDH

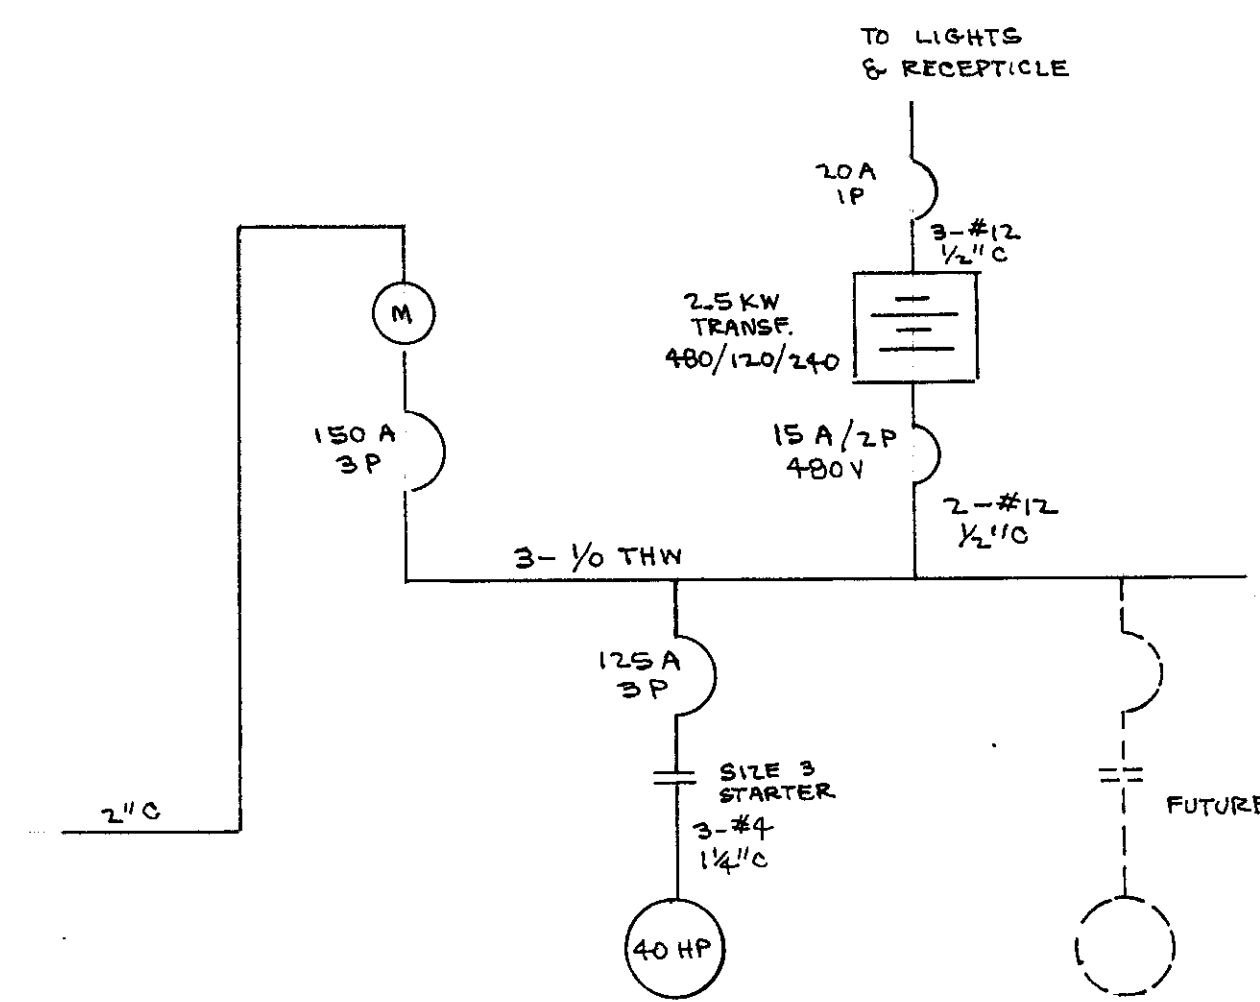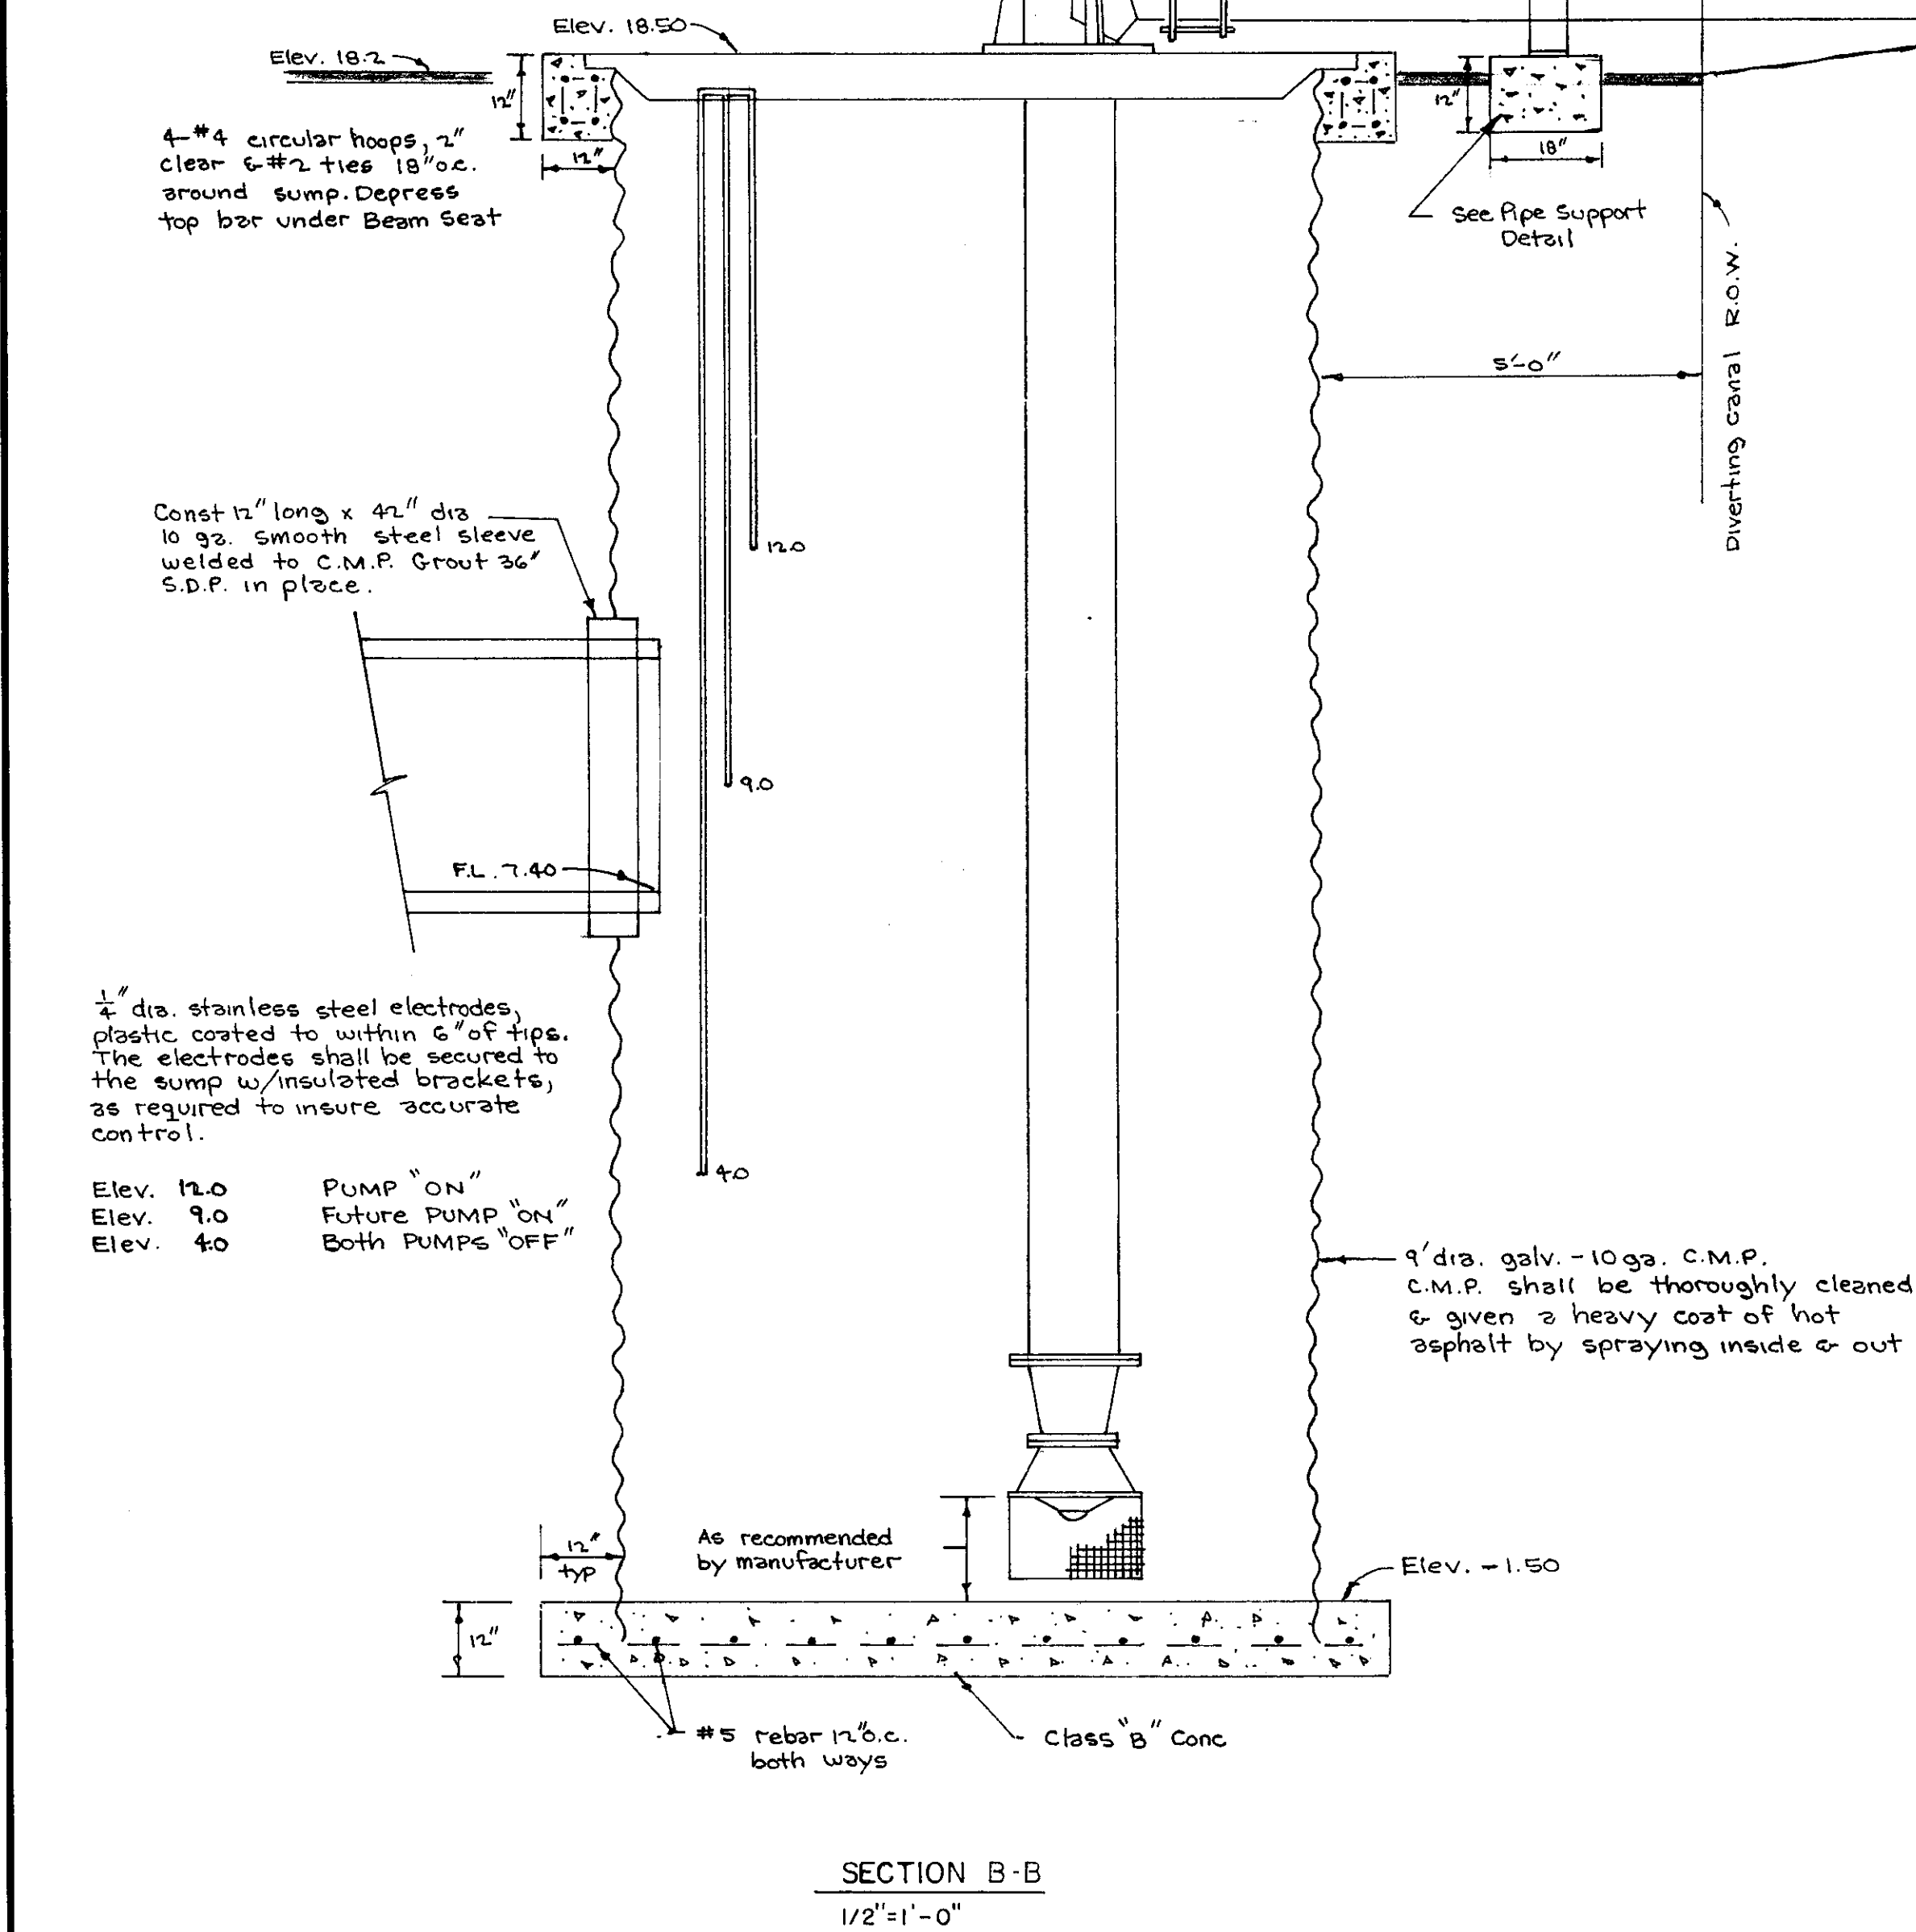

WIRING BASED ON USE OF COPPER WIRE
NO SUBSTITUTE

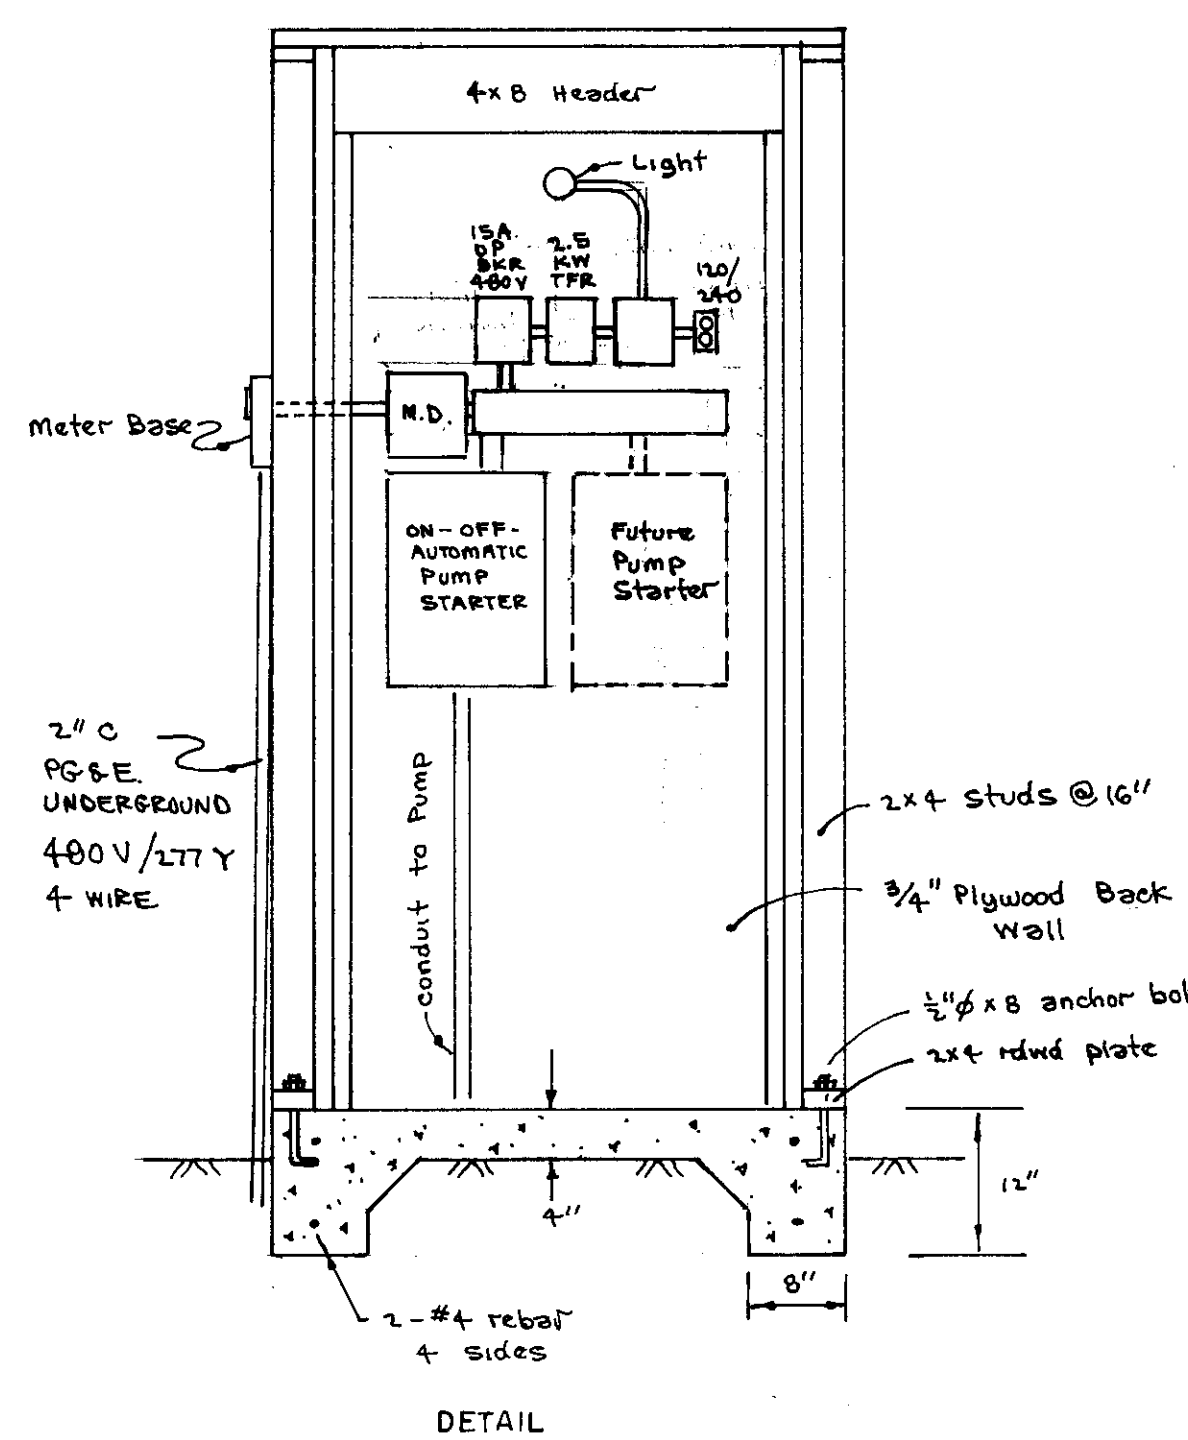


ELECTRICAL CONTROL HOUSE
SCALE 3/4"=1'-0"


APPROVED 5/31 1977

Shuttle
San Joaquin County Building Dept.


Cast 4-1/2" x 8" galv. bolts in manhole as shown
Const trash rack w/ 1/4" x 1/4" steel bars
welded vertically to 1/4" x 1/4" steel bar top and
bottom at 1/2" o.c. Galvanize after fabrication
Bolt in place w/galv. nut & washer
Install in line to pump.

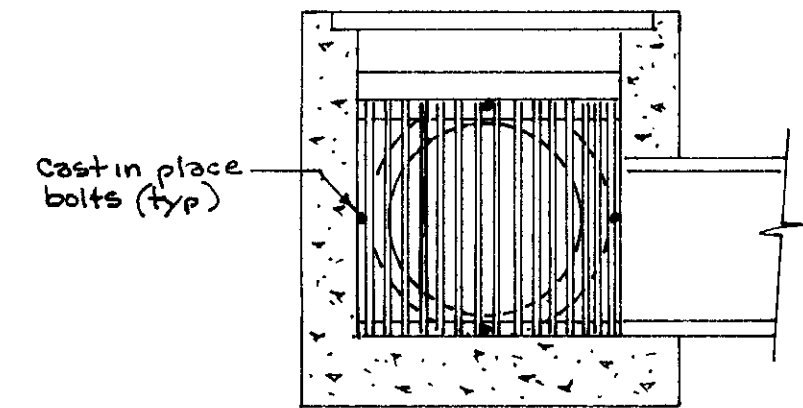


TRASH RACK DETAIL

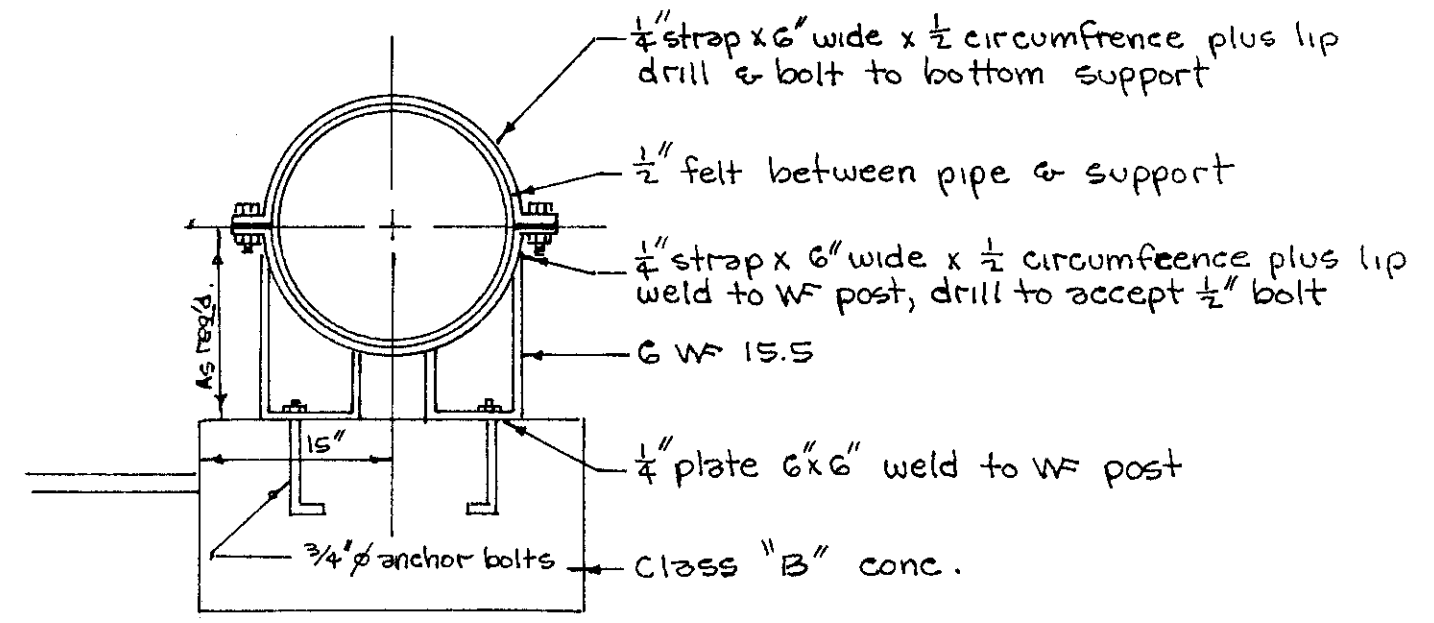


PIPE SUPPORT

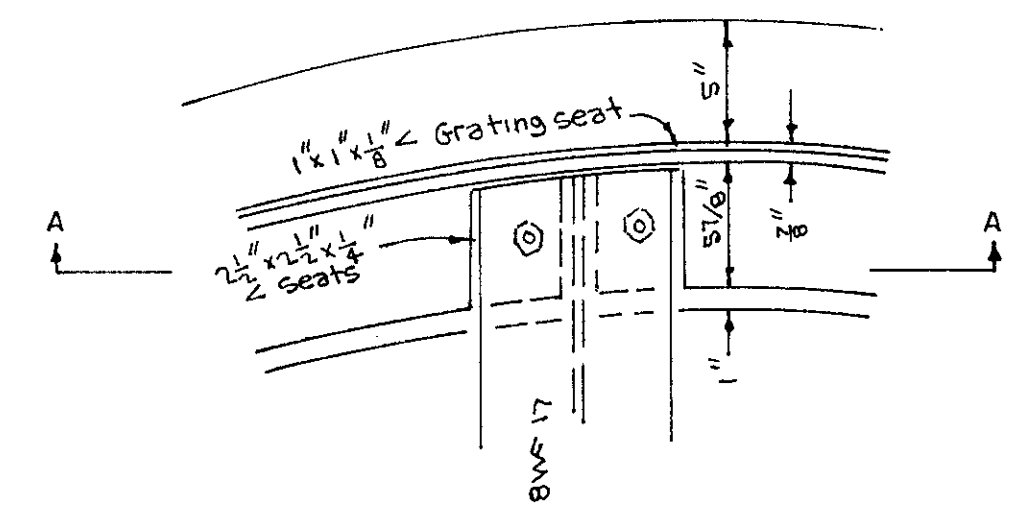


BEAM SEAT DETAIL

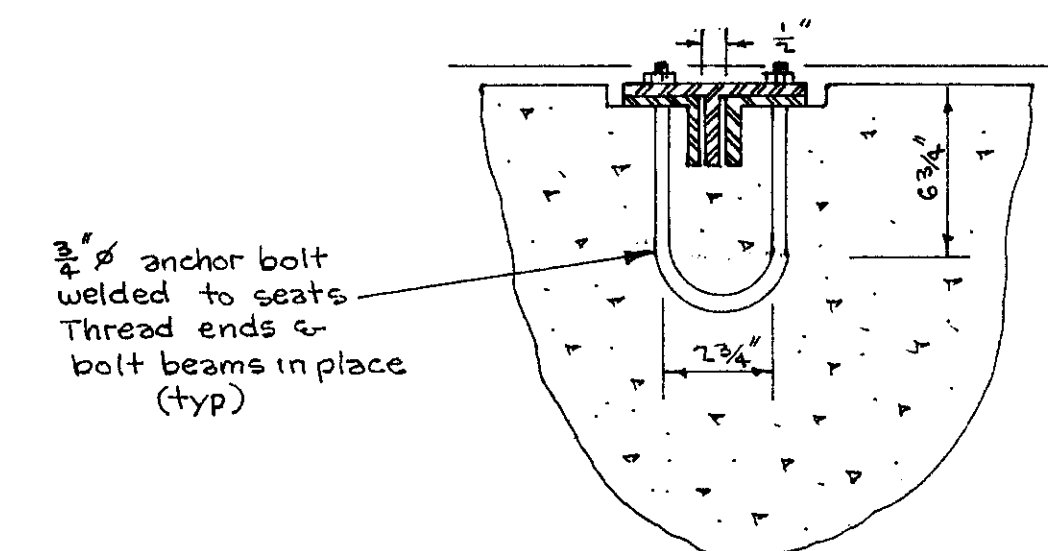

SECTION A-A


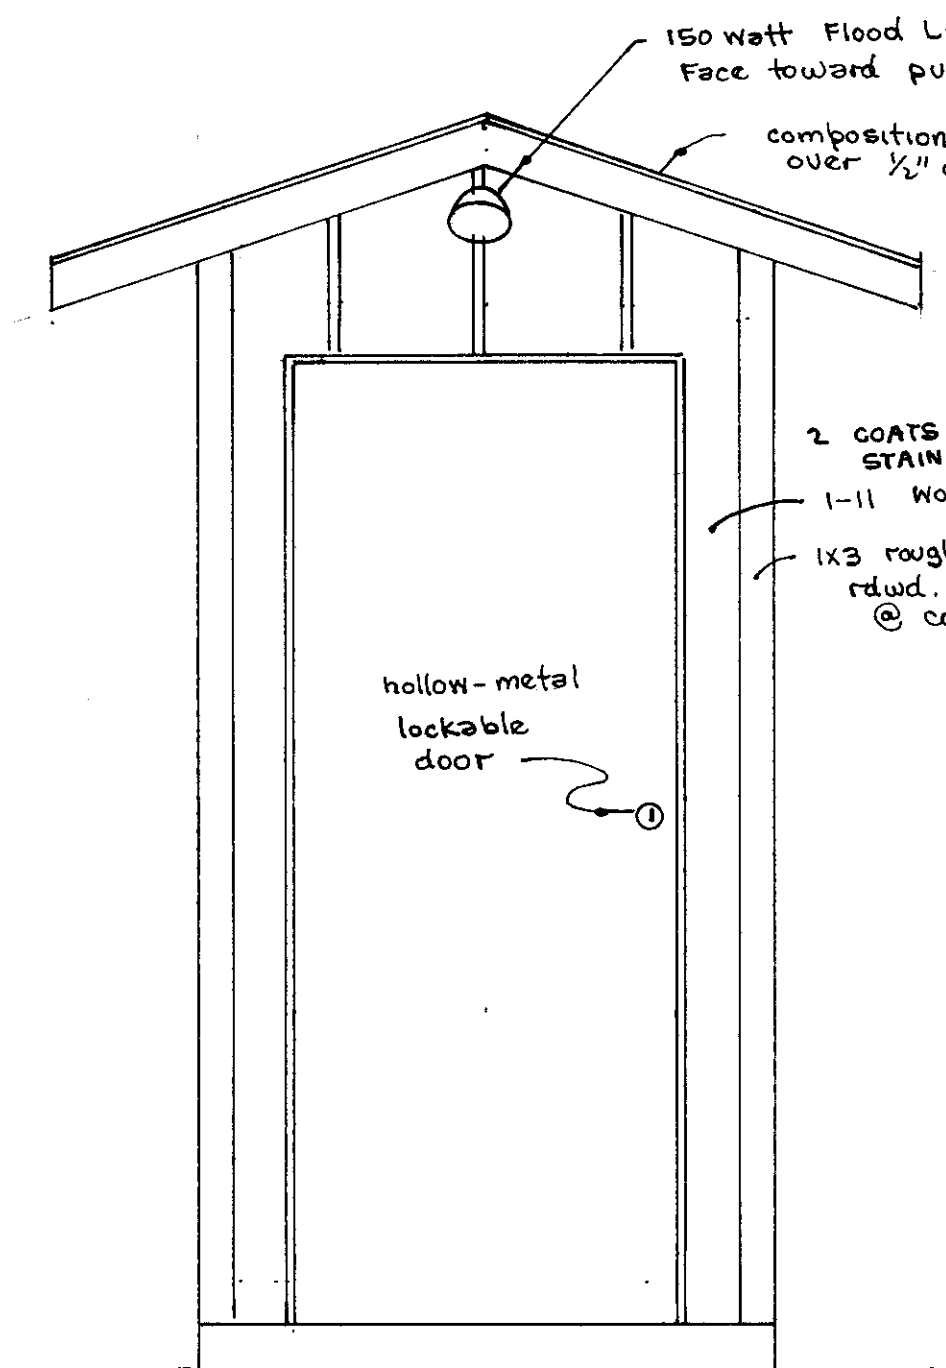


FRONT

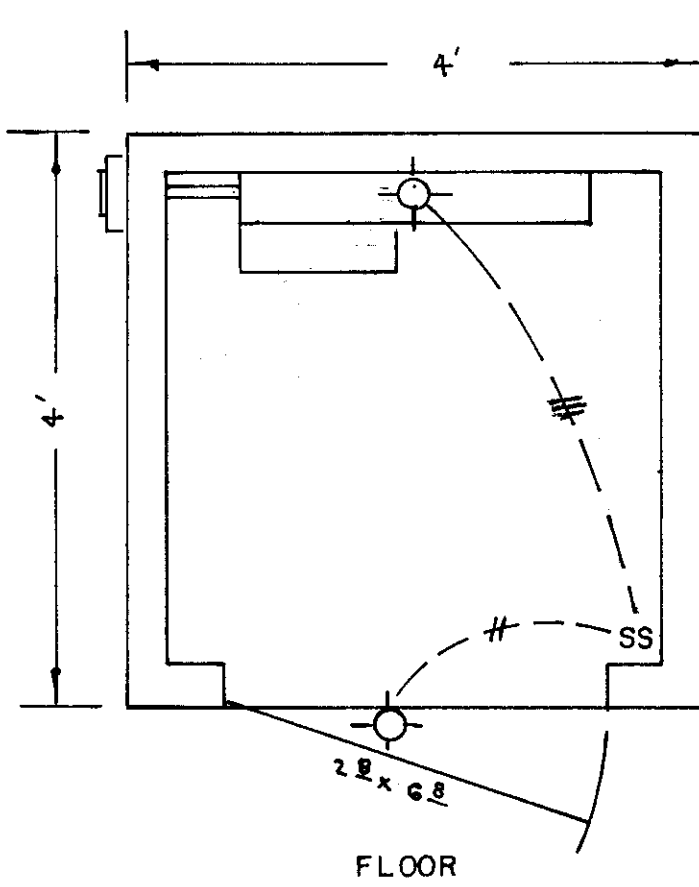


FLOOR

APPROVED _____ 19 _____	APPROVED <u>June 10 1977</u> <u>William Shutt</u> S.J. County Director of Public Works	revisions no. description date by	WONG ENGINEERS PLANNING • ENGINEERING • SURVEYING STOCKTON, CALIFORNIA <u>William Shutt</u> R.C.E. No. 14269	job no. 1637 date AS SHOWN scale 1/4"=1'-0" drawn WE design WE check	TALLAHATCHY TERRACE UNIT NO.1 STORM PUMPING PLANT DETAILS	SHEET 9 OF TEN FILE
-------------------------	--	--------------------------------------	--	---	--	------------------------------

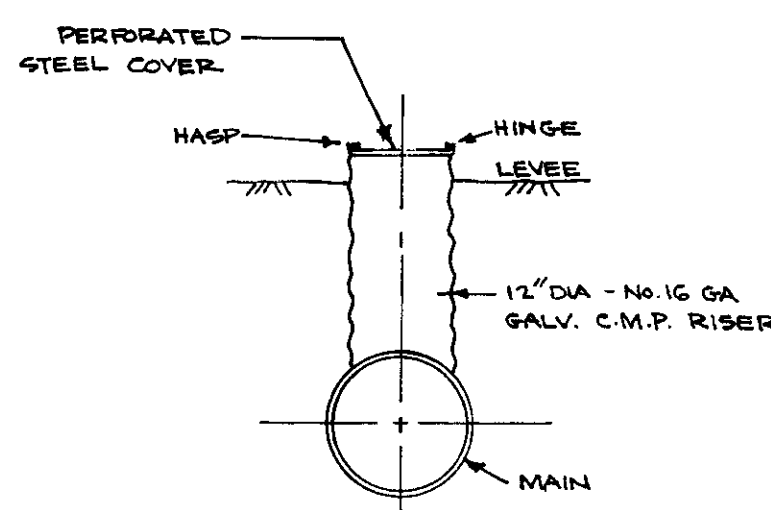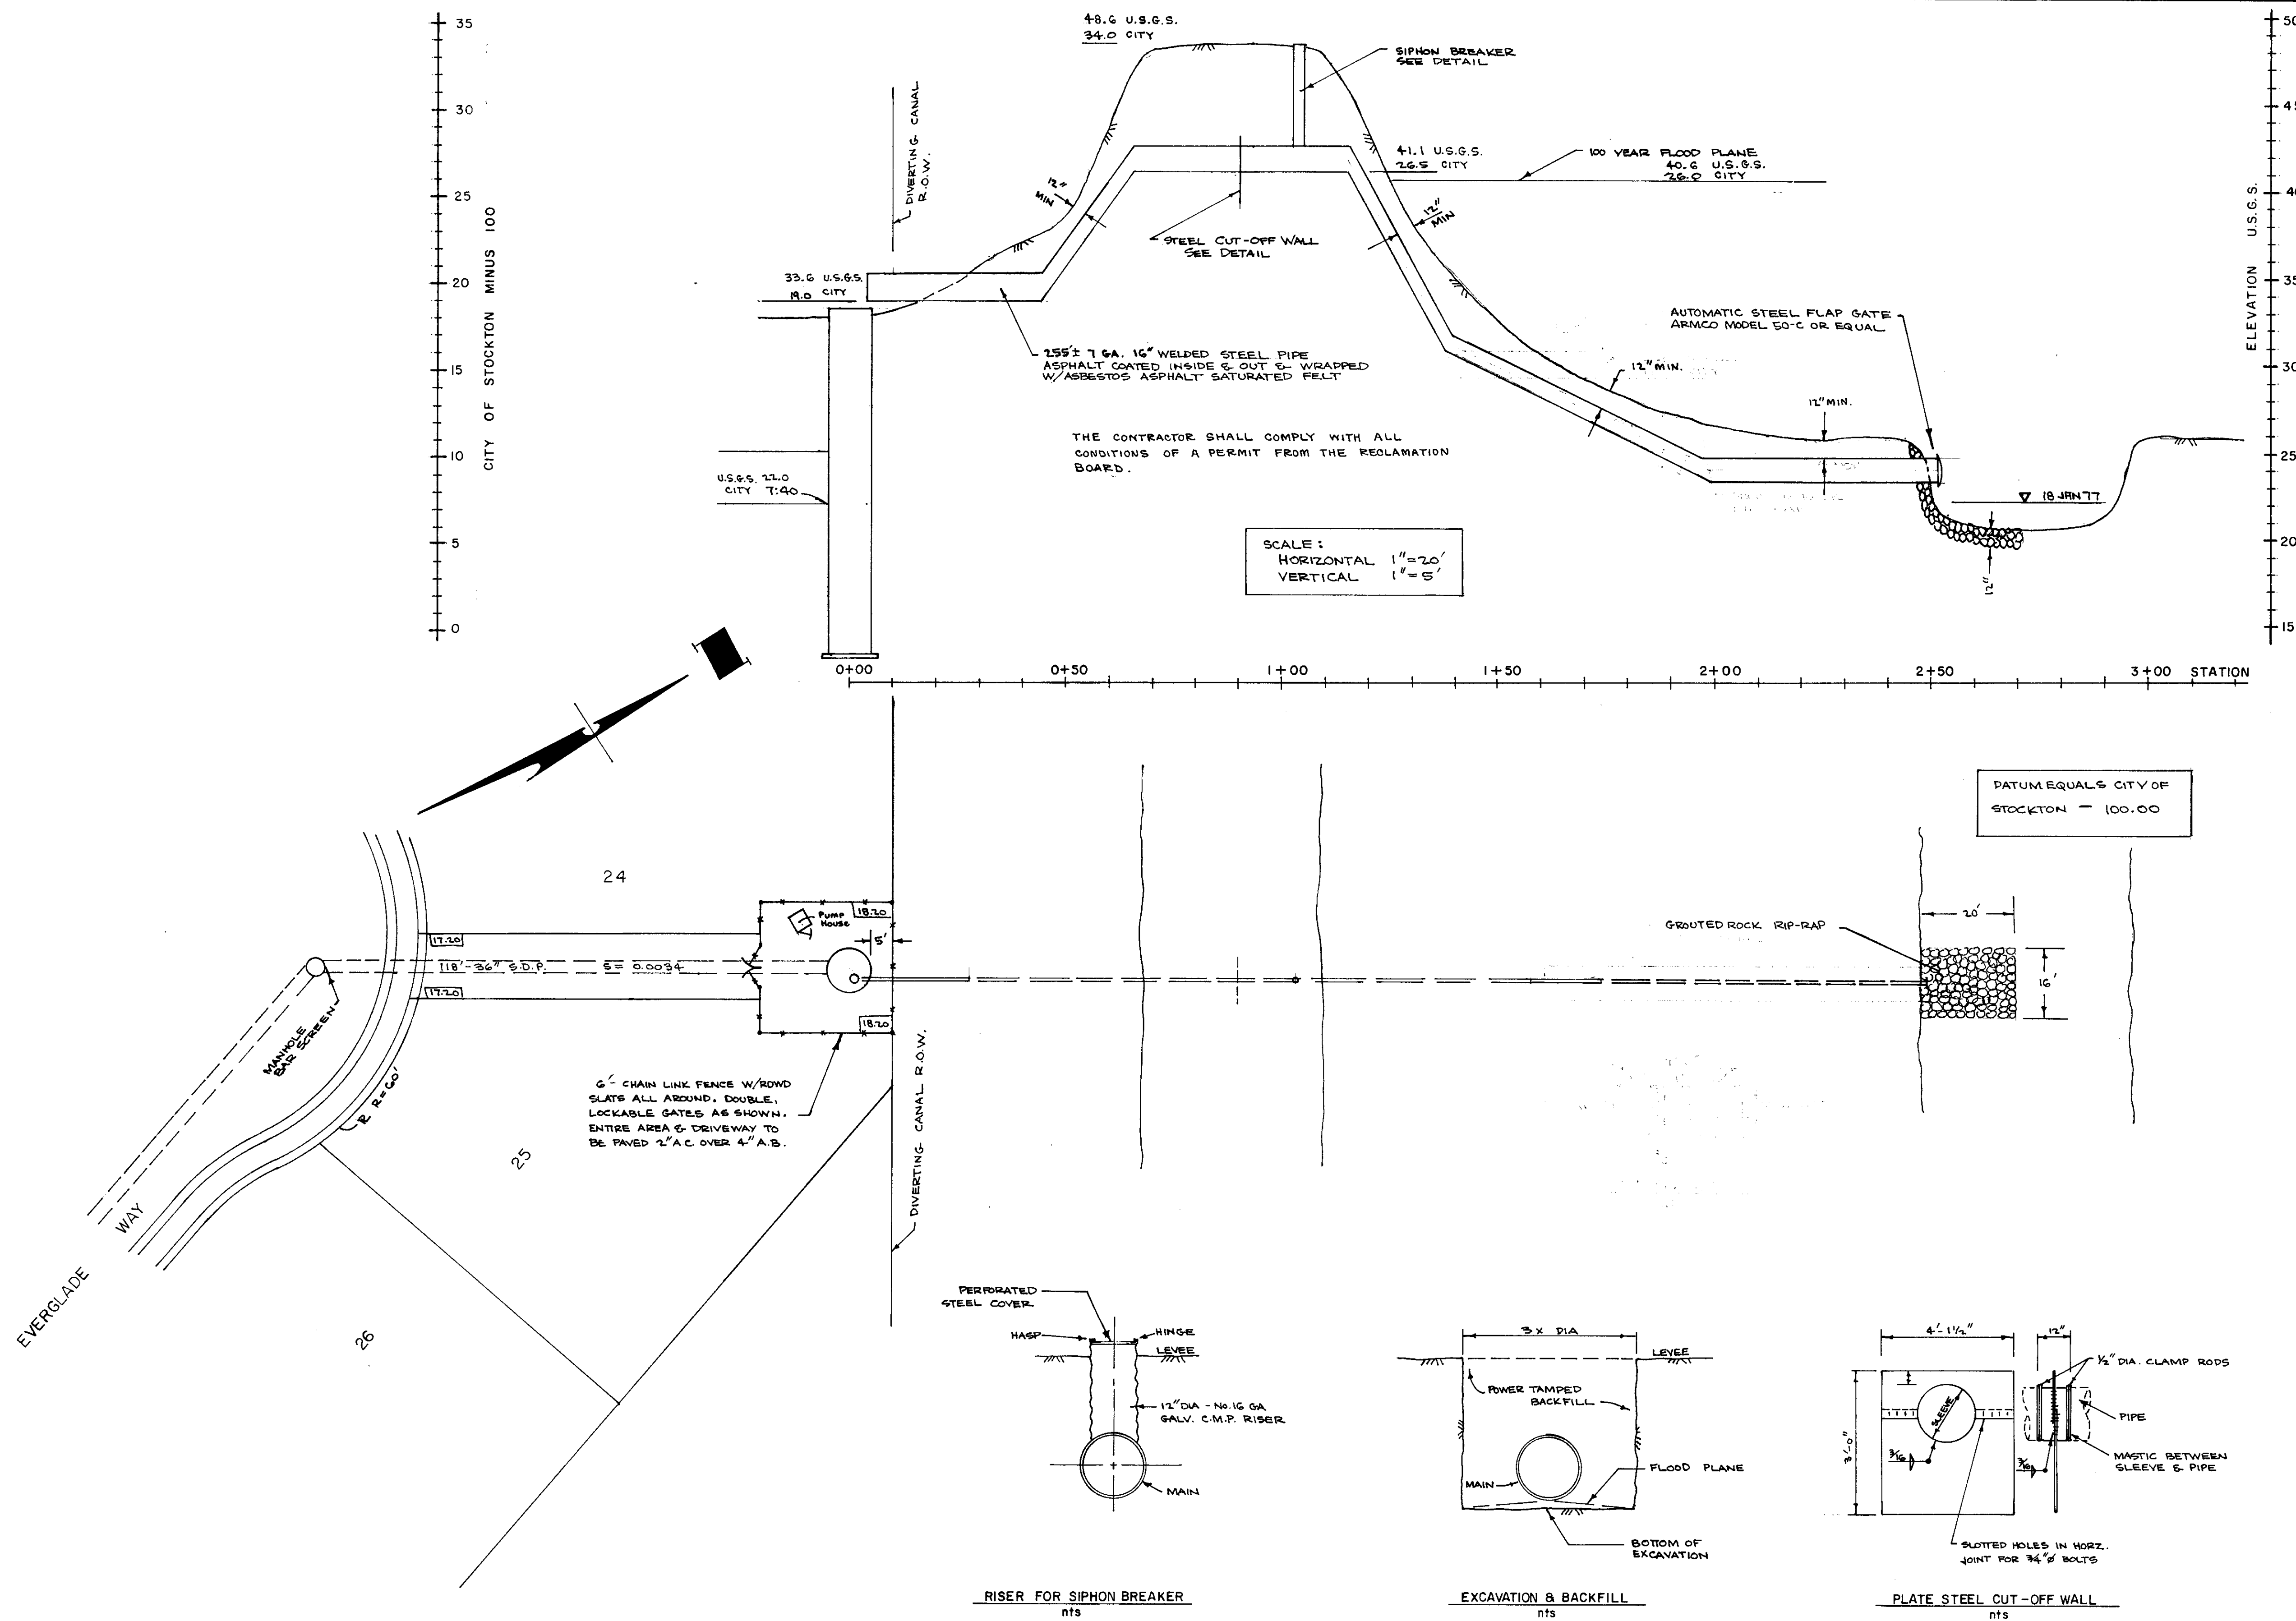

RISER FOR SIPHON BREAKER
 nts

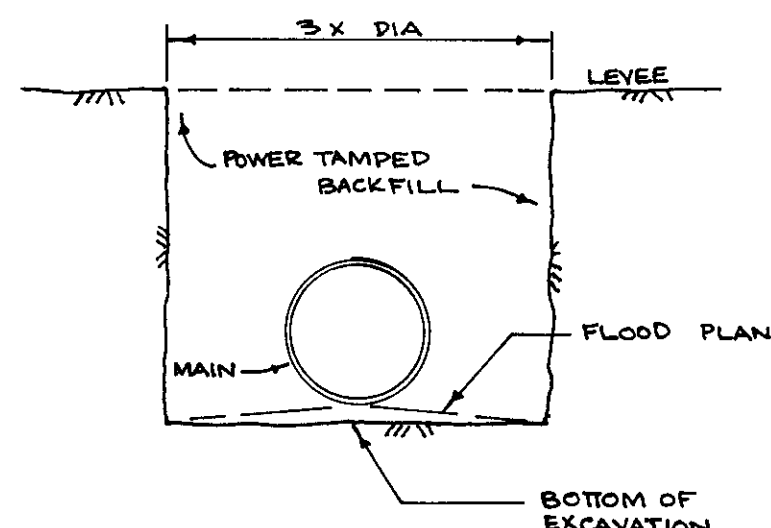

EXCAVATION & BACKFILL
 nts

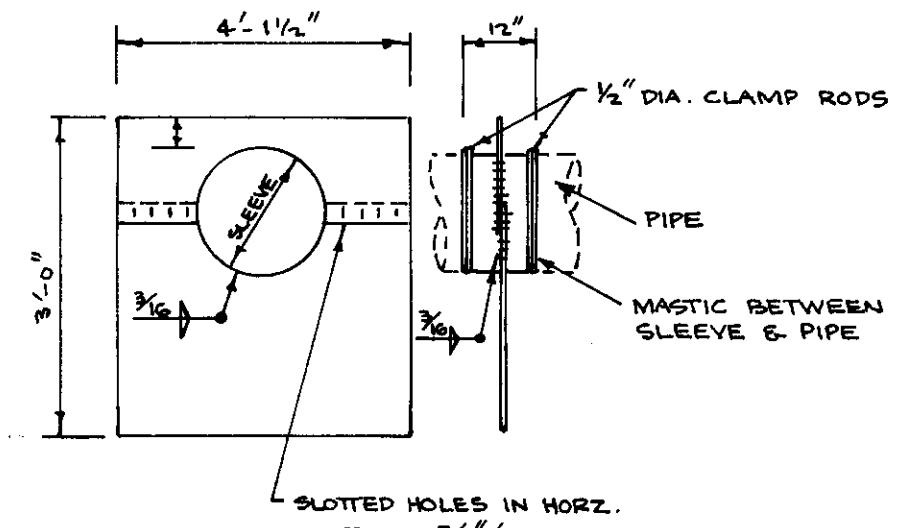


PLATE STEEL CUT-OFF WALL
 nts

APPROVED _____ 19____ APPROVED _____ June 10 1977

William J. Ward


revisions				
no.	description	date	by	


WONG ENGINEERS
 PLANNING • ENGINEERING • SURVEYING
 STOCKTON, CALIFORNIA
E. Chances Wong
 R.C.E. No. 14269

job no. 1637
 date FEB. 1977
 scale AS SHOWN
 drawn *W*
 design WE
 check

TALLAHATCHY TERRACE UNIT NO.1
STORM PUMPING PLANT DETAILS


SHEET
8
 OF TEN
 FILE

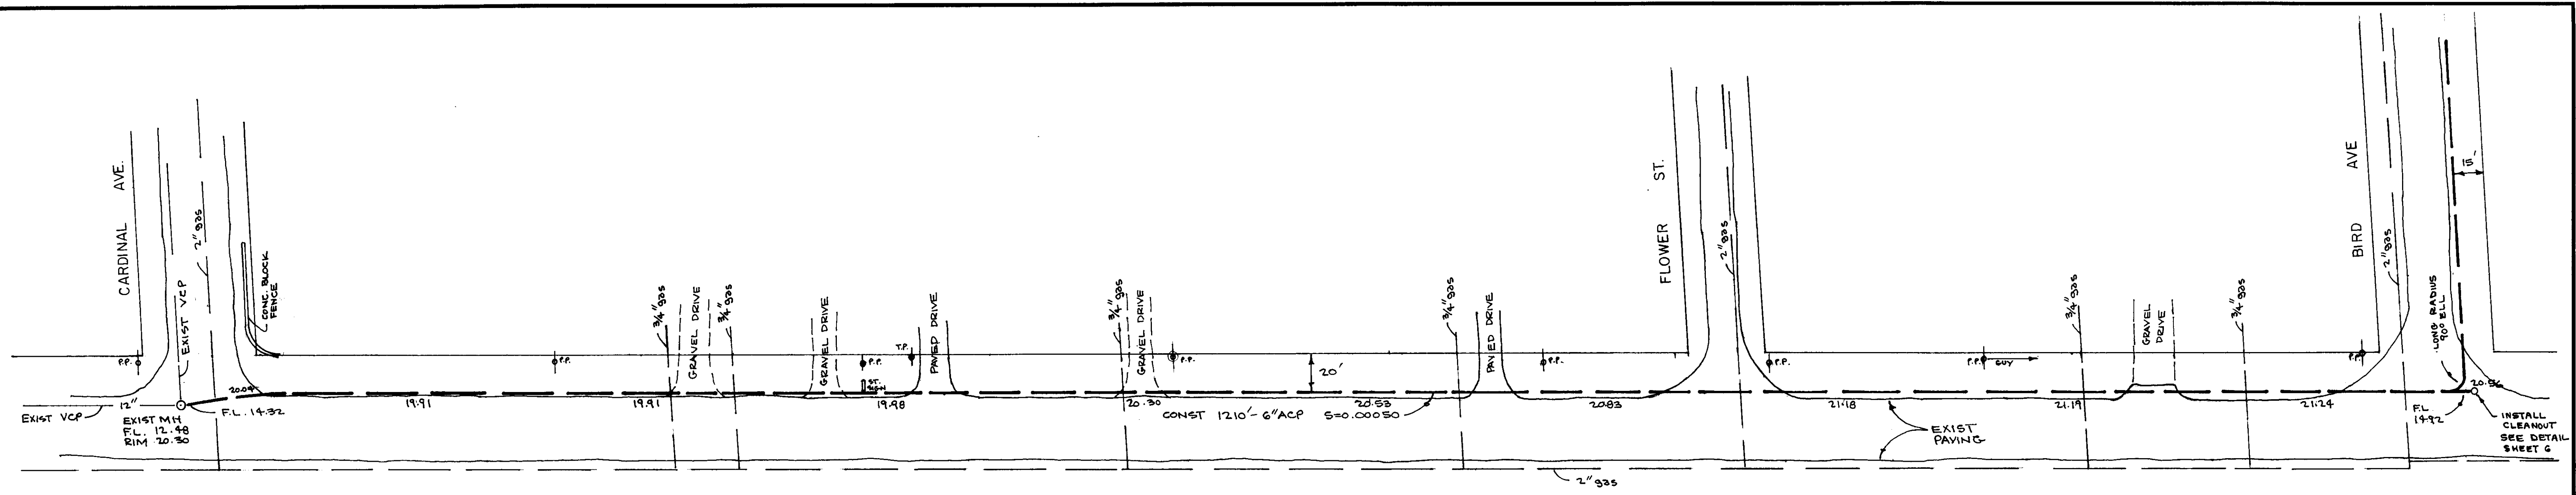

EAST MAIN STREET


SCALE:
HORIZONTAL: 1"=40'
VERTICAL: 1"=4'

CONTRACTOR SHALL VERIFY ALL UTILITY LOCATIONS WITH EACH UTILITY COMPANY. CONTRACTOR SHALL BE RESPONSIBLE FOR ALL REPAIRS, RELOCATIONS TO UTILITIES.

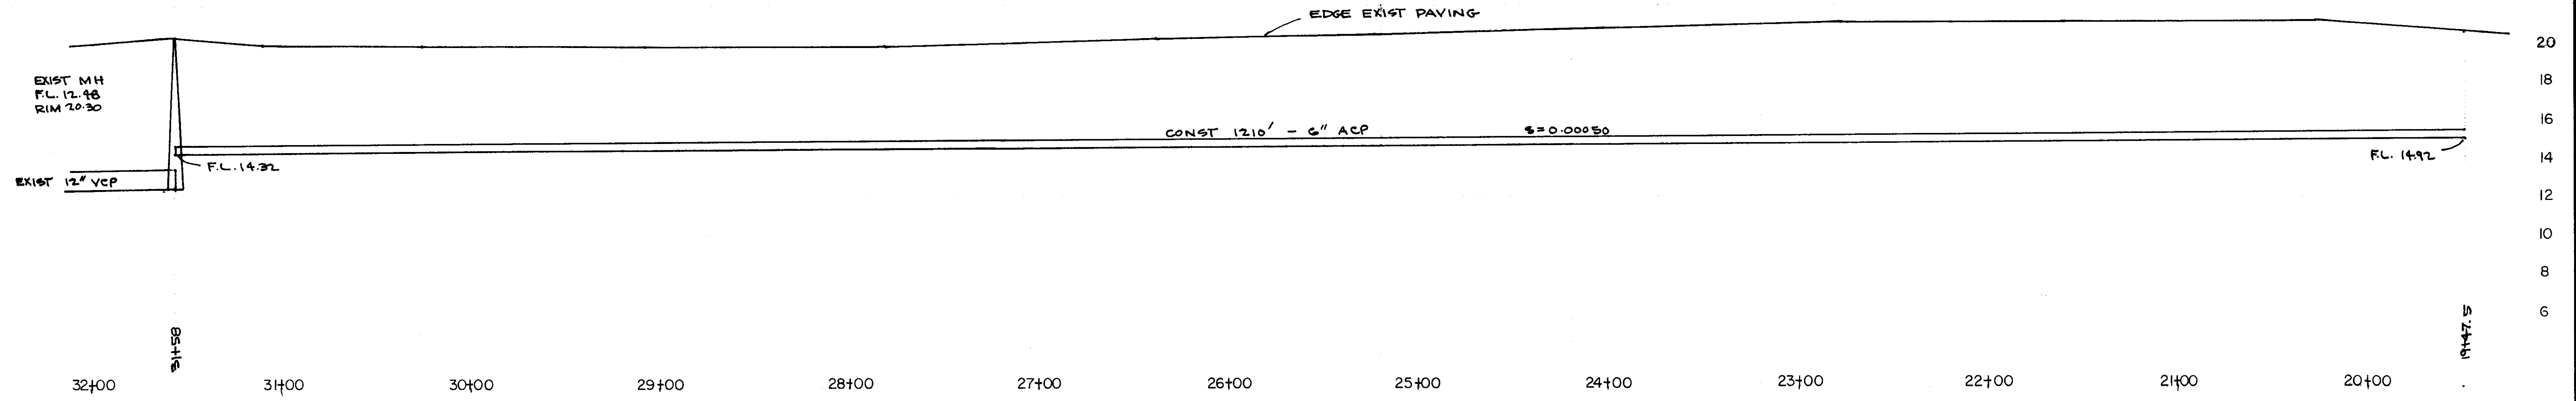


50-1033

APPROVED _____ 19____	APPROVED <u>June 10, 1977</u> <i>William Hand</i> S.J. County Director of Public Works	<table border="1"> <thead> <tr> <th colspan="4">revisions</th> </tr> <tr> <th>no.</th> <th>description</th> <th>date</th> <th>by</th> </tr> </thead> <tbody> <tr> <td> </td> <td> </td> <td> </td> <td> </td> </tr> </tbody> </table>	revisions				no.	description	date	by					 WONG ENGINEERS CIVIL ENGINEERING CONSULTANTS 243 E. CHANNEL ST., STOCKTON, CALIF. <i>James Wong</i> R.C.E. No. 14269	job no. 1637 date _____ f. b. no. _____ drawn <i>WE</i> design <i>WE</i> check _____	TALLAHATCHY TERRACE UNIT NO.1 SEWER FORCE MAIN OUTFALL PLAN	SHEET 7 OF TEN FILE
revisions																		
no.	description	date	by															


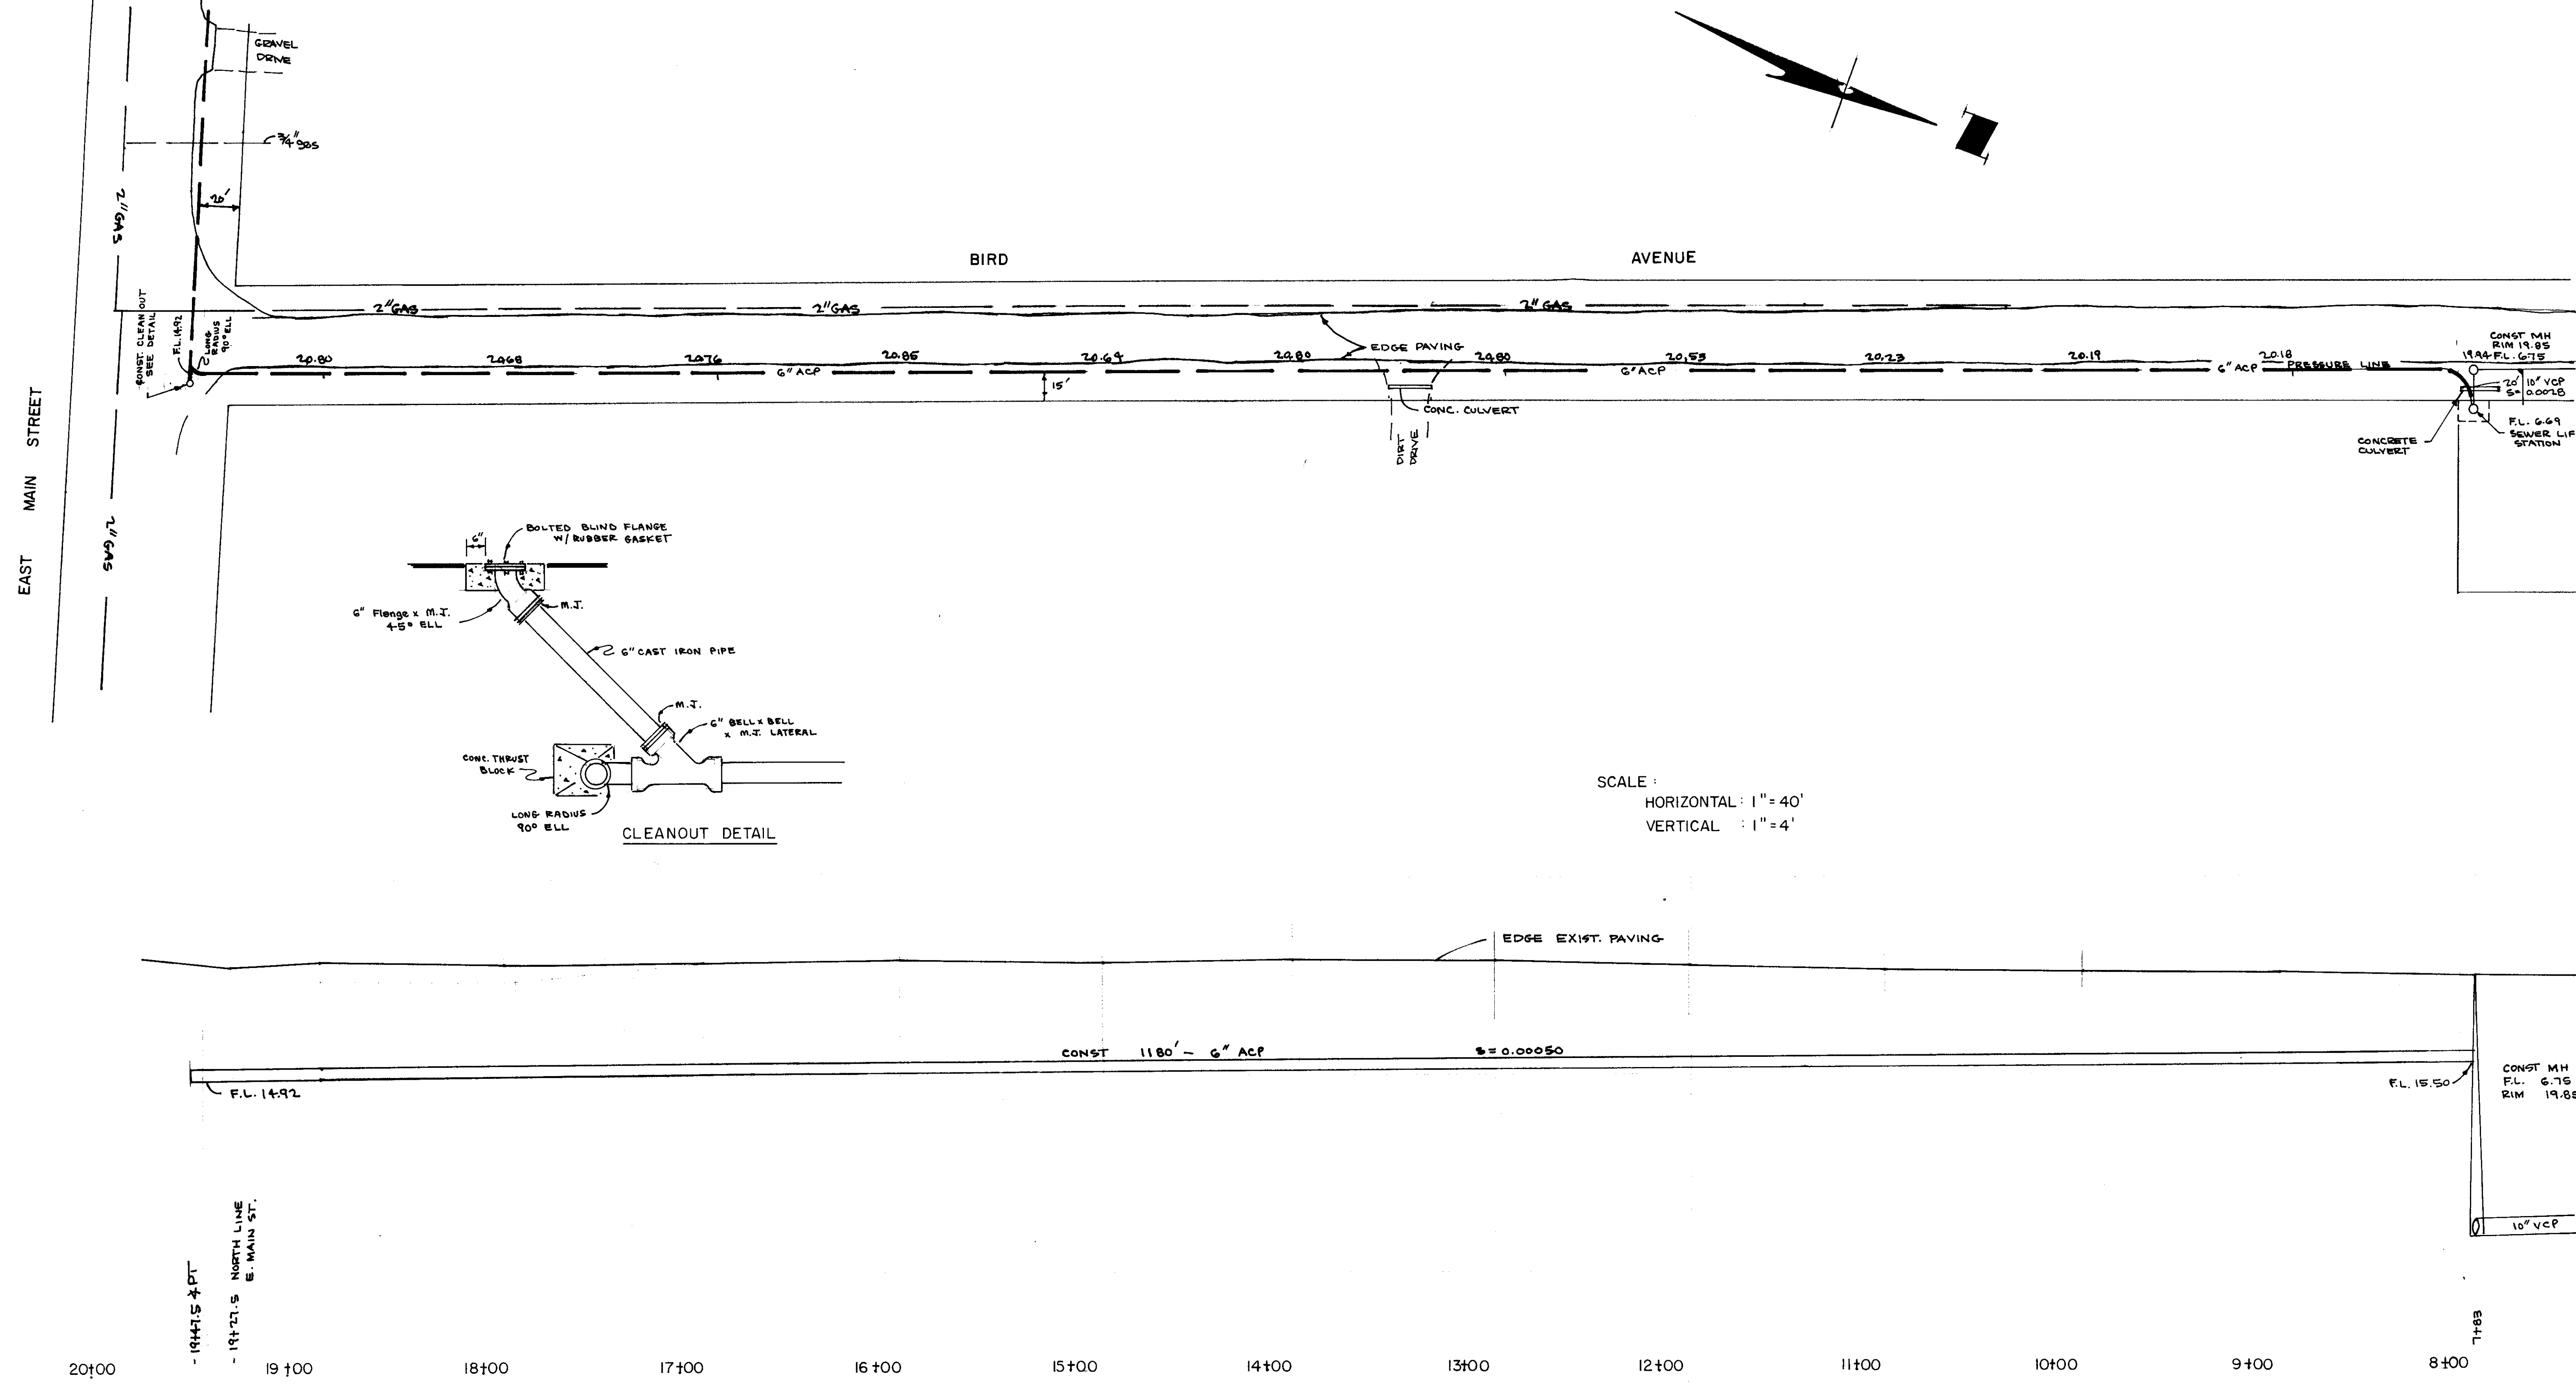


50-131



APPROVED _____ 19__	APPROVED _____ June 10 1977 <i>William J. Stand</i> S.J. County Director of Public Works	<table border="1"> <thead> <tr> <th colspan="4">revisions</th> </tr> <tr> <th>no.</th> <th>description</th> <th>date</th> <th>by</th> </tr> </thead> <tbody> <tr> <td> </td> <td> </td> <td> </td> <td> </td> </tr> </tbody> </table>	revisions				no.	description	date	by					 WONG ENGINEERS CIVIL ENGINEERING CONSULTANTS 243 E. CHANNEL ST., STOCKTON, CALIF. <i>Chancey Wong</i> R.C.E. No. 14269	job no. 1637 date _____ f. b. no. _____ drawn <i>lp</i> design WE check _____	TALLAHATCHY TERRACE UNIT NO.1 SEWER FORCE MAIN OUTFALL PLAN	SHEET 6 OF TEN FILE
revisions																		
no.	description	date	by															

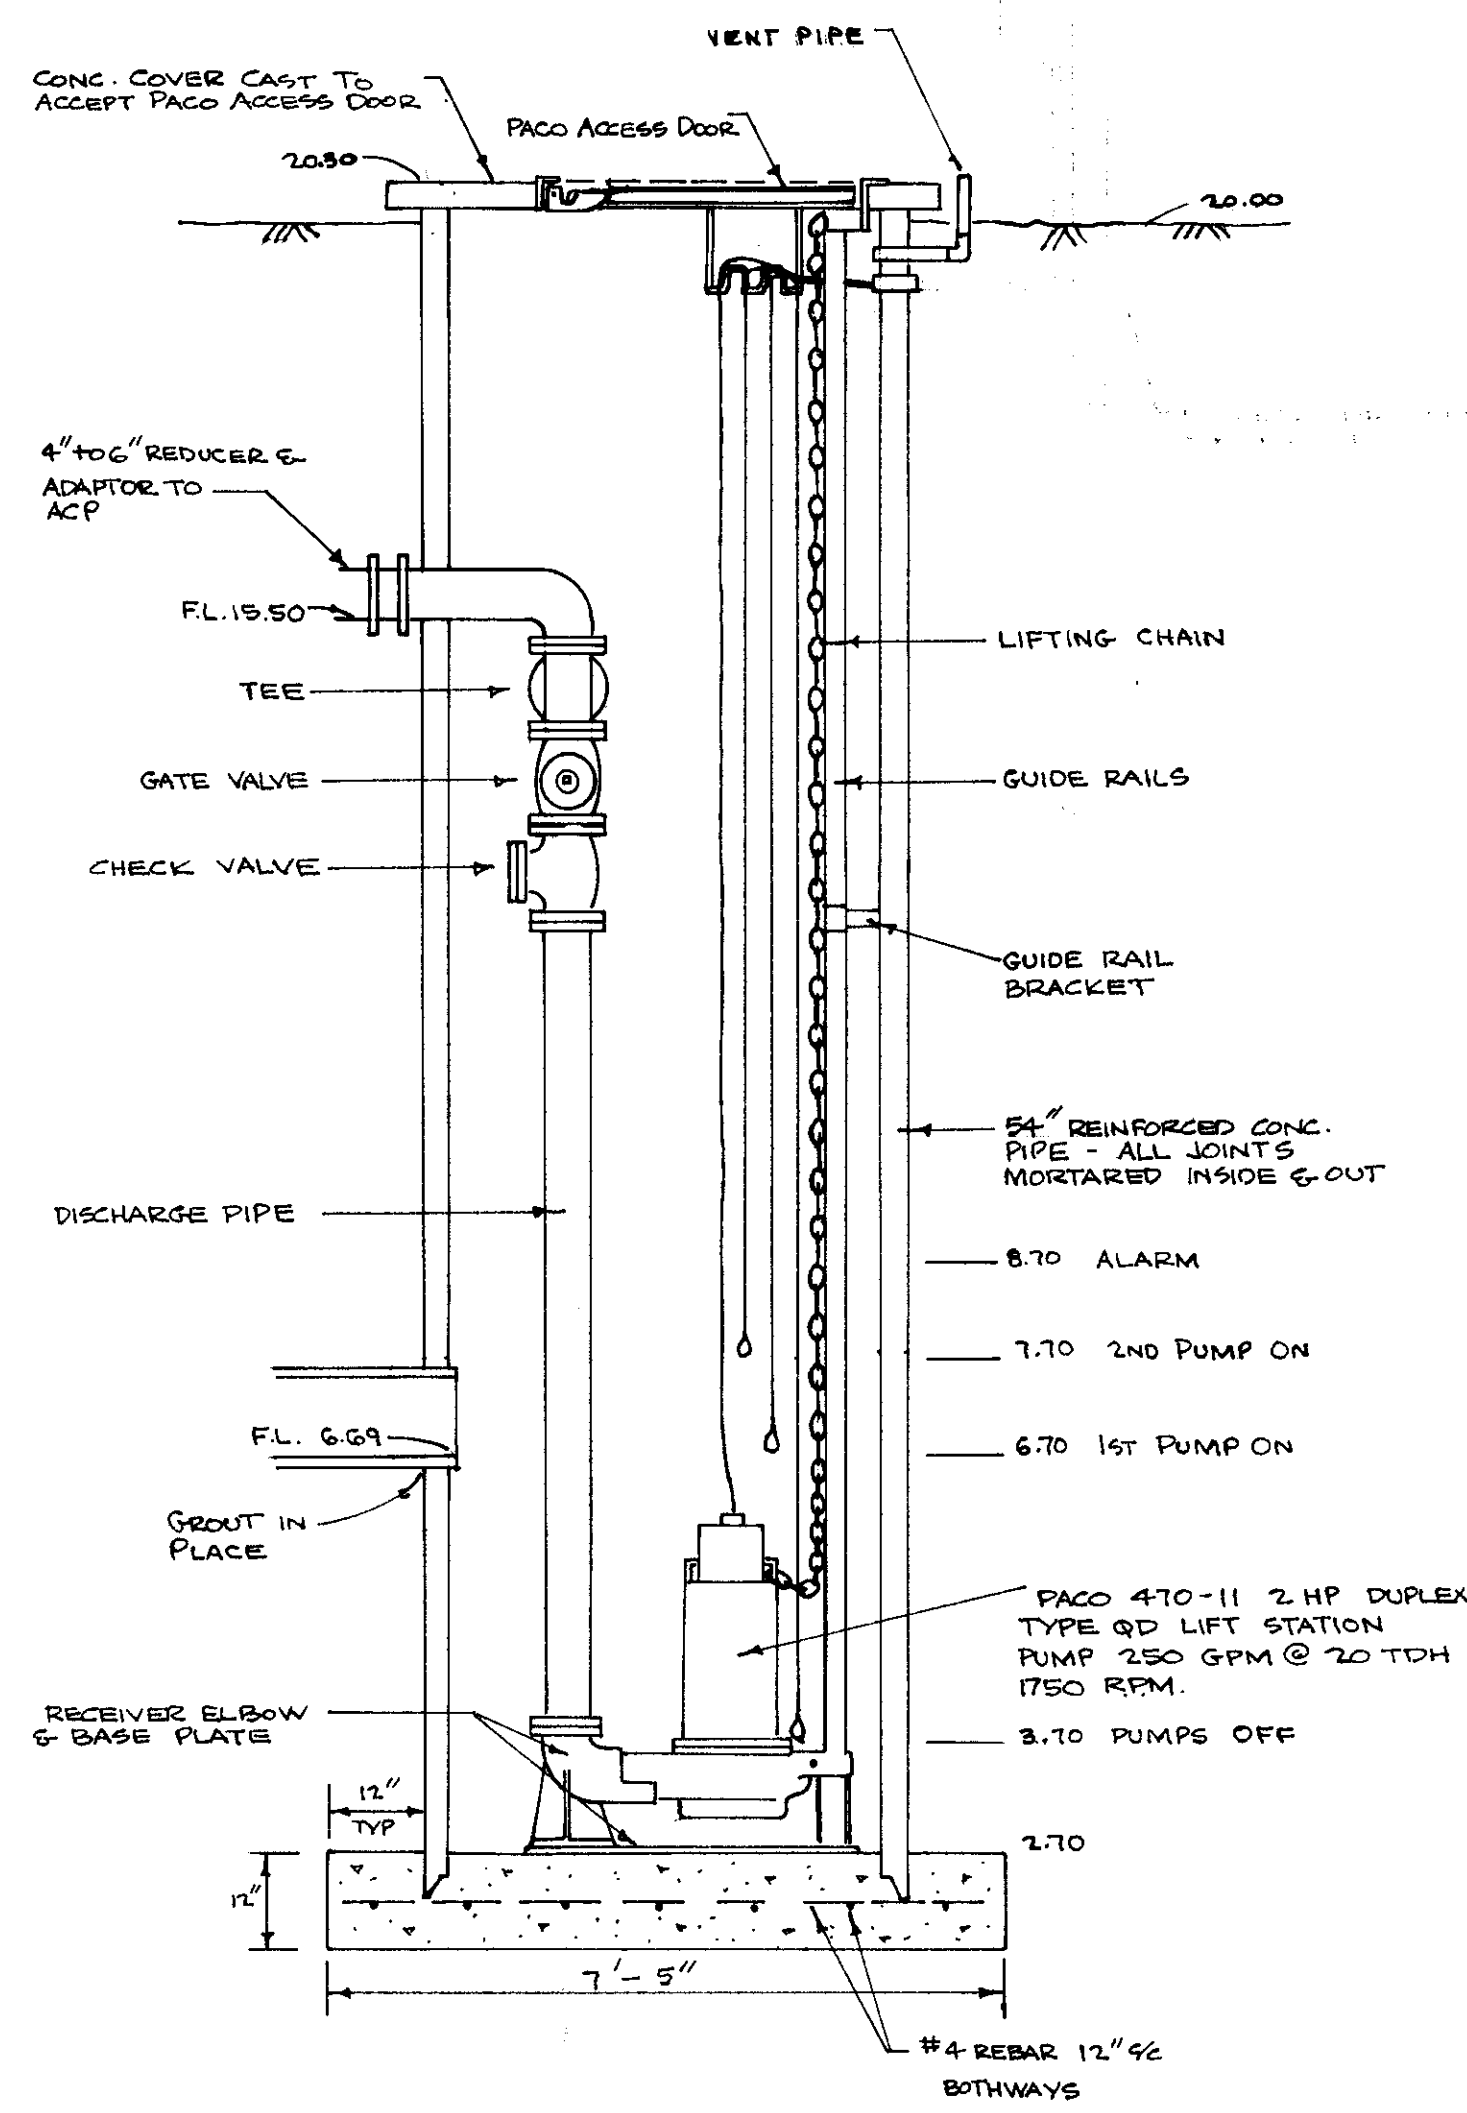


DETAIL
1/2" = 1'-0"

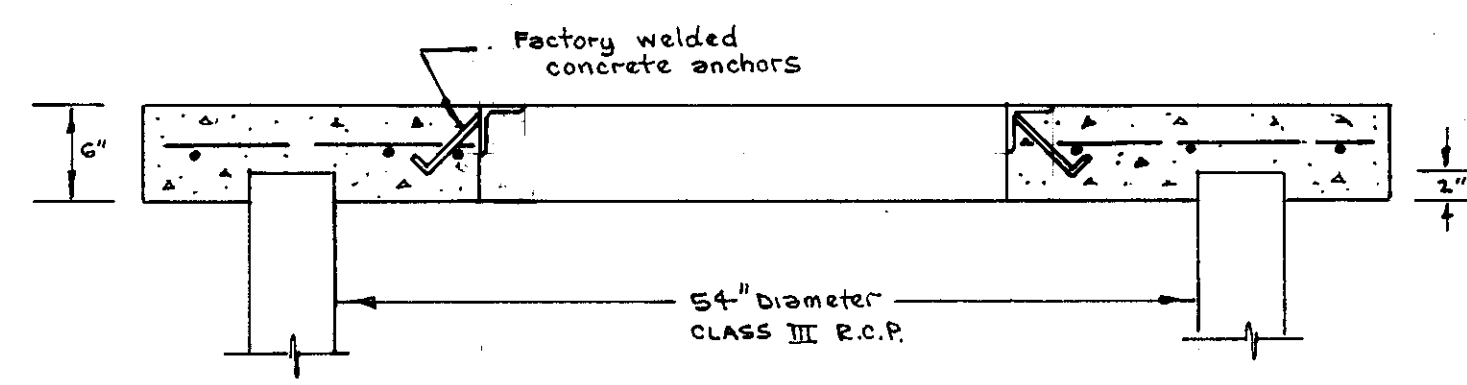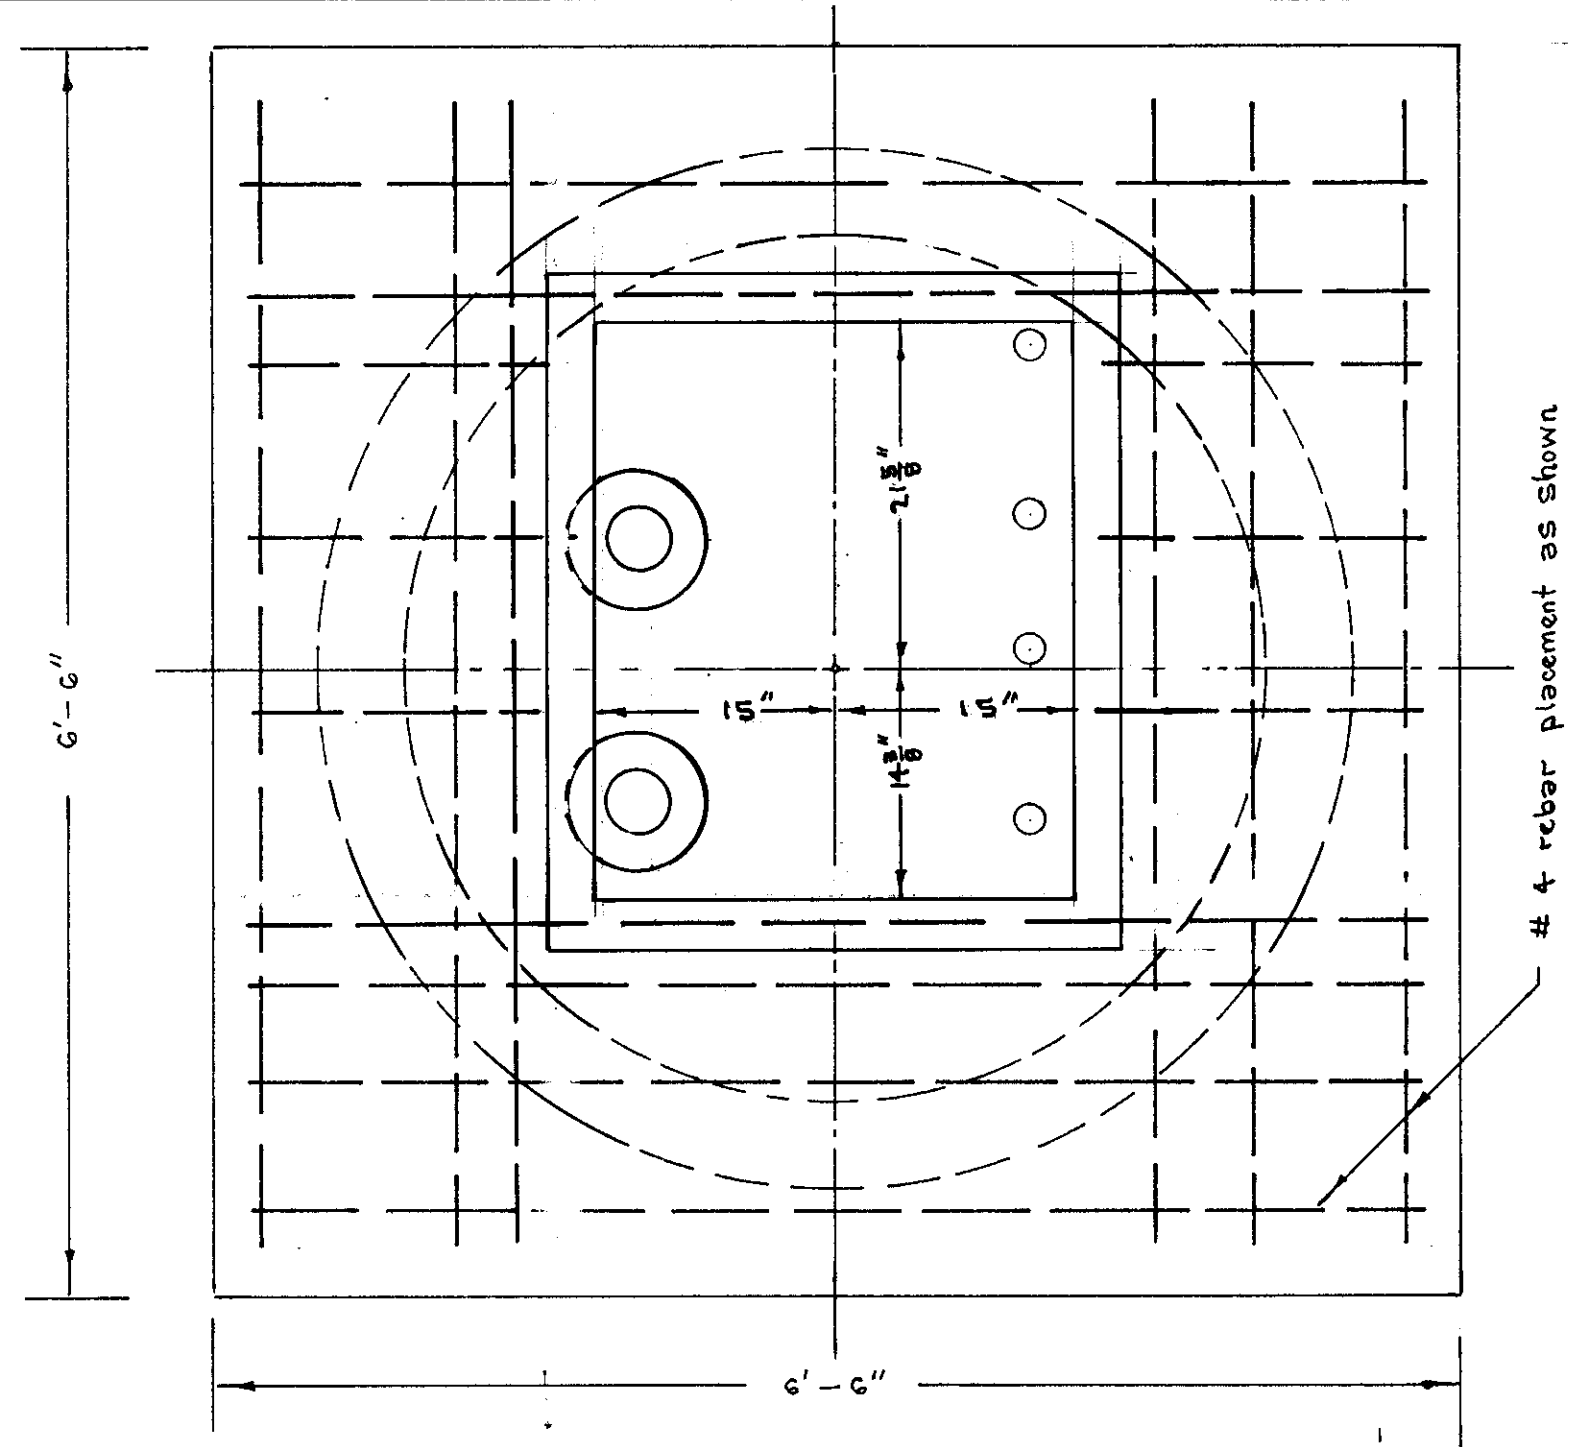

LIFT STATION COVER DETAIL
SCALE 1" = 1'-0"

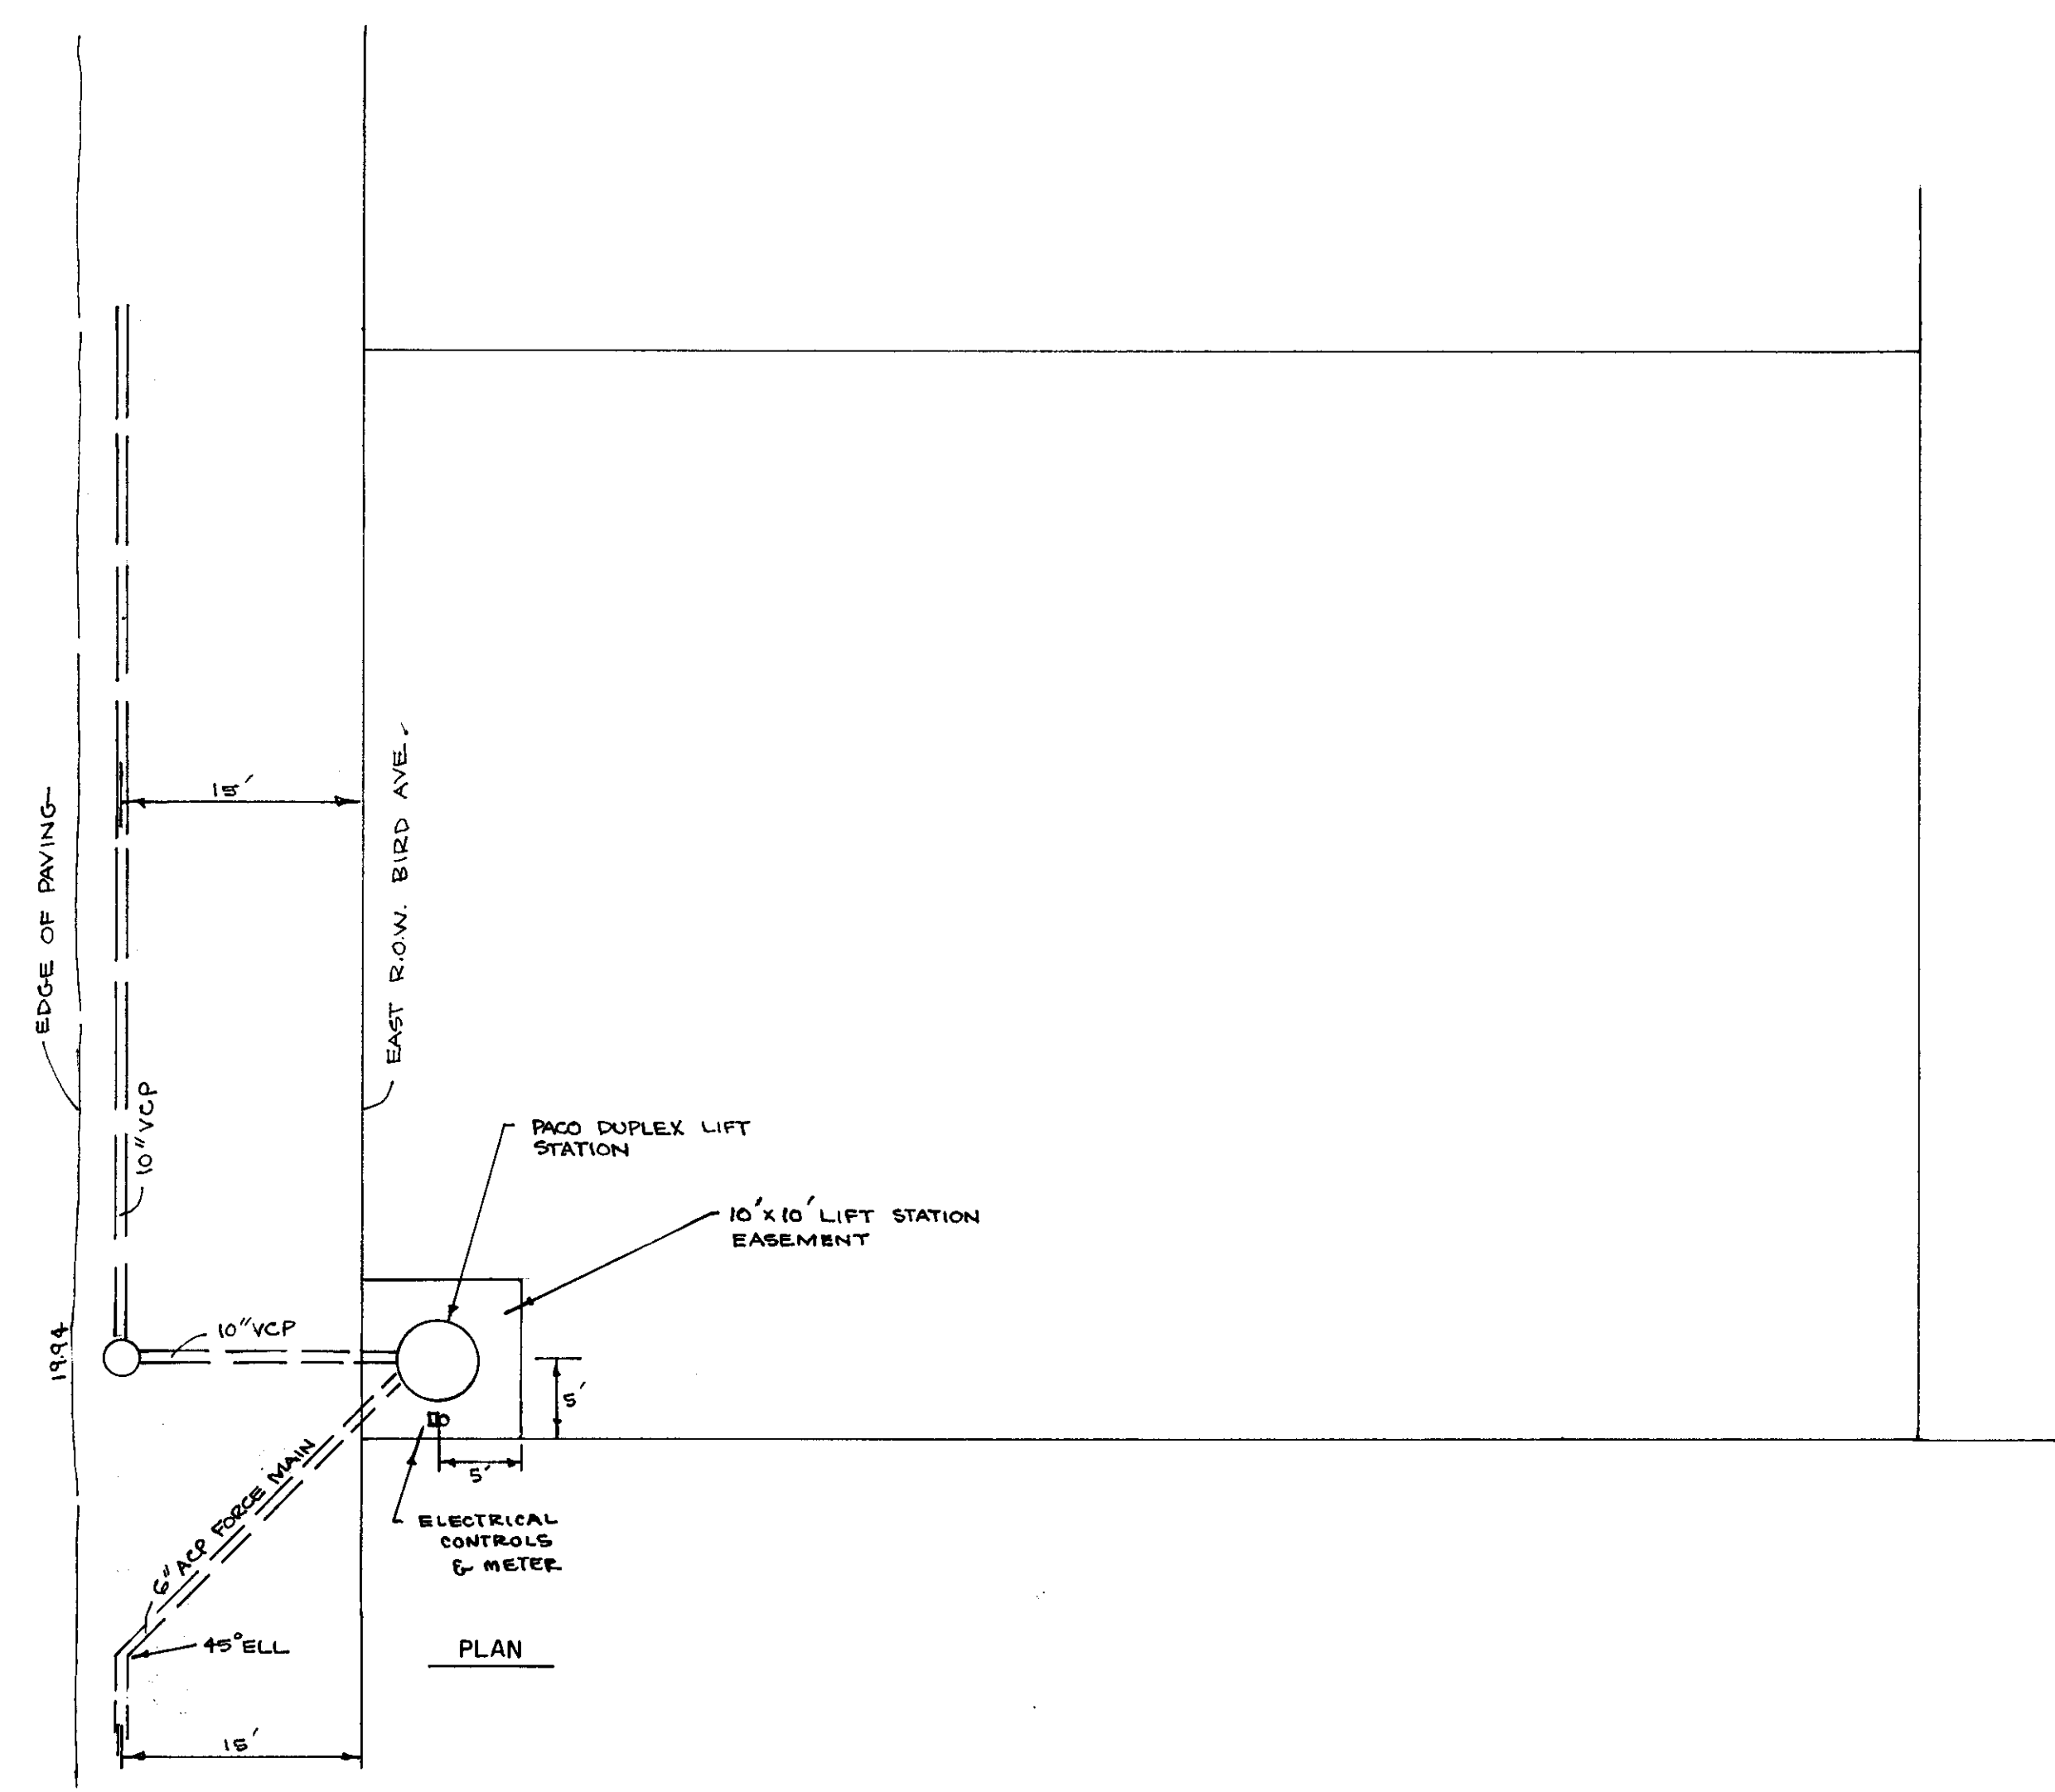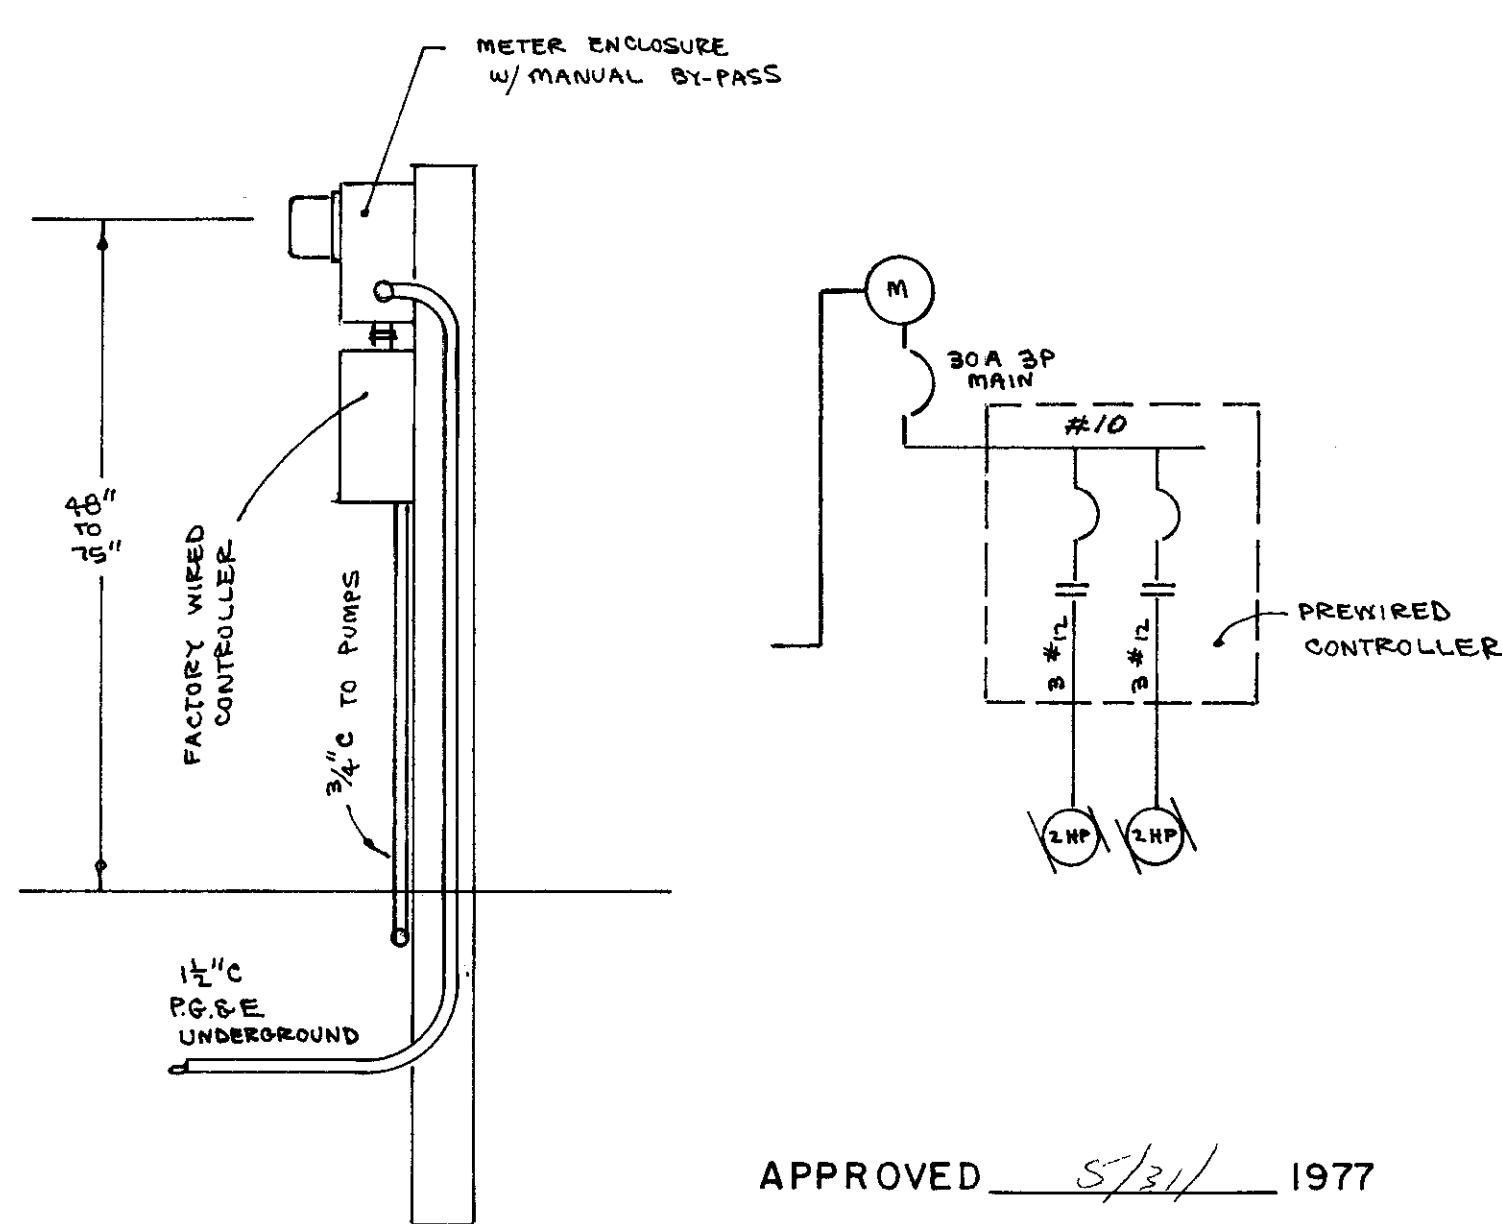

SCALE:
HORIZONTAL: 1" = 10'
VERTICAL: 1" = 4'

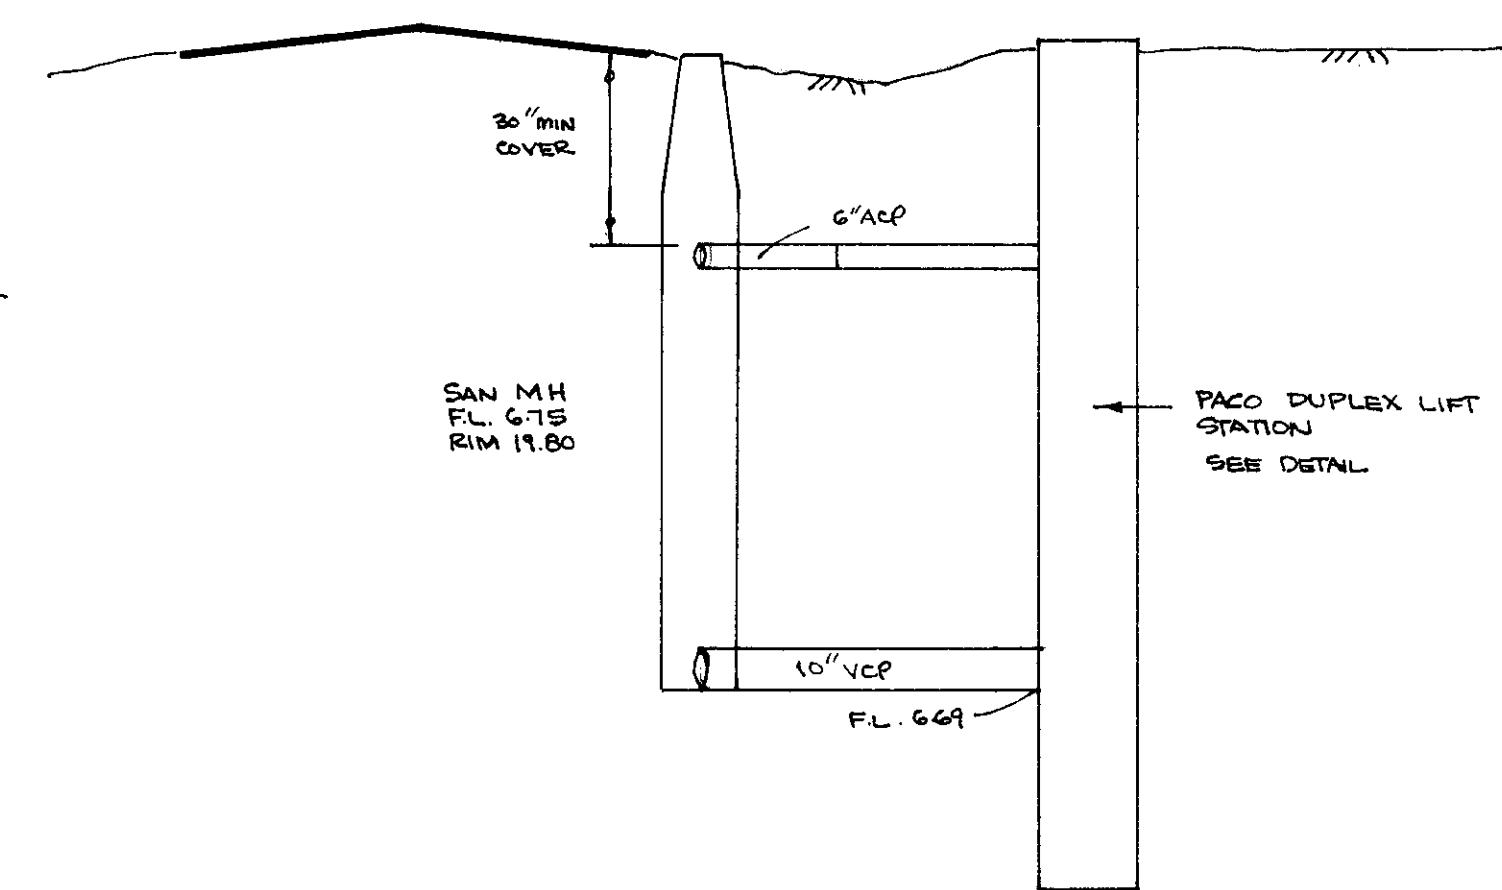

SECTION

APPROVED _____ 19 _____

APPROVED June 10 1977

William H. Hays
S.J. County Director of Public Works

revisions			
no.	description	date	by



WONG ENGINEERS
PLANNING • ENGINEERING • SURVEYING
STOCKTON, CALIFORNIA

Charles Wong

R.C.E. No. 14269


job no. 1637
date
scale AS SHOWN
drawn *W*
design WE
check

TALLAHATCHY TERRACE UNIT NO. 1


SANITARY SEWER LIFT STATION DETAILS

SHEET
5
OF TEN
FILE

50-1035

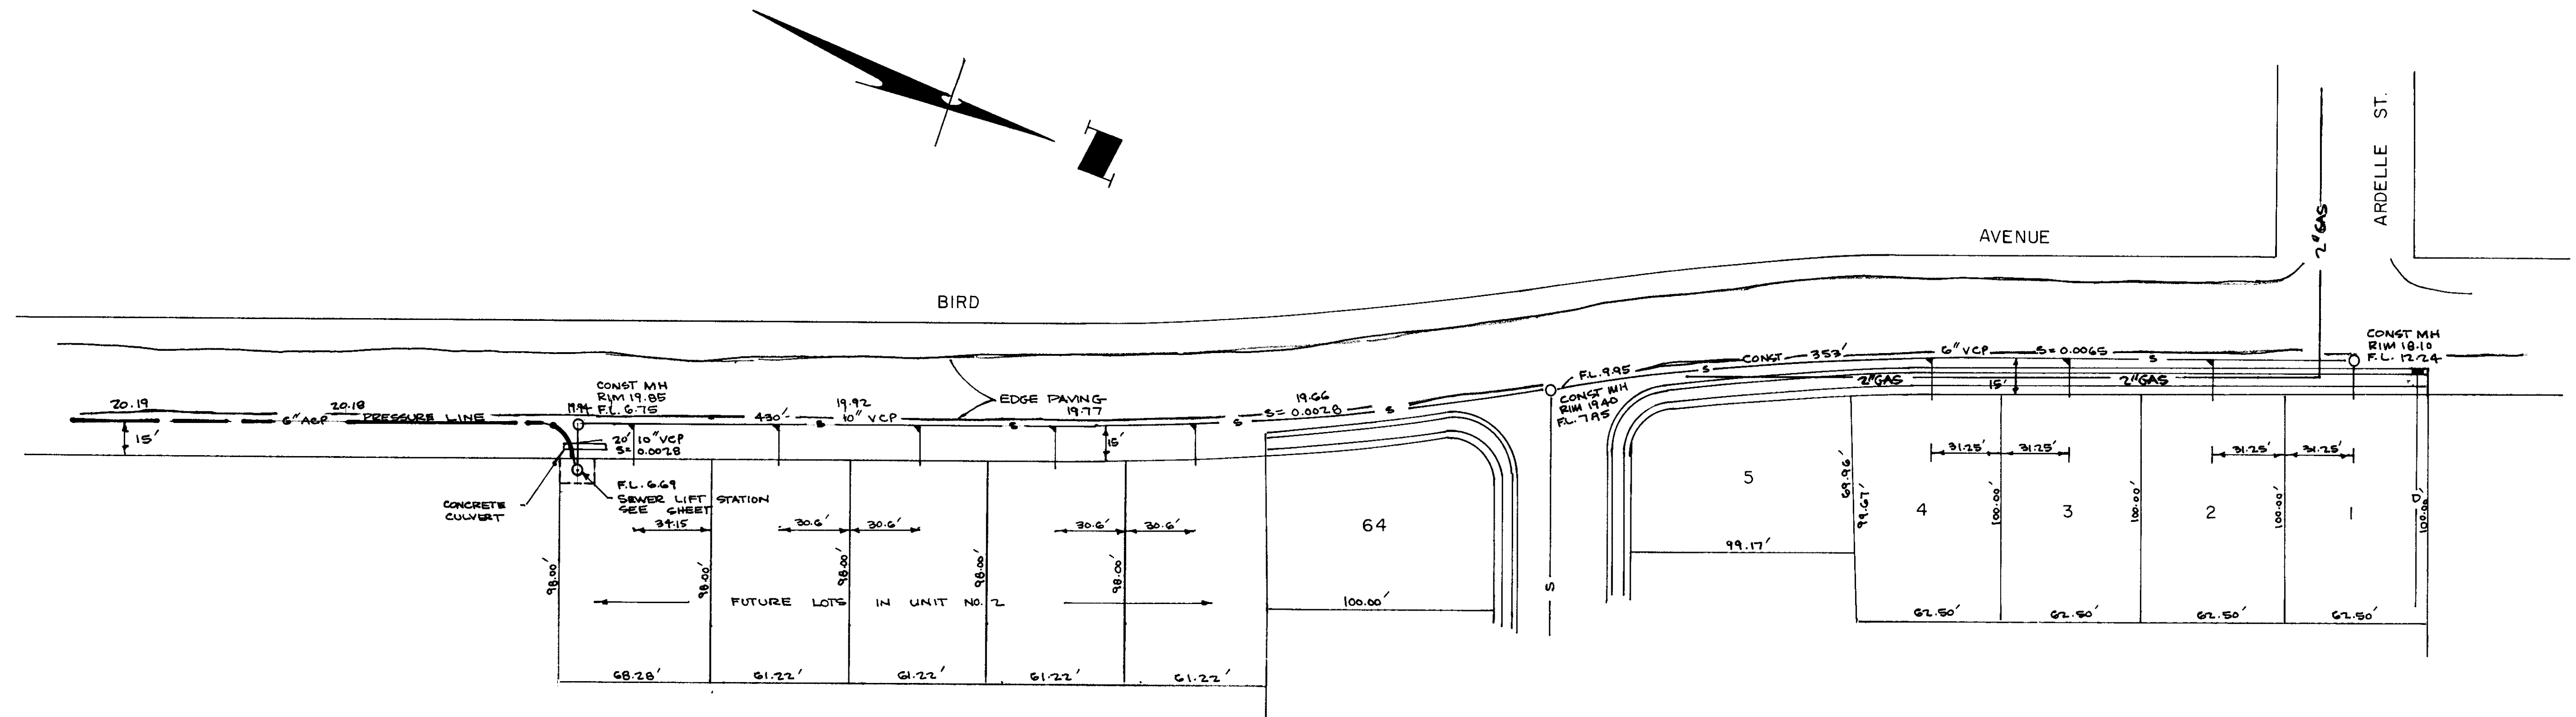

SCALE:
HORIZONTAL: 1" = 40'
VERTICAL: 1" = 4'

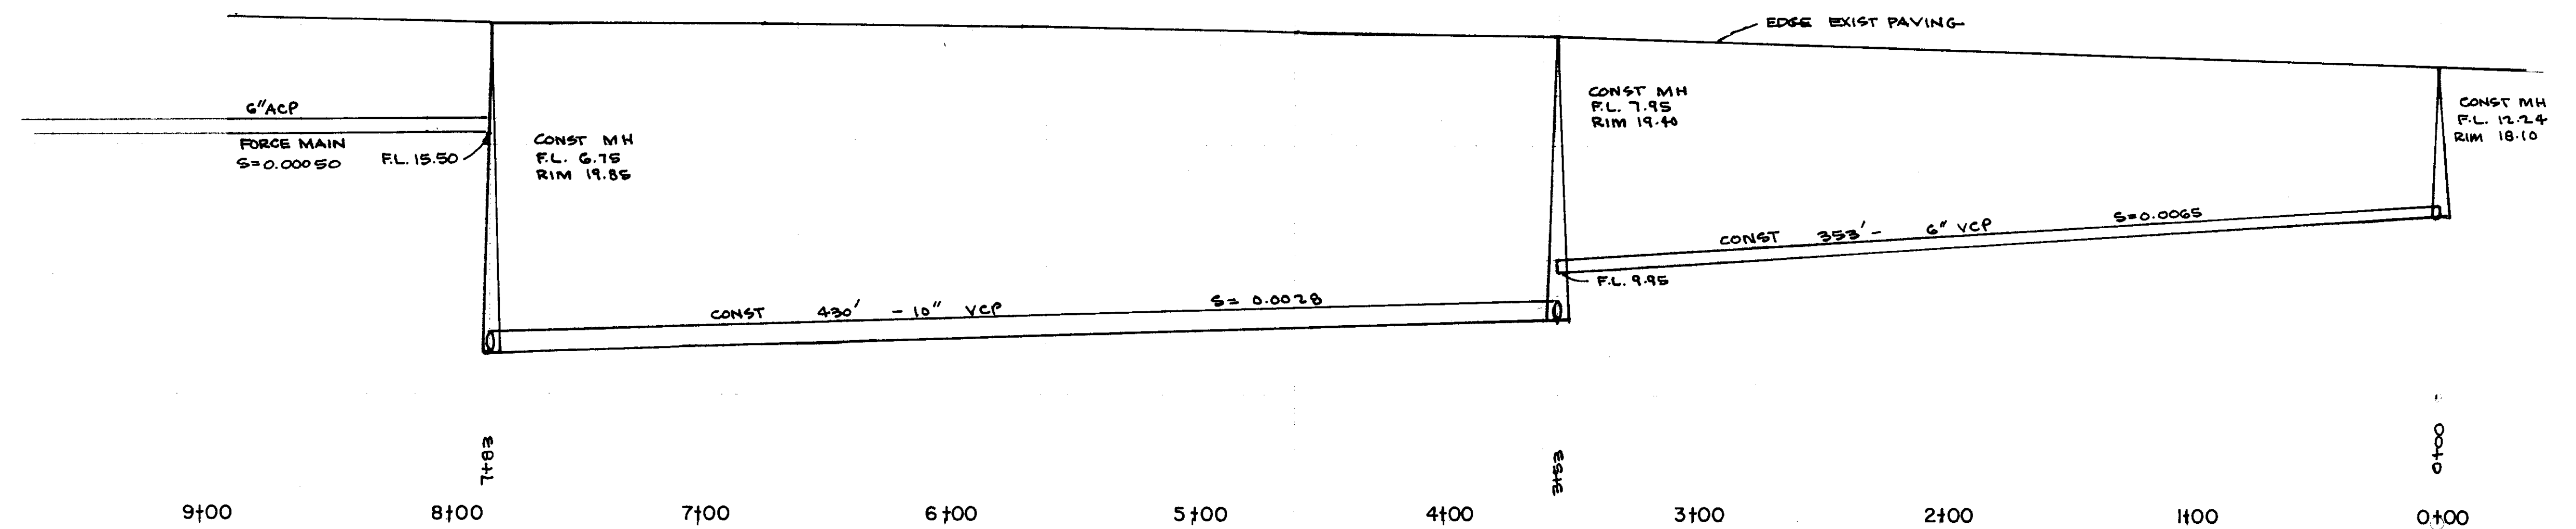

20
18
16
14
12
10
8
6

APPROVED _____ 19 _____

APPROVED June 10 19 77

William J. Davis
S.J. County Director of Public Works

revisions			
no.	description	date	by



WONG ENGINEERS
CIVIL ENGINEERING CONSULTANTS
243 E. CHANNEL ST., STOCKTON, CALIF.

R.C.E. No. 14269


job no. 1637
date _____
f. b. no. _____
drawn WE
design WE
check _____

TALLAHATCHY TERRACE UNIT NO.1

BIRD AVE. SEWER & FORCE MAIN OUTFALL PLAN

SHEET
4
OF TEN
FILE

50-1036

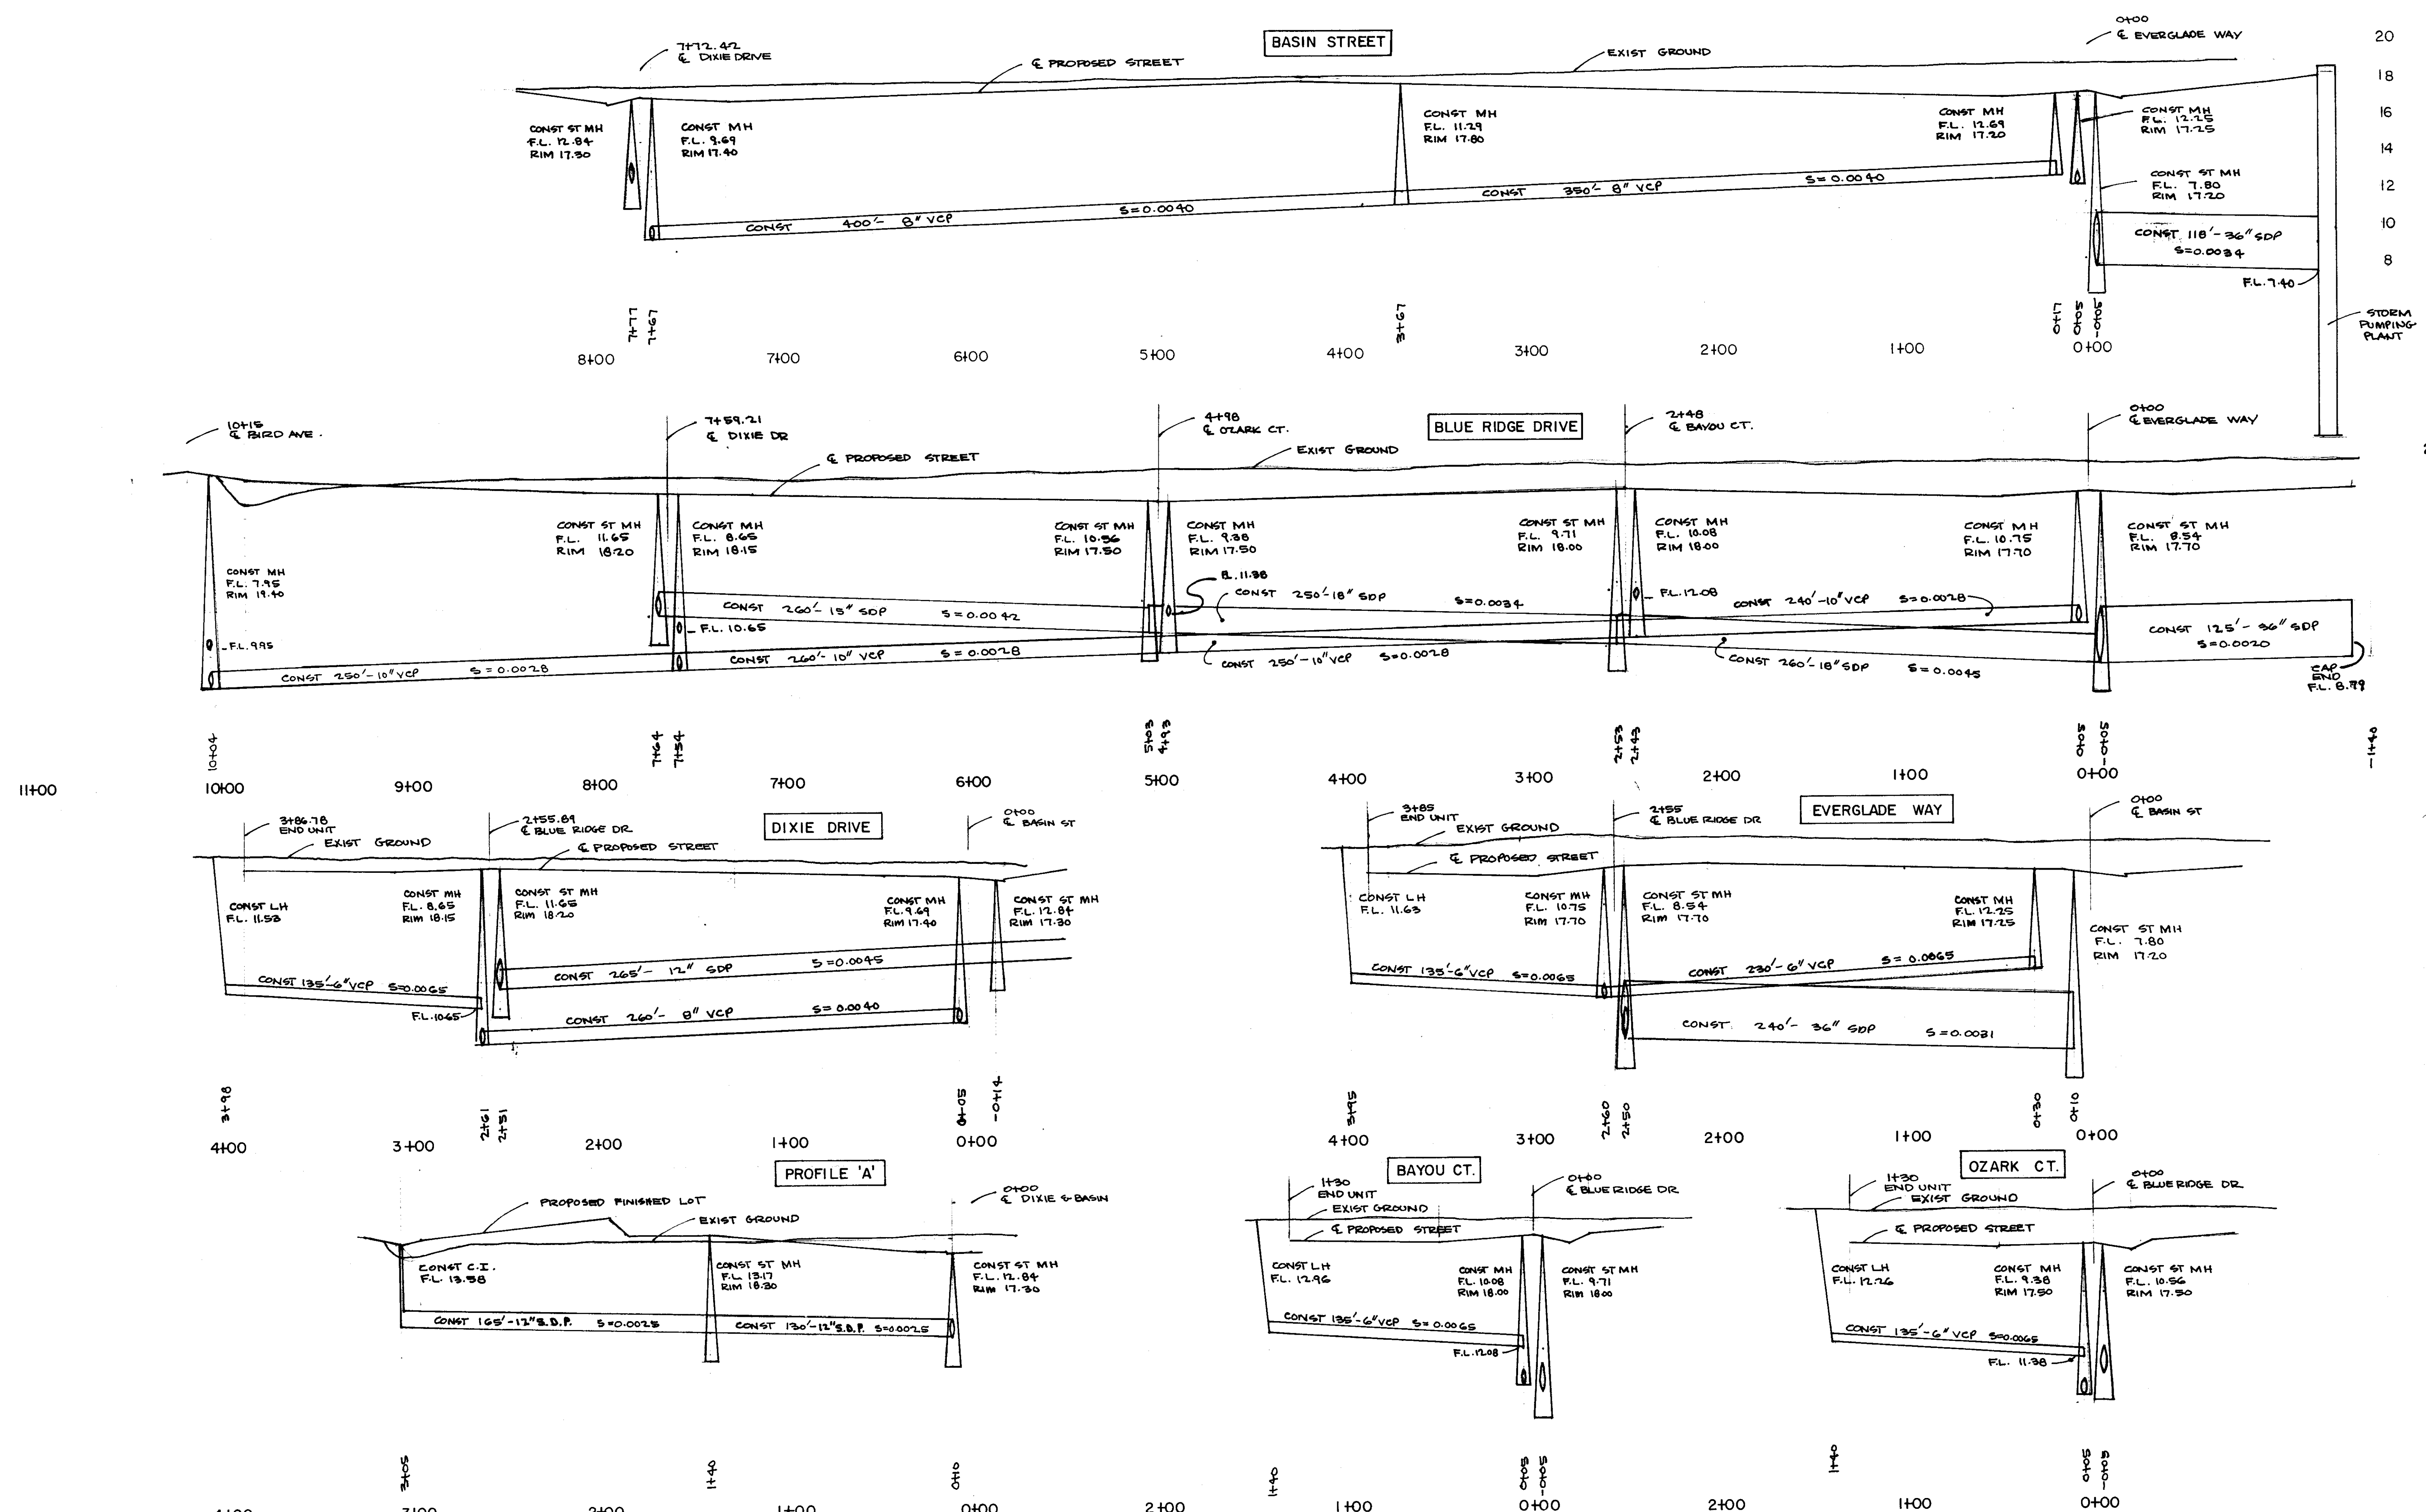


34.1037

ARDELLE ST.

AVENUE

318

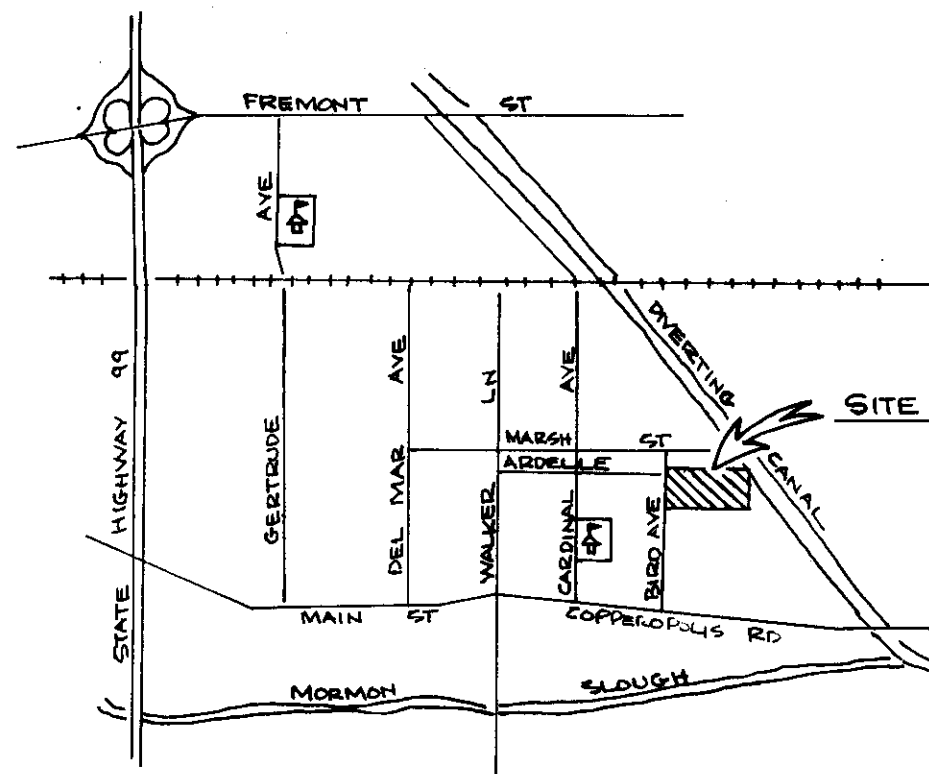

VICINITY MA
1" = 1/2 MI.

NOTE:
DATUM EQUALS CITY OF
STOCKTON - 100.00

SAINT JOSEPH'S BOARD OF DIRECTORS DISTRICT
1601 E. 1st Ave. Phone: 466-8761
P.O. Box 2009 — Stockholm, Calif. 94426
☒ Approved
☐ Obtain a Sanitation Permit
☐ Obtain a Water Well Permit
☐ Disapproved: See Remarks
REMARKS: City, H.G.D.G. City Sec
Date: 10/2/2010 By: Paul B...

BARRICADE - TYPE "A" OR "B" CO. DRWG. NO. G-5
CENTER LINE MONUMENT CO. DRWG. NO. G-4
STREET LIGHT 175 W OR AS NOTED
WHEEL CHAIR RAMP
STREET SIGN CO. DRWG. NO. G-3

APPROVED _____ 19____

APPROVED *June 10* 1977

William J. Ward
S. J. County Director of Public Works

revisions			
no.	description	date	by



WONG ENGINEERS
PLANNING • ENGINEERING • SURVEYING
STOCKTON, CALIFORNIA

R.C.E. No. 14269

job no.	1637
date	
scale	1" = 40'
drawn	BP
design	WE
check	

TALLAHATCHEY TERRACE UNIT NO.1

STREET WORK AND GRADING PLAN

SHEET
1
TEN