


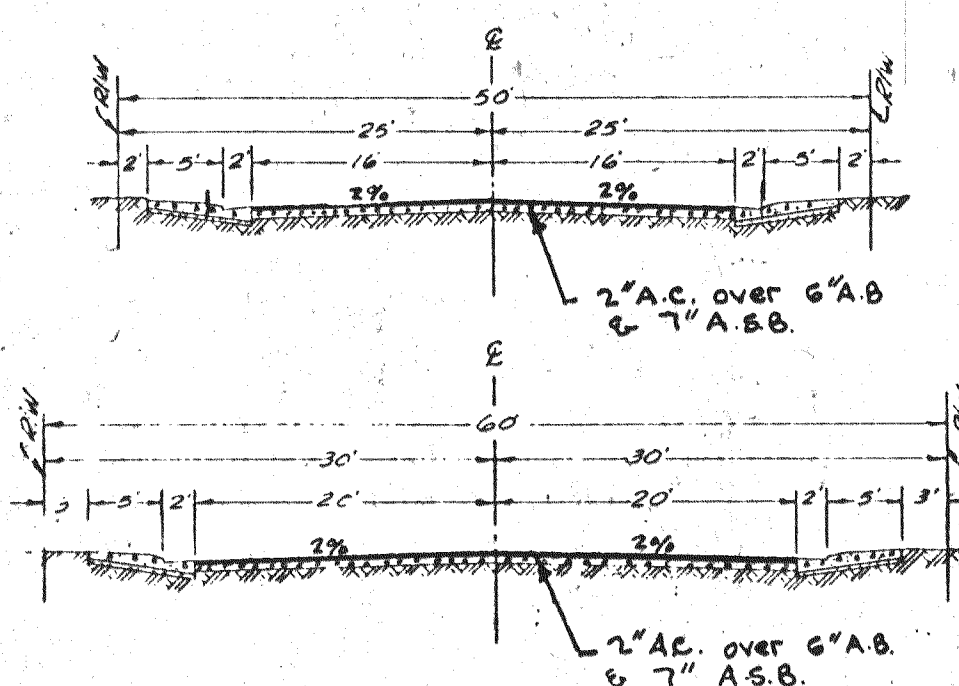


TYPICAL SUBDIVISION STREETS

Note:
1. The structural section shall be determined by Improvement Standard No A-1
2. For curb, gutter and sidewalk details see Improvement Standard No B-1 & No B-2


T.I. = 4.0
R-YALVE = 5.0

T.I. = 5.0
R-YALVE = 5.0


NOTES:
1. RELATIVE COMPACTION OF MATERIALS SHALL BE TESTED BY STATE OF CALIFORNIA, DEPT. OF PUBLIC WORKS, DIVISION OF HIGHWAYS, TEST METHOD NO. CALIFORNIA 515 F.
2. ALL EXISTING PAVEMENT SHALL BE NEUTLY CUT TO LINE PRIOR TO TRENCH EXCAVATION.
3. NO SETTING OR PAVING SHALL BE PERMITTED.

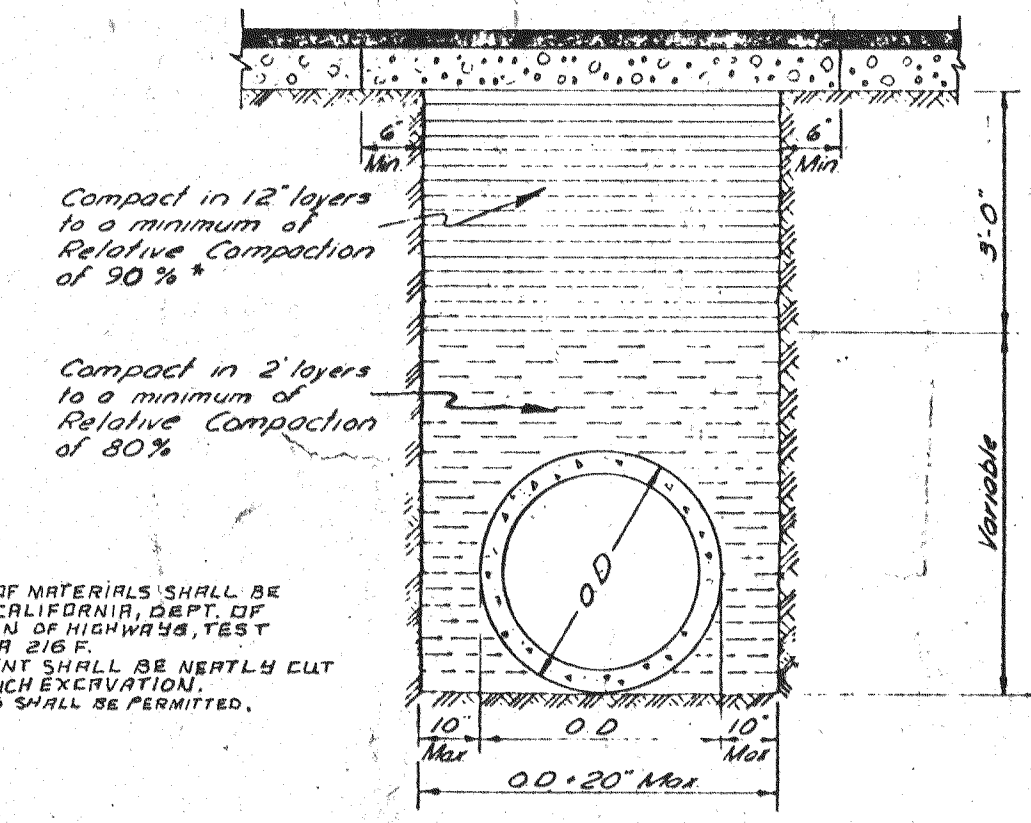

TYPICAL TRENCH BACKFILL DETAIL
STORM DRAIN AND WATER

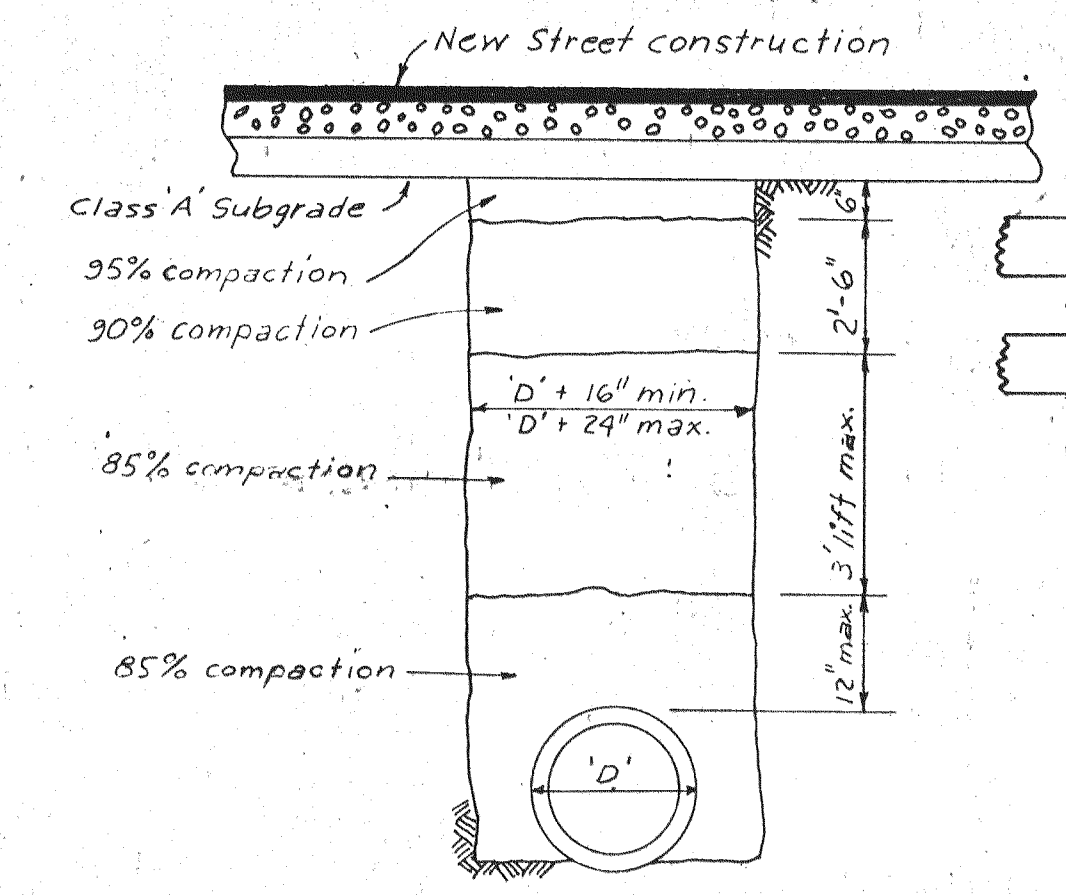


TYPICAL SECTION in New Street Construction and Unimproved Street right-of-way or Easements.

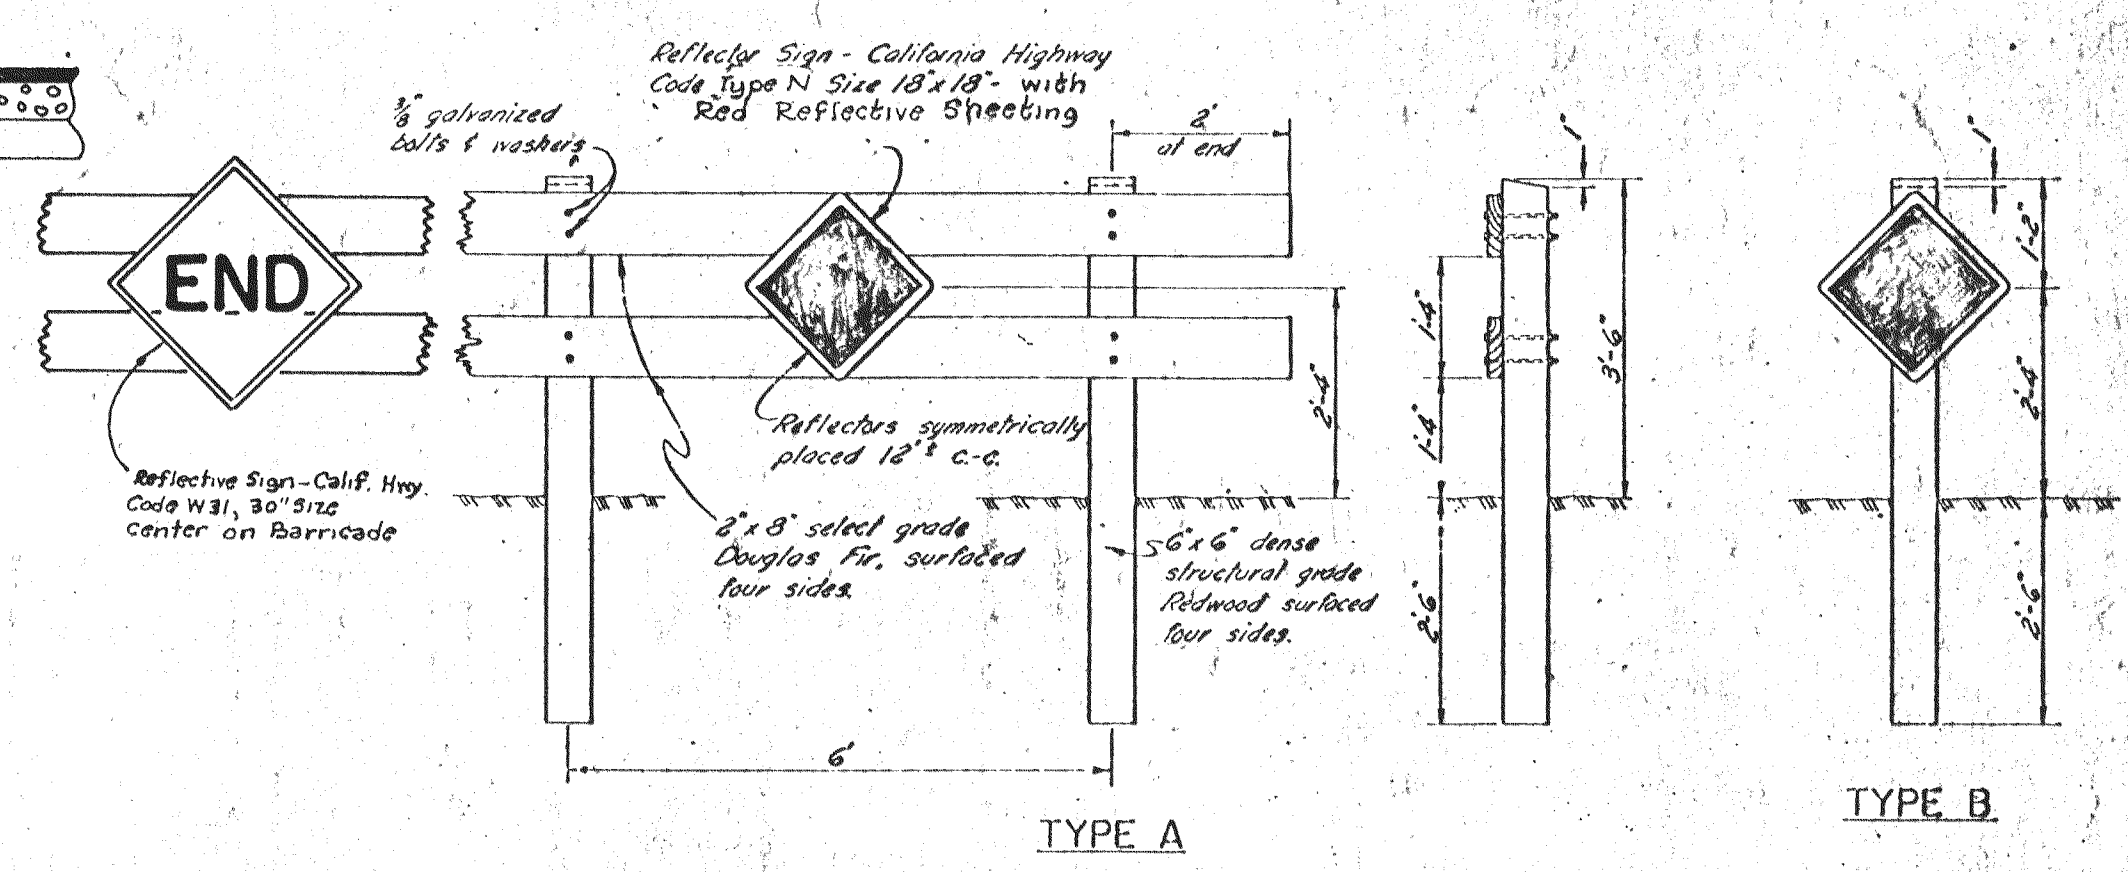


Notes:
Barricades to be as wide as street.
Barricades to be painted white using 2 coats of Exterior Alkyd Resin 10-Gloss Enamel over a compatible primer.

BARRICADES FOR TERMINATING STREETS

NOTE: All Radii 1/4" Unless Otherwise Noted.

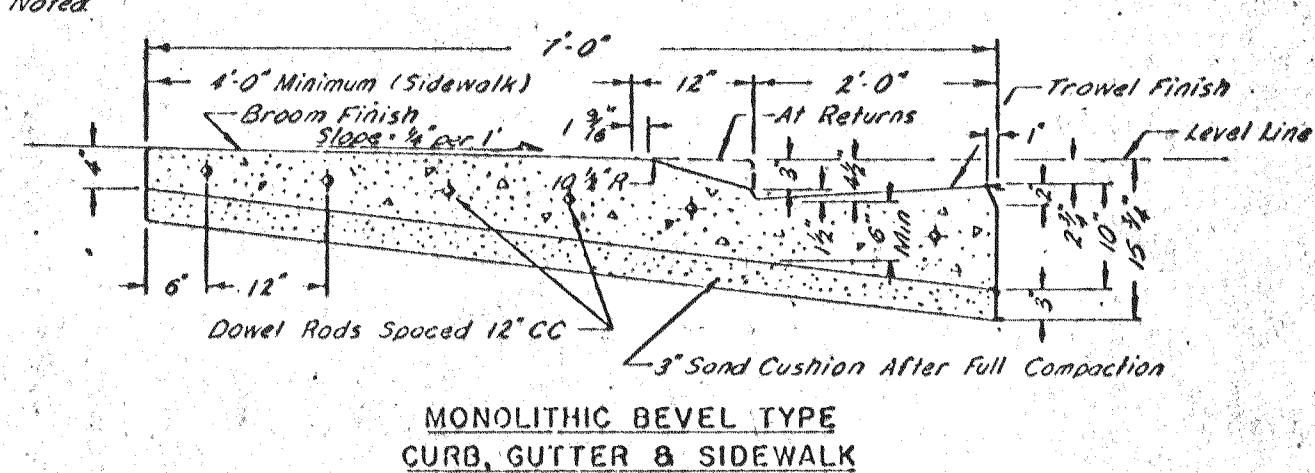


CURB, GUTTER & SIDEWALK
SUBDIVISION STREETS

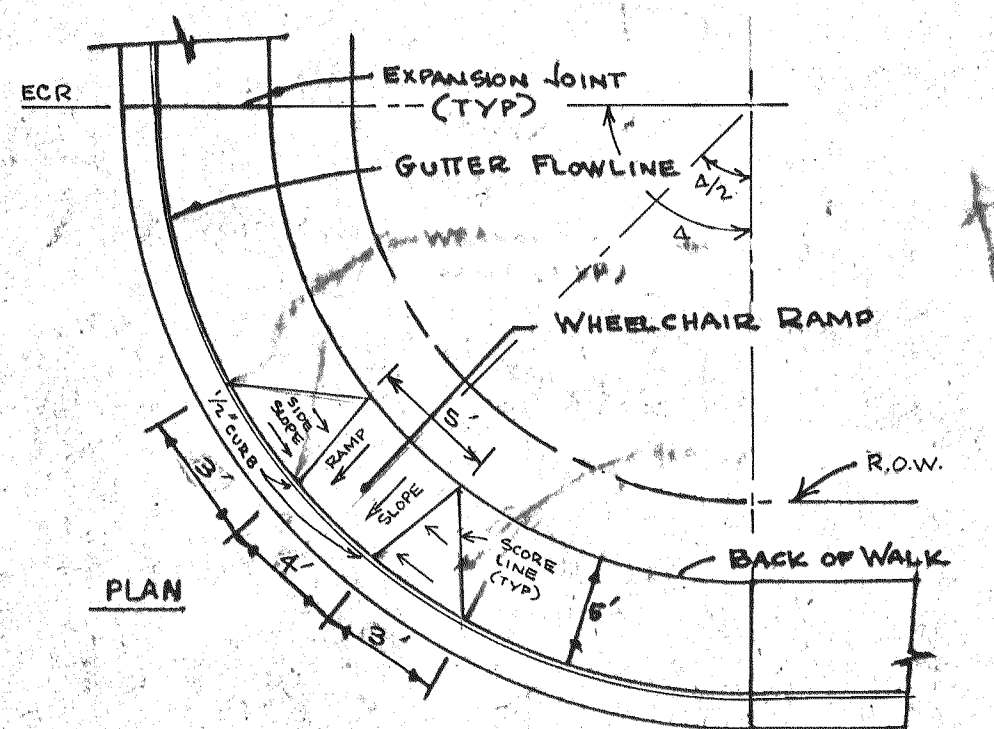


WHEEL CHAIR RAMP


THE RAMP SHALL BE CONSTRUCTED WITH A HEAVY BROOM FINISH TRANSVERSE TO THE AXIS OF THE RAMP IN ORDER TO INDICATE A CHANGE OF TEXTURE FOR BLIND PERSONS AND TO MAKE THEM AS NON-SLIP AS POSSIBLE.

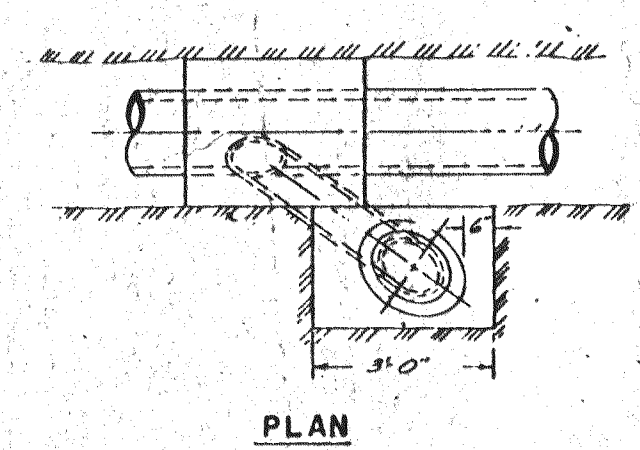



TYPICAL LAMPHOLE INSTALLATION

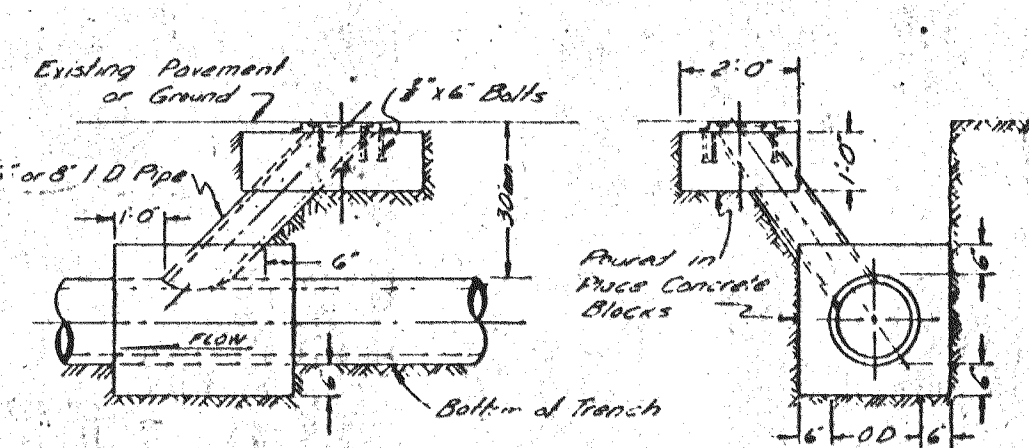


TYPICAL SANITARY SEWER DETAILS

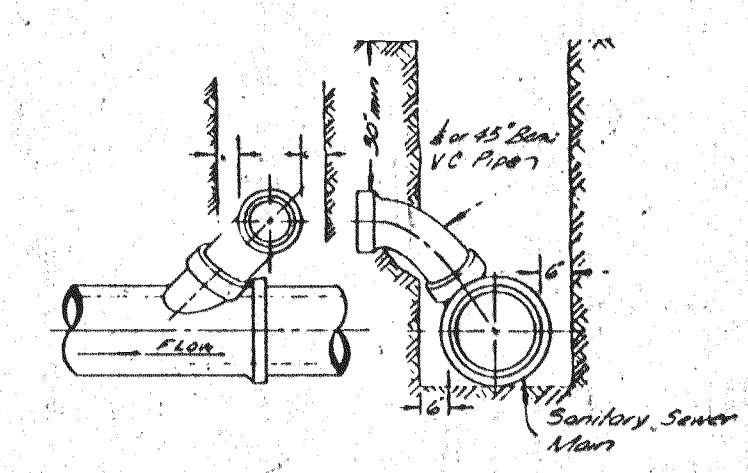


TYPICAL "Y" JOINT
SERVICE CONNECTION

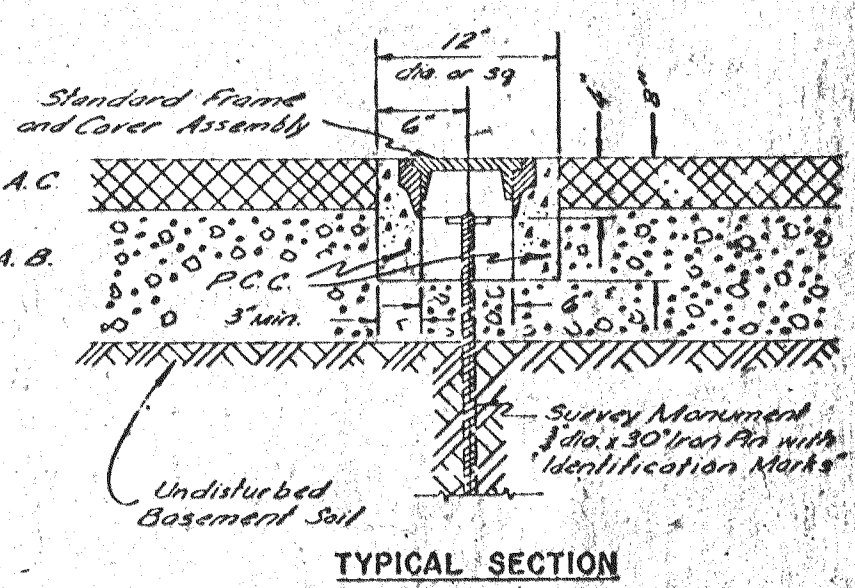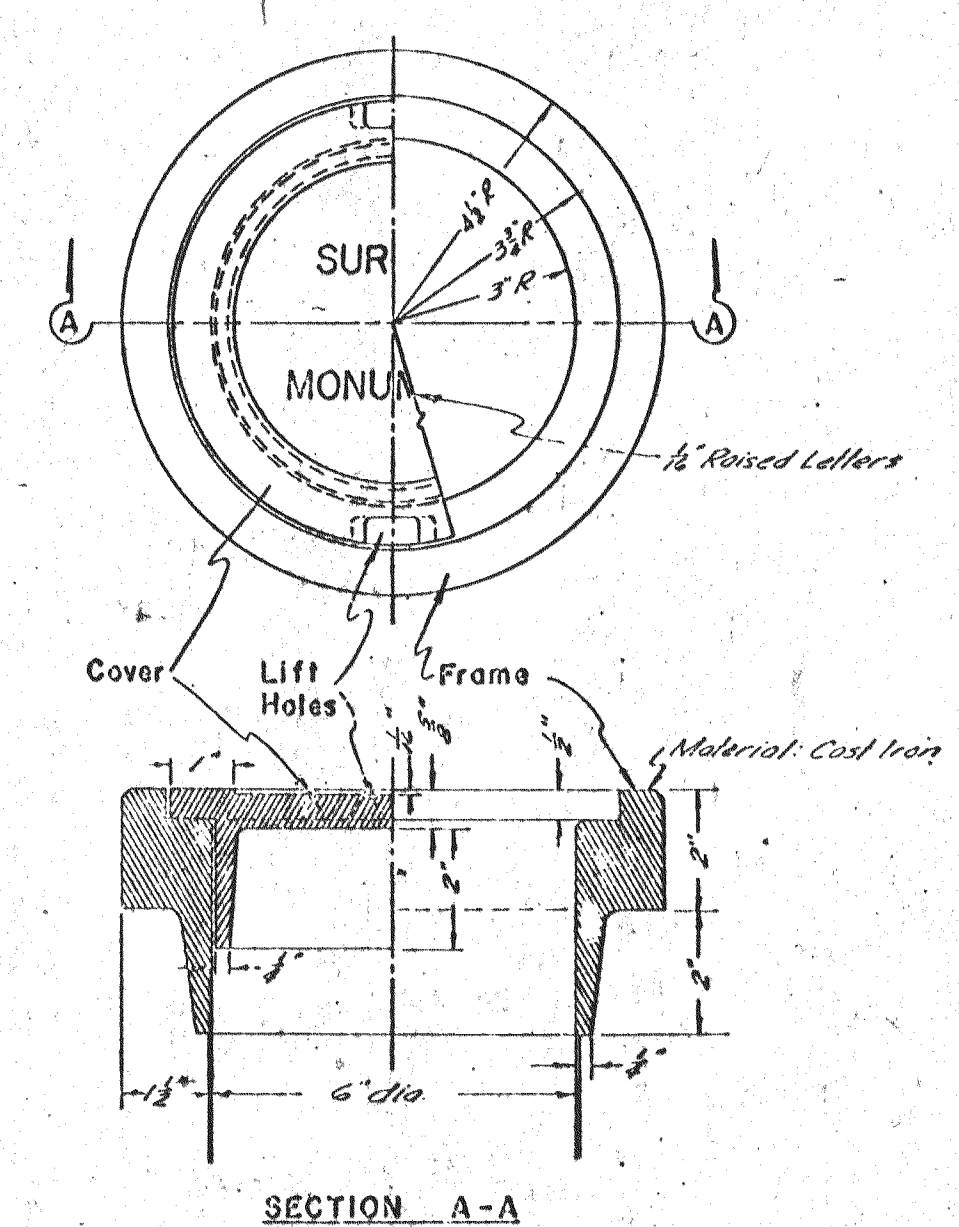


SURVEY MONUMENT
FRAME AND COVER ASSEMBLY

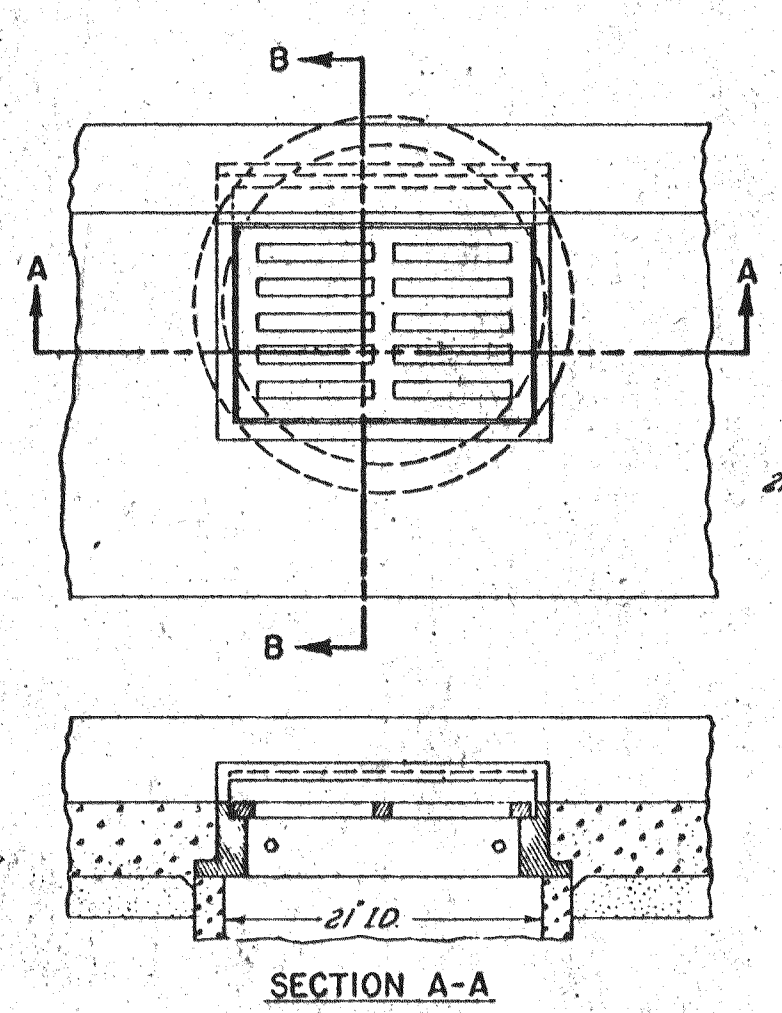


STANDARD STORM DRAIN INLET

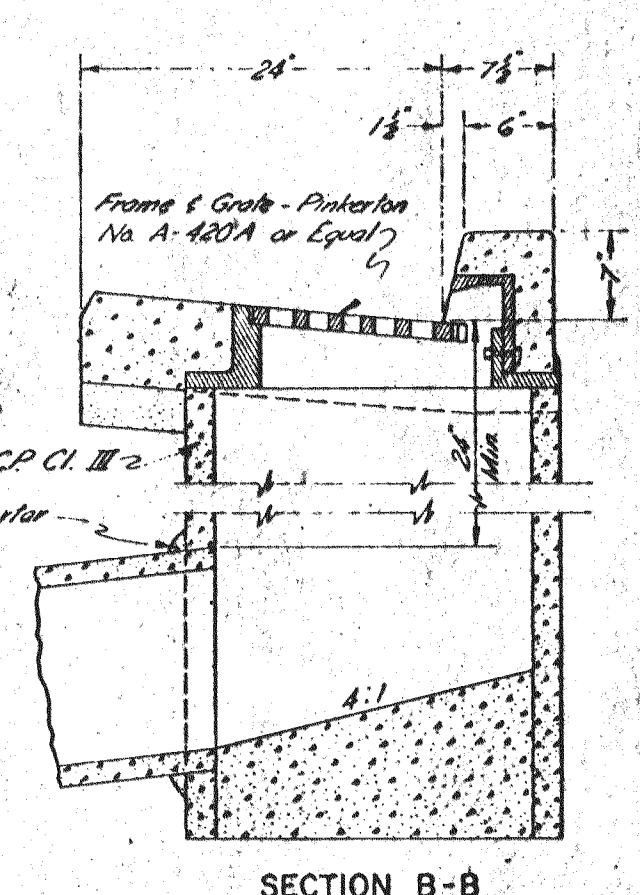


SECTION B-B

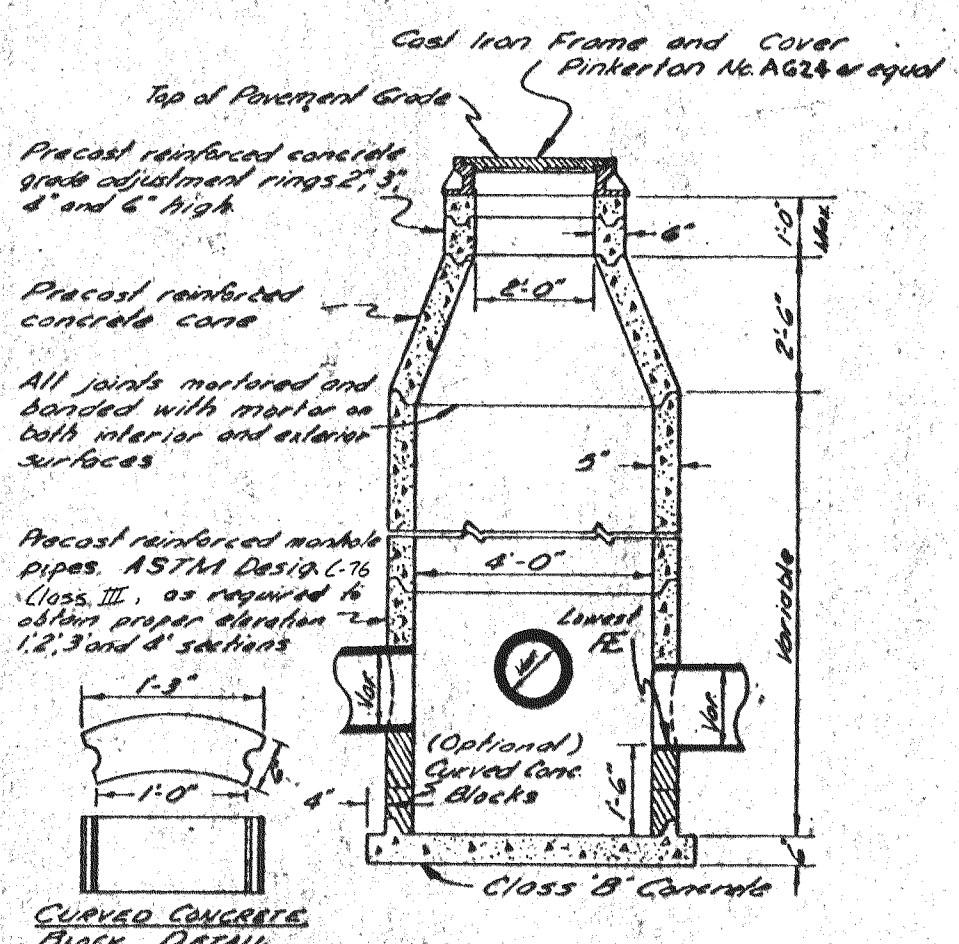


TYPICAL STORM SEWER MANHOLE

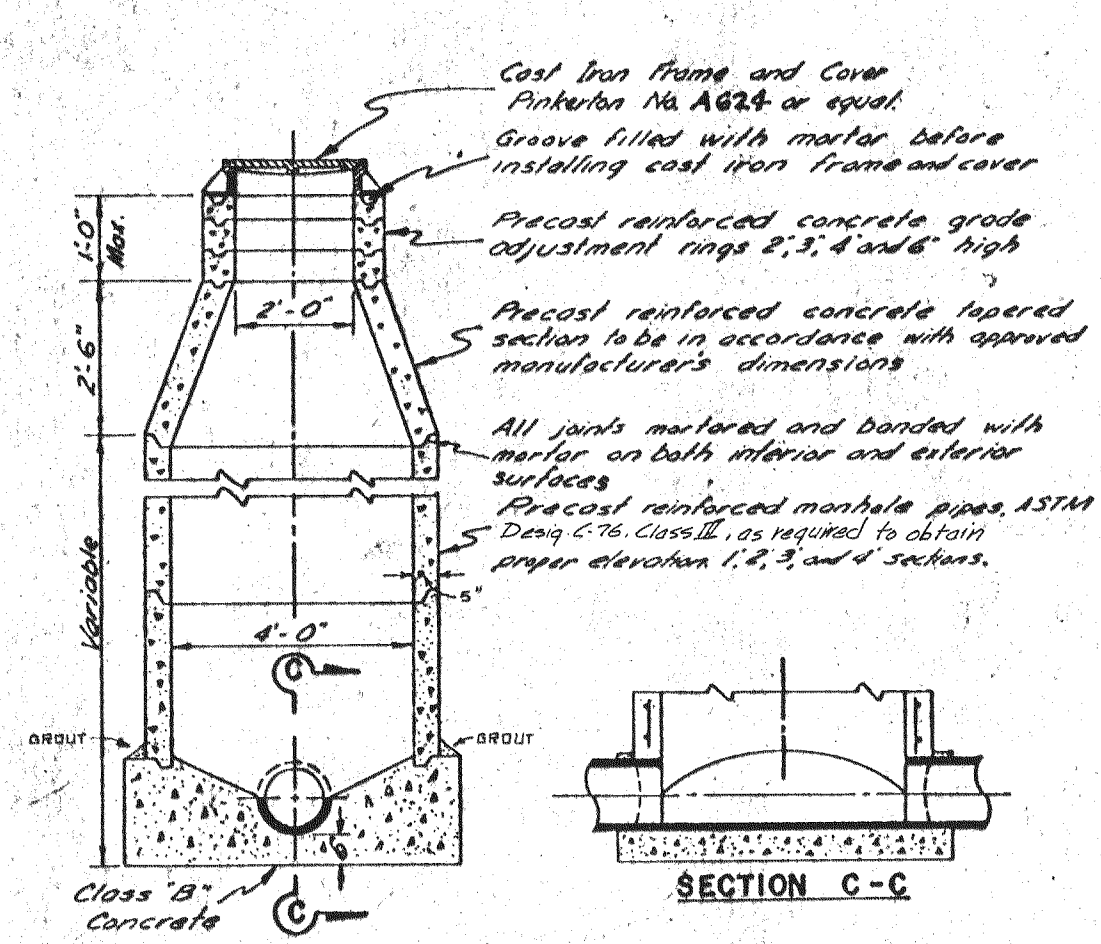

TYPICAL SANITARY SEWER MANHOLE

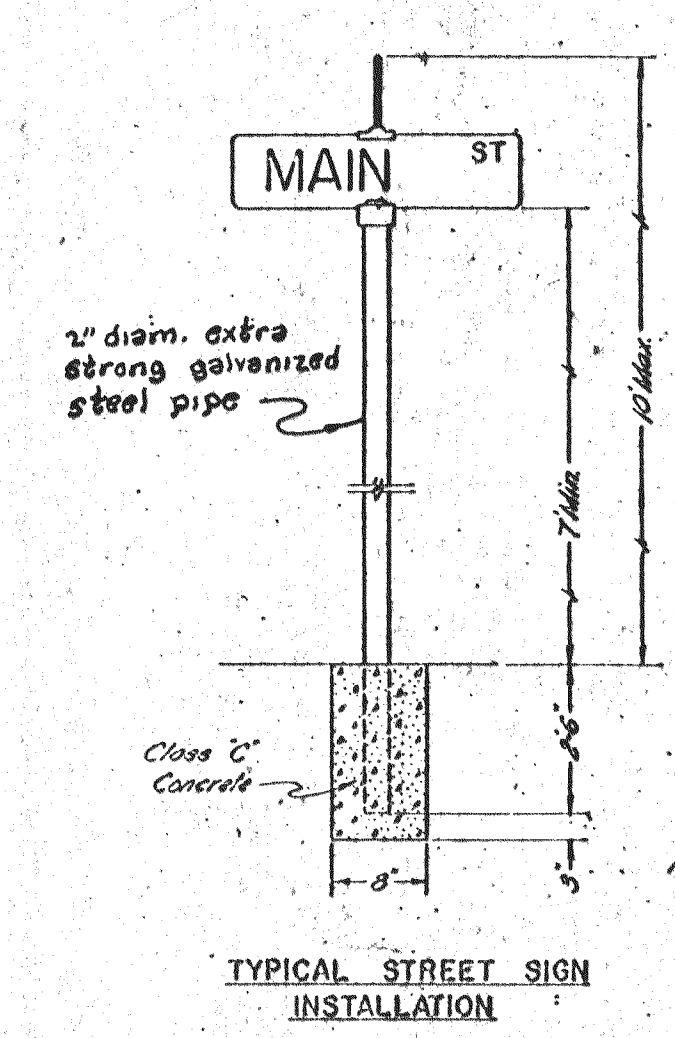

TYPICAL STREET SIGN
INSTALLATION

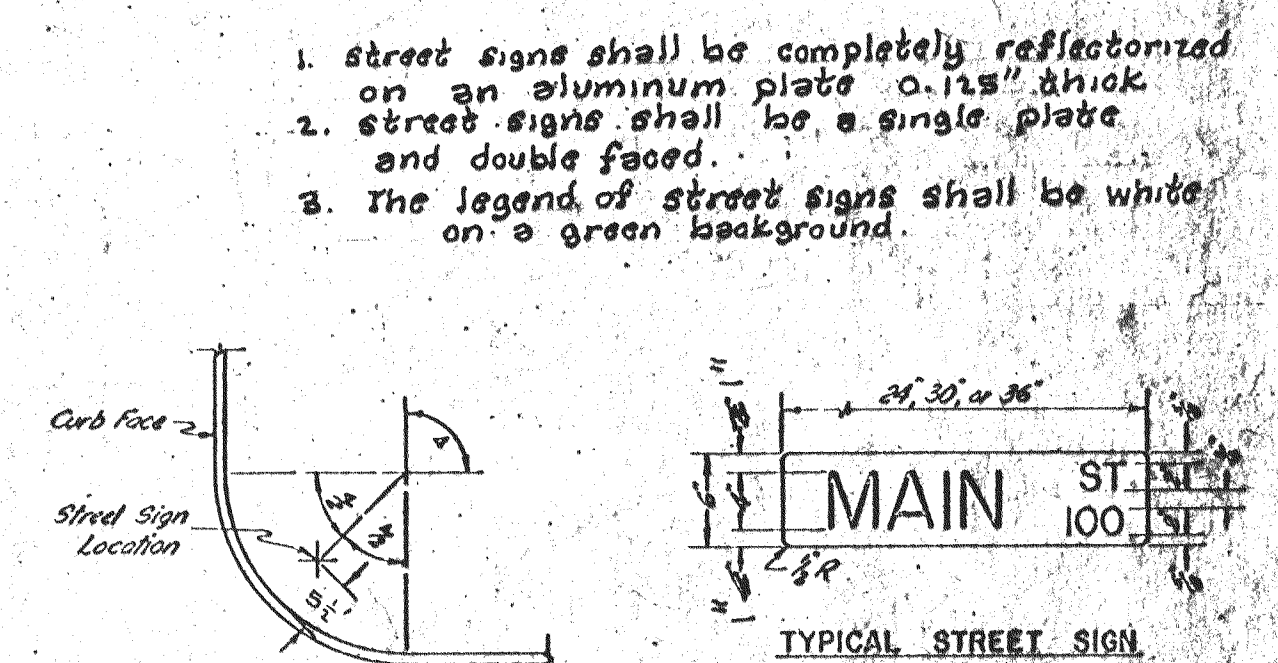

STANDARD STREET SIGN DETAILS

1. Street signs shall be completely reflectorized on an aluminum plate 0.125" thick
2. Street signs shall be a single plate and double faced.
3. The legend of street signs shall be white on a green background.

STREET SIGN POST
LOCATION DETAIL

Note:
One street sign is required at each intersection.

FILE NAME: SUBD
DRAWER: SU
SHEET NO: 1315

APPROVED 6-16-79 1979
CITY ENGINEER STOCKTON CALIFORNIA

APPROVED 2-21-79 1979
SAN JOAQUIN COUNTY DIRECTOR OF PUBLIC WORKS

no.	description	date	by

WONG ENGINEERS
PLANNING • ENGINEERING • SURVEYING
STOCKTON, CALIFORNIA

R.C.E. No. 14269

job no. 1637
date APR 1978
scale nts
drawn by
design by
check by

TALLAHATCHY TERRACE UNIT NO. 2
DETAIL SHEET


SHR
OF TR
FILE

FILE NAME
DRAWER
SHEET NO.
566d
51
1316

APPROVED 6-16-78 19 78
Handwritten Signature
CITY ENGINEER, STOCKTON CALIFORNIA

APPROVED 2-21 19 79
Handwritten Signature
SAN JOAQUIN COUNTY DIRECTOR OF PUBLIC WORKS

revisions			
no.	description	date	by

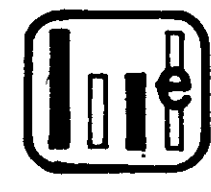


WONG ENGINEERS
PLANNING · ENGINEERING · SURVEYING
STOCKTON, CALIFORNIA
Handwritten Signature
R.C.E. No. 14269


job no. 1637
date APR 1978
scale AS SHOWN
drawn *lp*
design WE
check ZAK

TALLAHATCHY TERRACE UNIT NO. 2
PROFILE SHEET

SHEET
3
OF FOUR
FILE

SCALE: HORZ. : 1" = 40'
VERT. : 1" = 4'

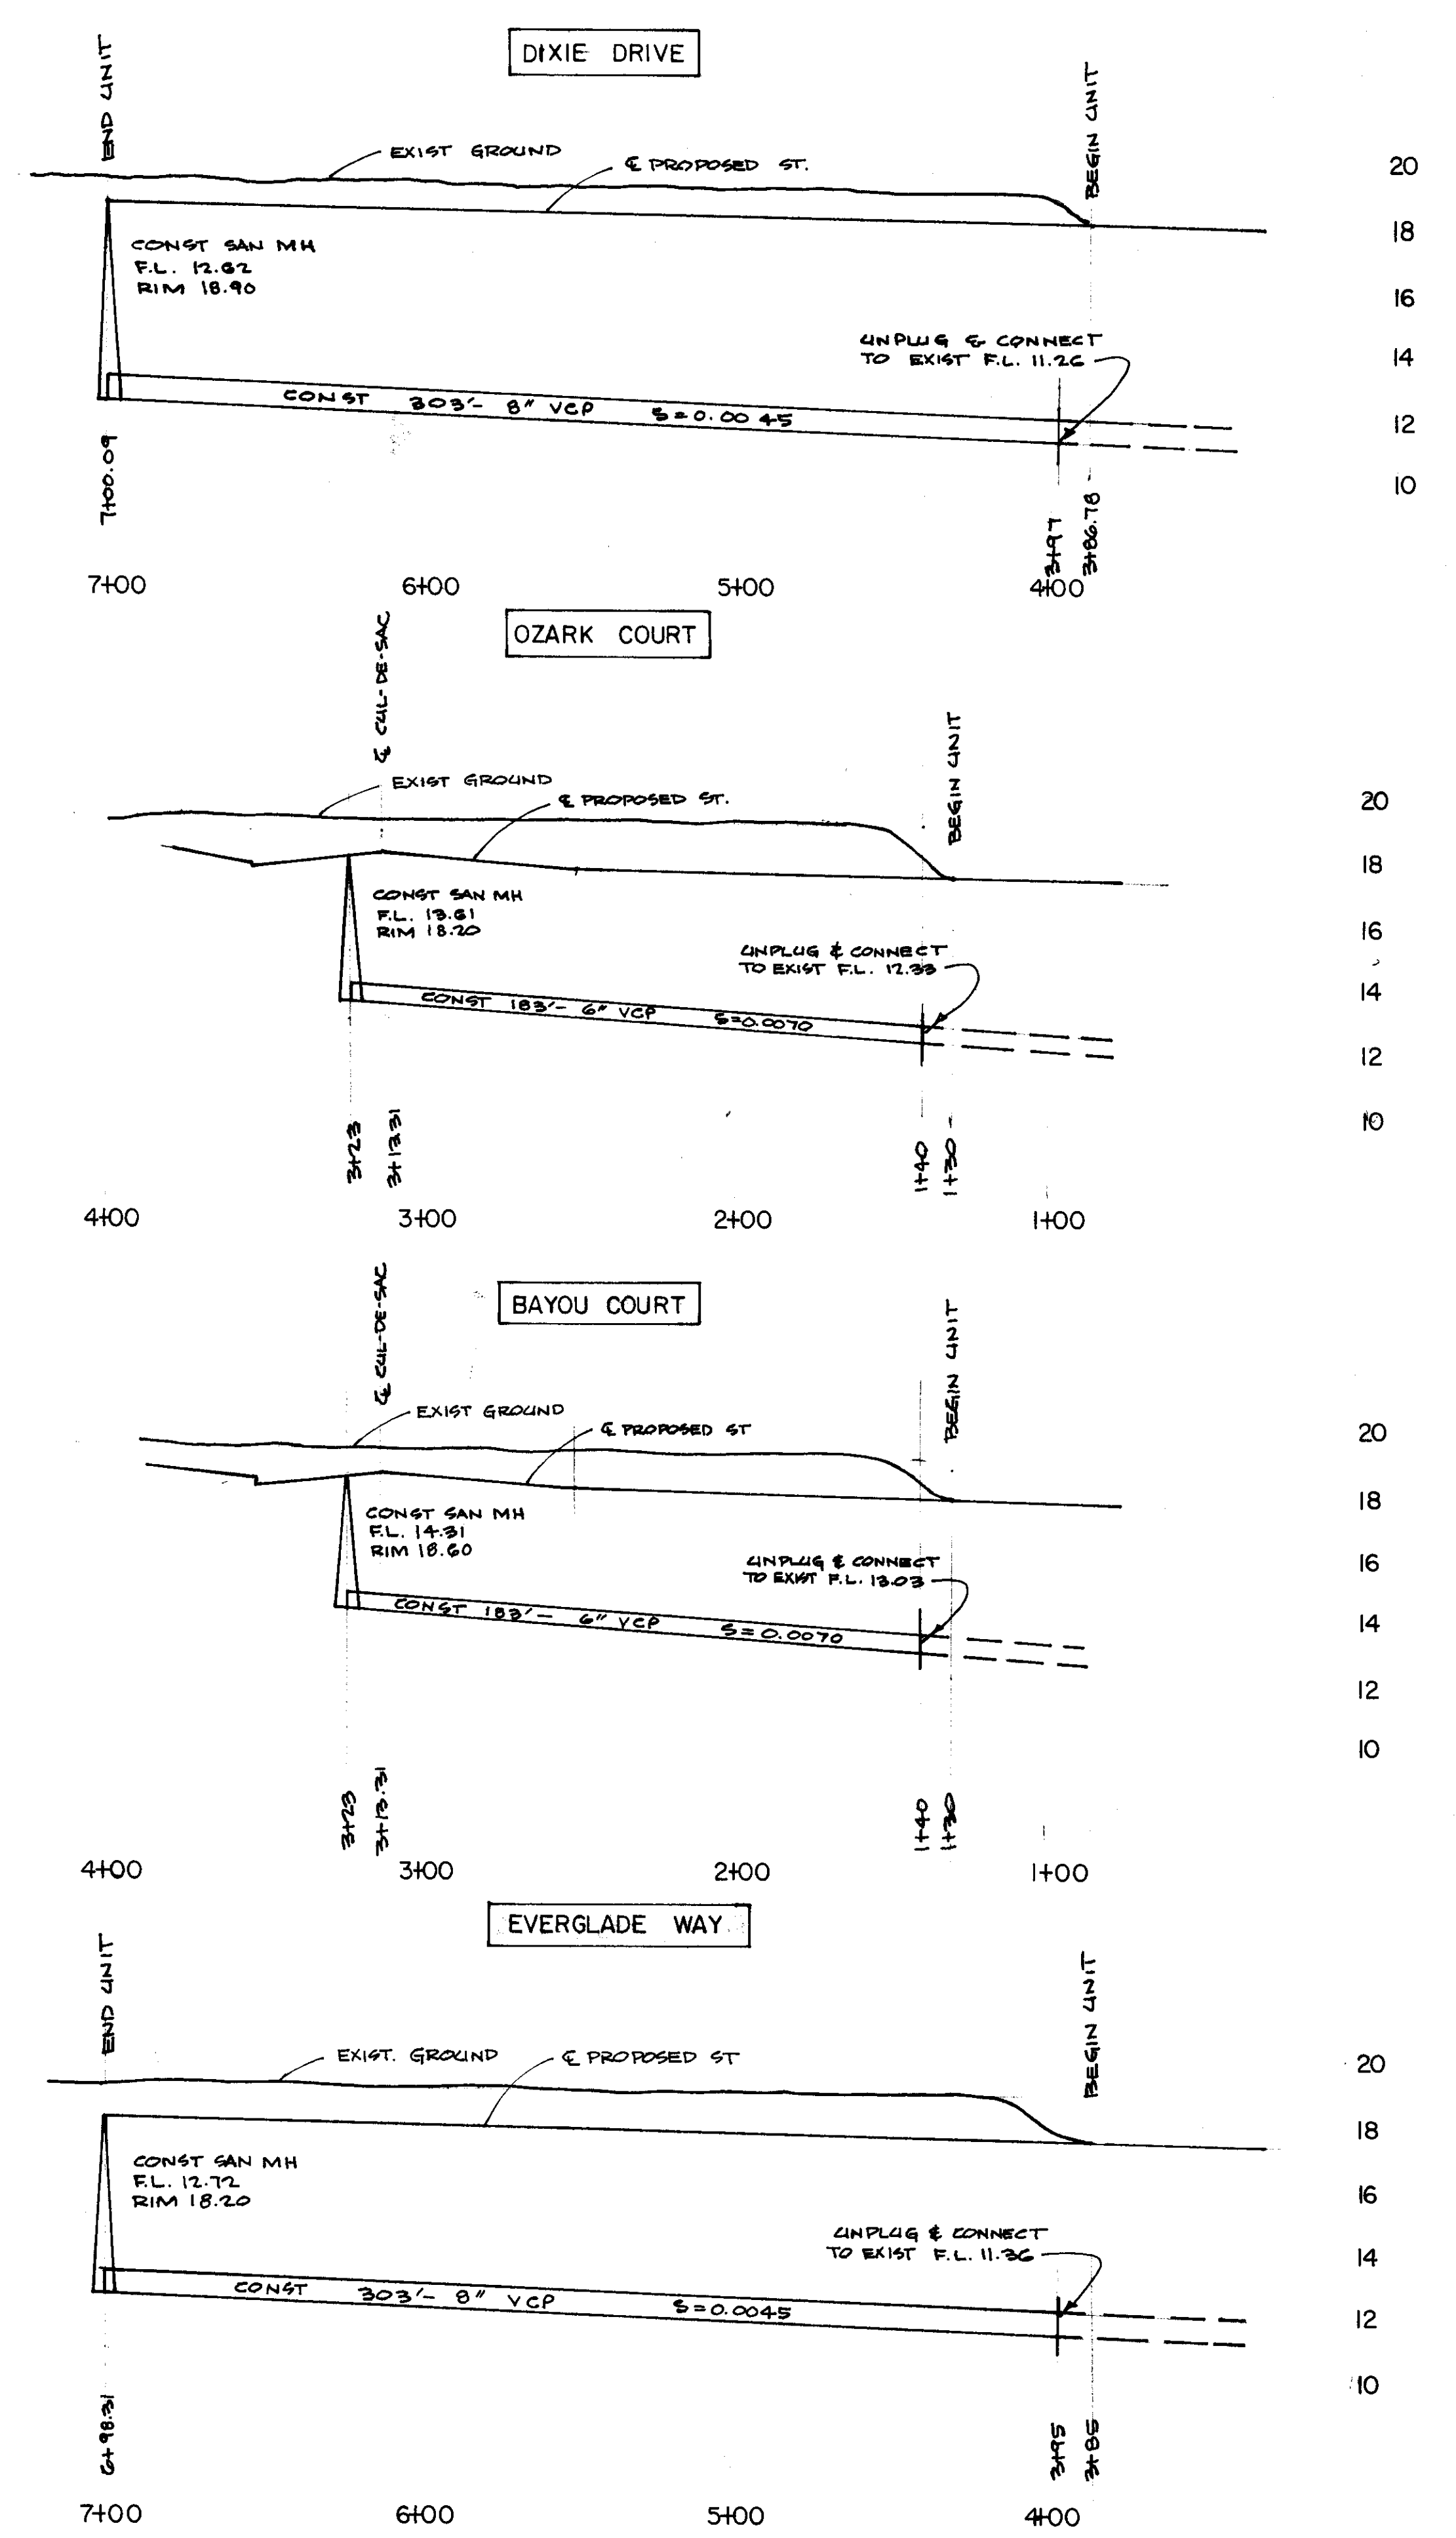

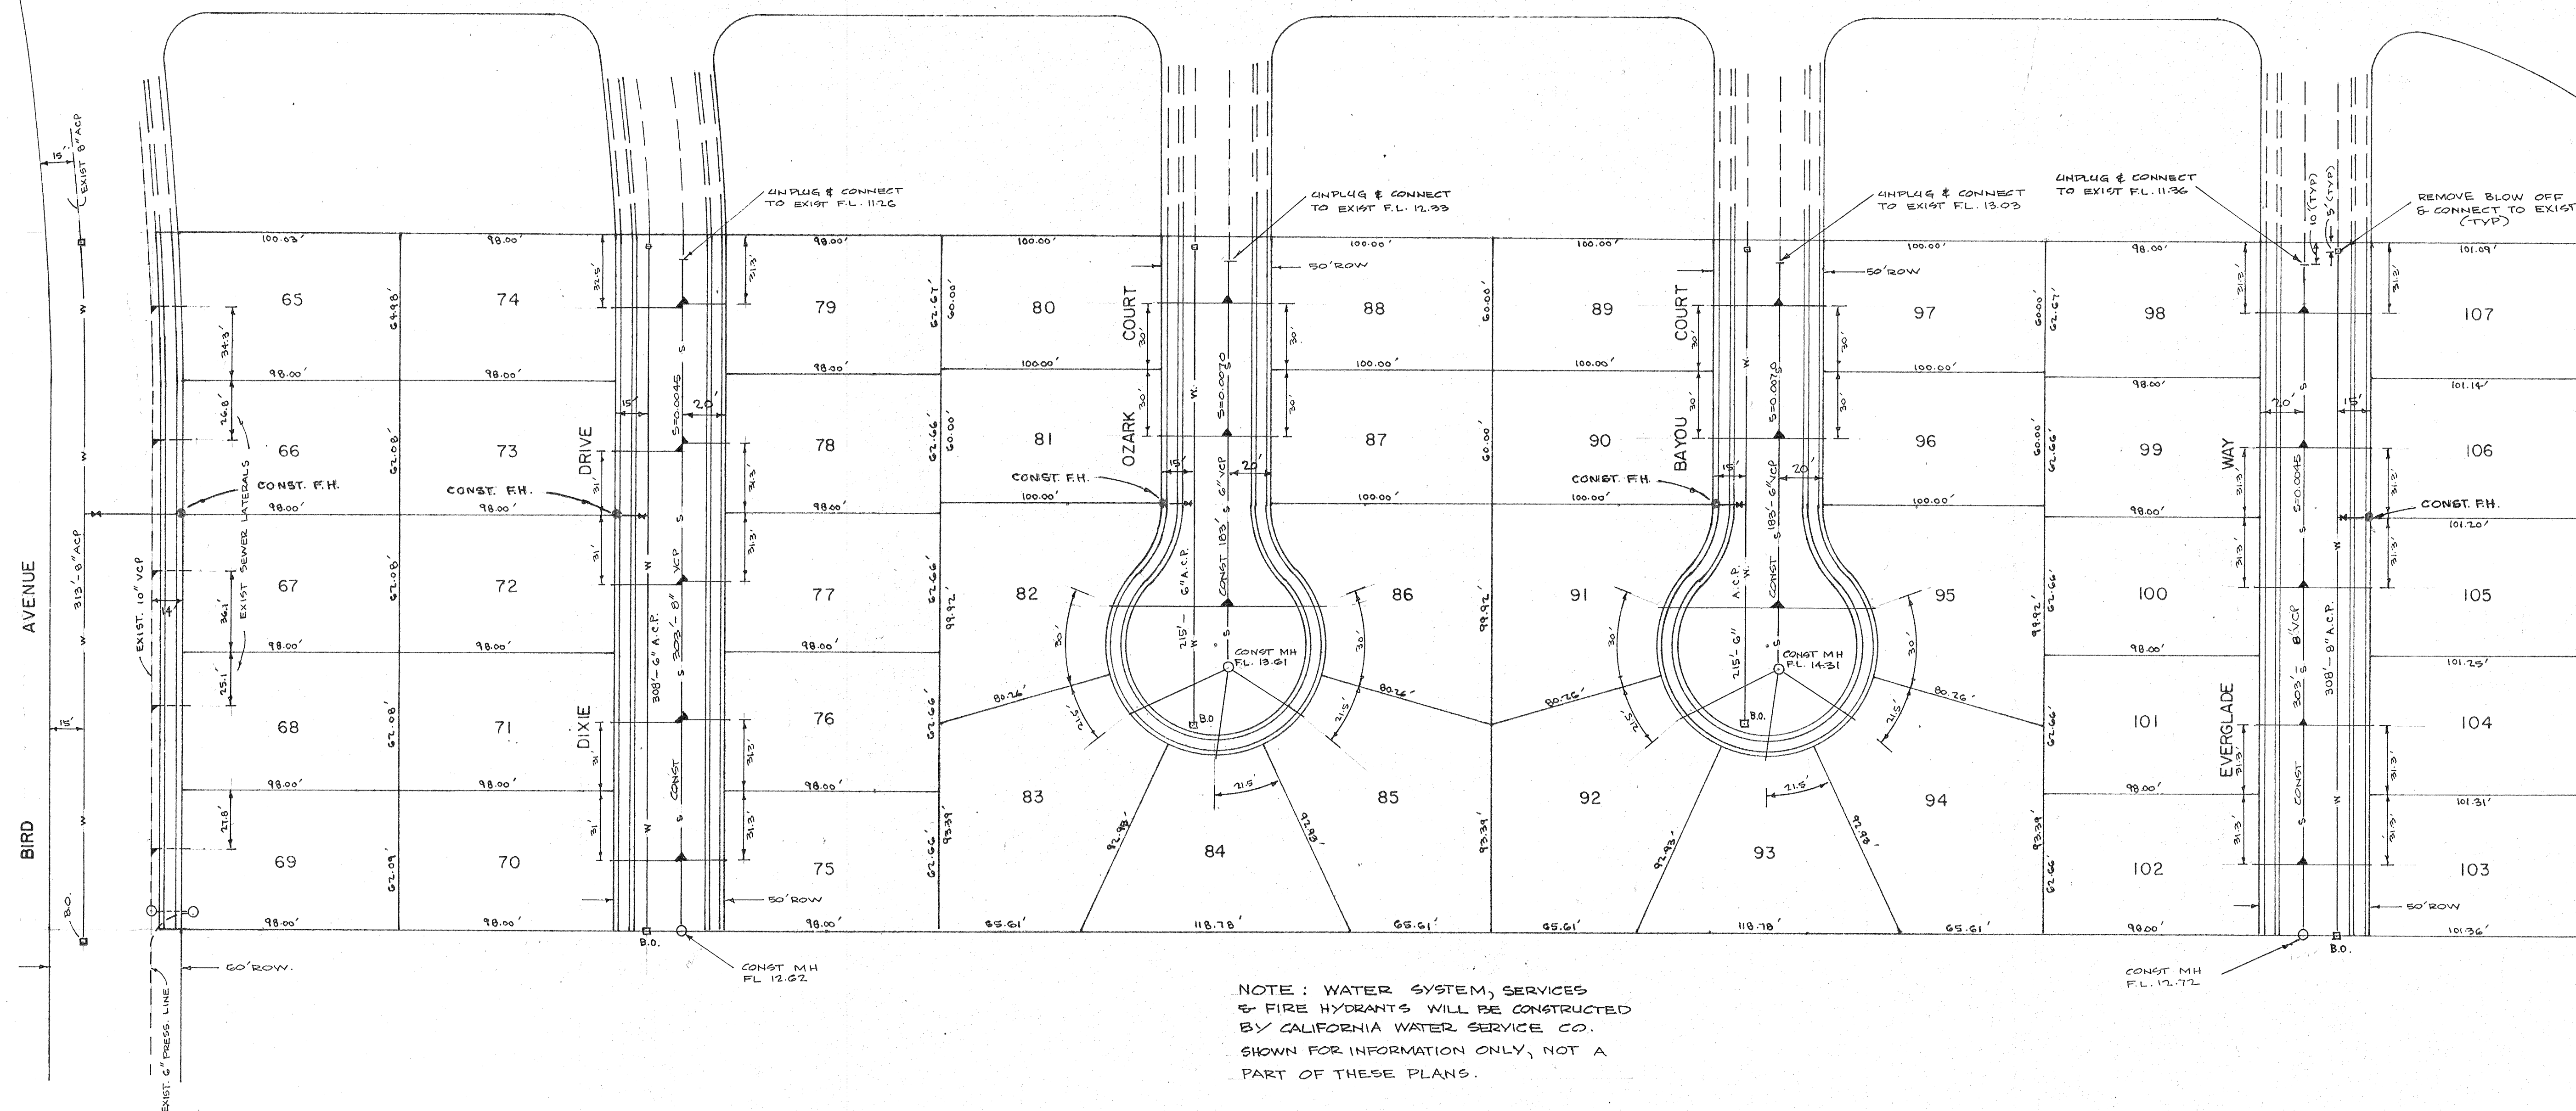

NOTE: WATER SYSTEM, SERVICES
& FIRE HYDRANTS WILL BE CONSTRUCTED
BY CALIFORNIA WATER SERVICE CO.
SHOWN FOR INFORMATION ONLY, NOT A
PART OF THESE PLANS.

LEGEND

F.H.	FIRE HYDRANT
M.H.	MAN HOLE
A.C.P.	ASBESTOS CEMENT PIPE - CLASS 150
V.C.P.	VITRIFIED CLAY PIPE - EXTRA STRENGTH VCP - ASTM C-700
○	PRECAST CONCRETE MAN HOLE
—	SEWER LATERAL

APPROVED FEB. 20 1979 APPROVED Feb. 20 1979

James V. White
EASTSIDE FIRE CHIEF

Steve Thienes
SAN JOAQUIN COUNTY FIRE WARDEN

APPROVED 6-16-78 19

APPROVED 2-21 1979

Thomas D. ...
CITY ENGINEER, STOCKTON CALIFORNIA

William J. ...
SAN JOAQUIN COUNTY DIRECTOR OF PUBLIC WORKS

revisions			
no.	description	date	by



WONG ENGINEERS
PLANNING • ENGINEERING • SURVEYING
STOCKTON, CALIFORNIA

R.C.E. No. 14269

job no. 1637
date APR 1978
scale 1" = 40'
drawn *lp*
design *WE*
check *ZK*

TALLAHATCHY TERRACE UNIT NO. 2

UNDERGROUND IMPROVEMENT PLANS

SHEET
2
OF FOUR
FILE


BENCH MARK - Ship Spike
in power pole ELEV. 21.27

APPROVED _____ 19__

APPROVED 2-21 1979

William J. Ward
SAN JOAQUIN COUNTY DIRECTOR OF PUBLIC WORKS

revisions			
no.	description	date	by

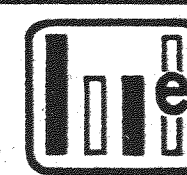

WONG ENGINEERS
PLANNING • ENGINEERING • SURVEYING
STOCKTON, CALIFORNIA

R.C.E. No. 14269

job no. 1637
date APR 1978
scale 1" = 40'
drawn *td*
design WE
check *AK*

TALLAHATCHY TERRACE UNIT NO. 2

STREET WORK AND GRADING PLAN

SHEET
1
OF FOUR
FILE

