
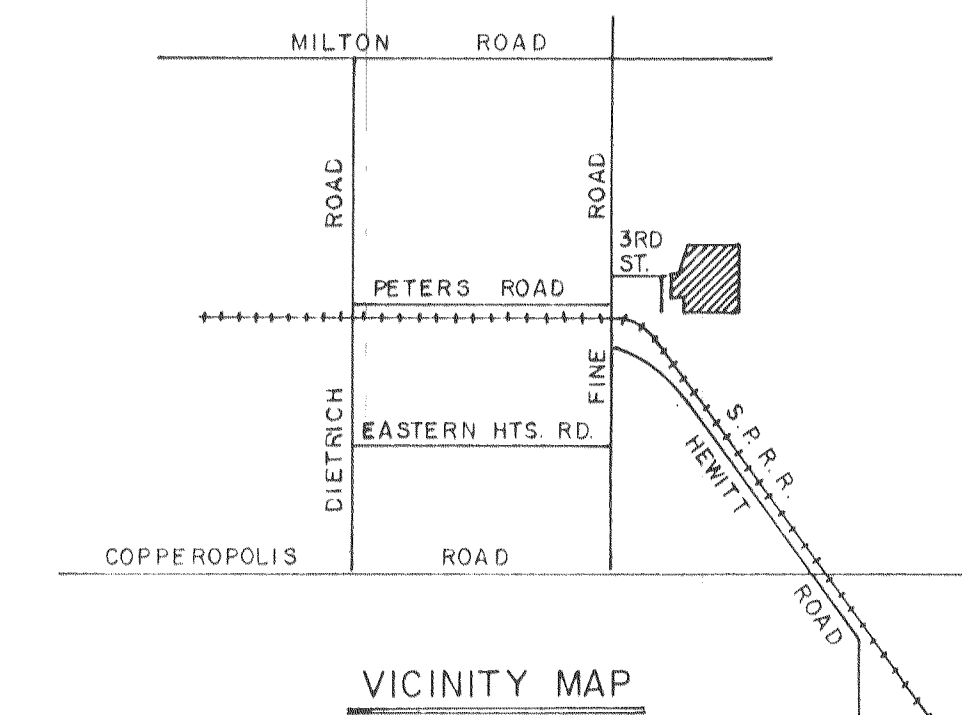


SUB'D
NAME
DRAWER
SHEET NO.
1567

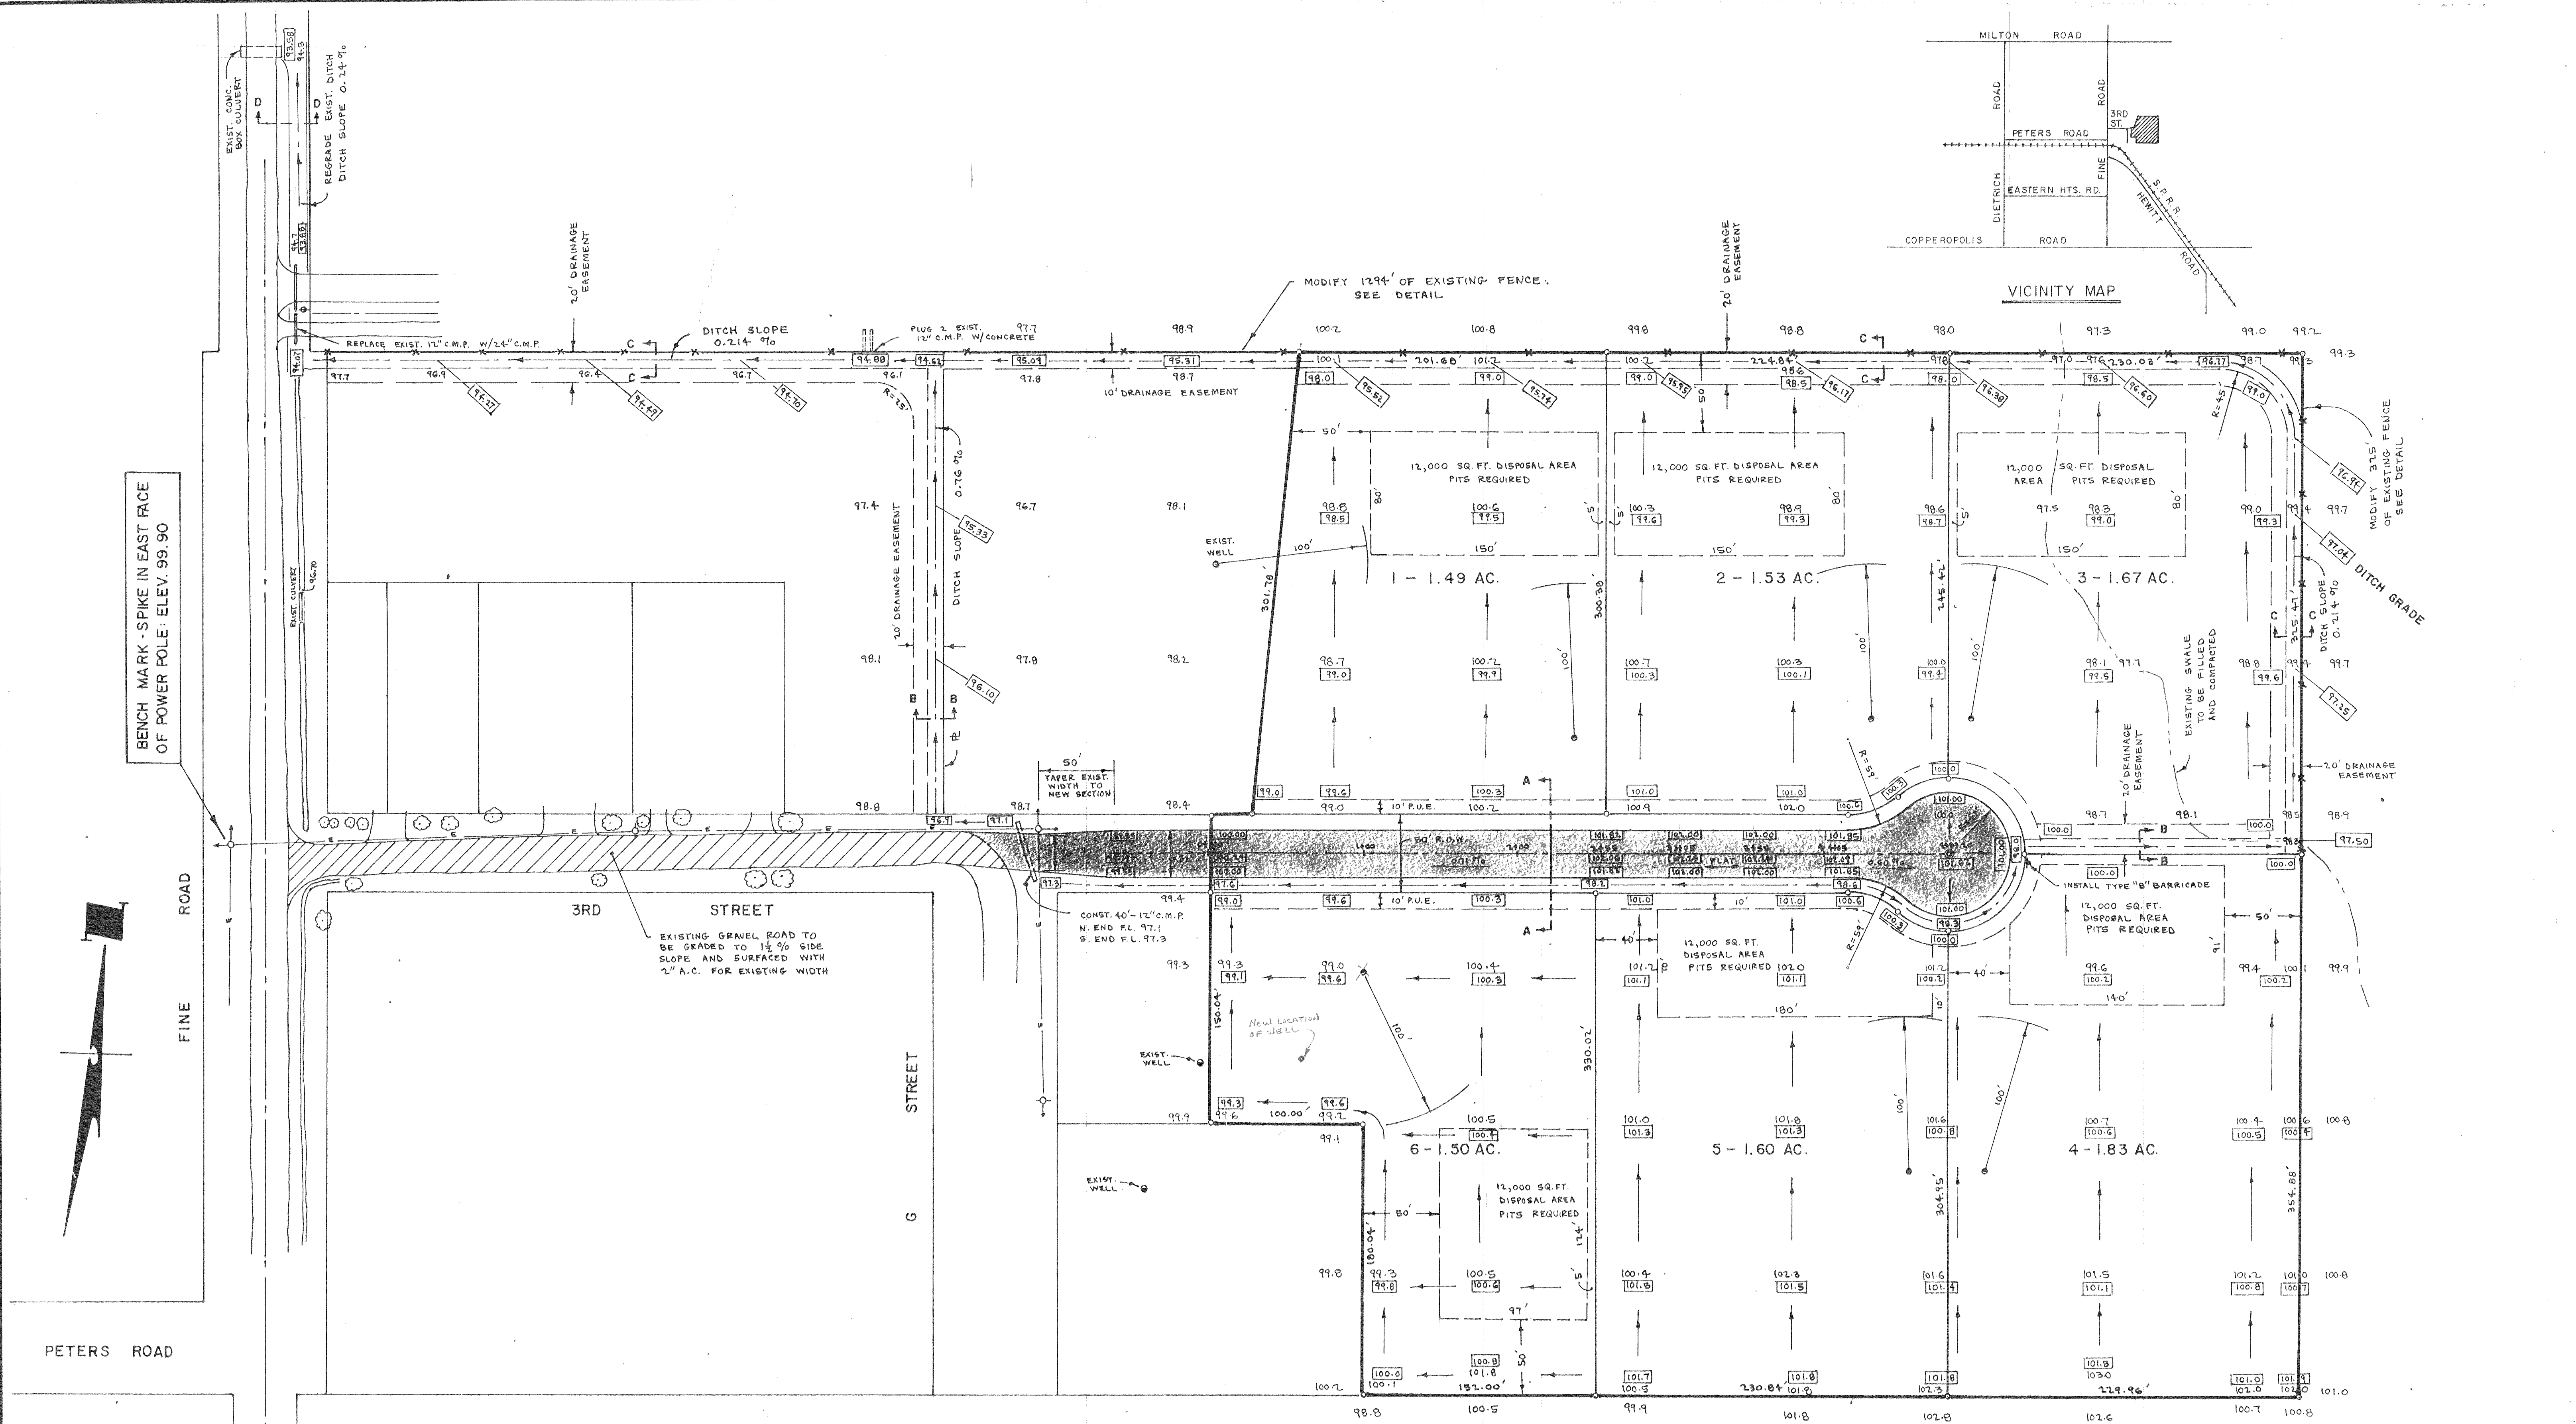

NOTE: STORM DRAINAGE DITCHES SHOWN ON THESE PLANS SHALL BE MAINTAINED BY INDIVIDUAL PROPERTY OWNERS.

- 100.0 DENOTES FINISHED GRADE
100.0 DENOTES EXISTING ELEVATIONS
● PROPOSED WELL
◎ CENTER LINE MONUMENT

SERVICES
WATER - PRIVATE WELL
SANITARY - SEPTIC TANKS
STORM - TERMINAL DRAIN

APPROVED 4-20 1983
James Miller
SAN JOAQUIN LOCAL HEALTH DISTRICT

APPROVED JUNE 10 1983
Henry M. Diata
SAN JOAQUIN COUNTY DIRECTOR OF PUBLIC WORKS

no.	revisions	description	date	by

WONG ENGINEERS, INC.
PLANNING • ENGINEERING • SURVEYING
STOCKTON, CALIFORNIA
W. G. Wong
R.C.E. No. 14269

DATUM: U.S.G.S.
job no. 1798
date MARCH 1983
scale 1" = 50'
drawn P
design WE
check C.C.W.

IMPROVEMENT PLANS FOR NEW PETERSBURG
STREET, DITCH & GRADING PLAN

SHEET
1
OF TWO
FILE