
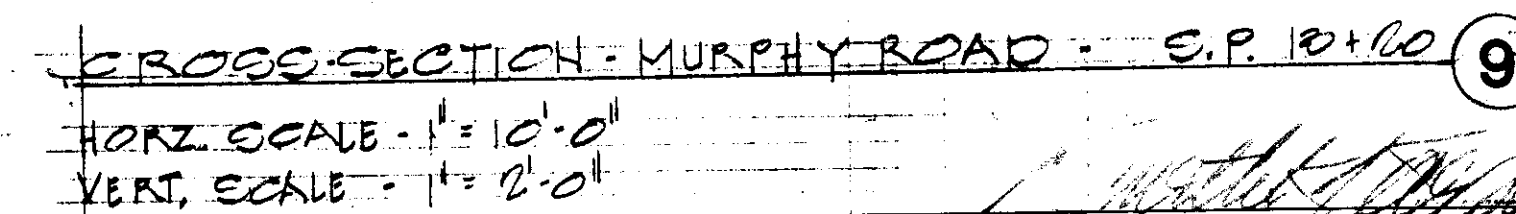
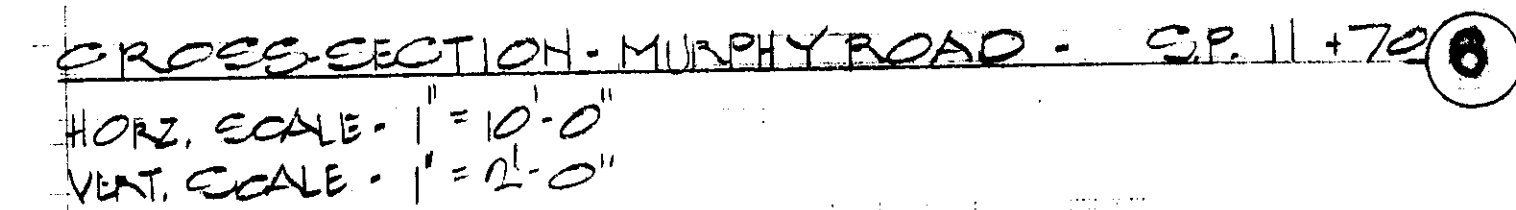
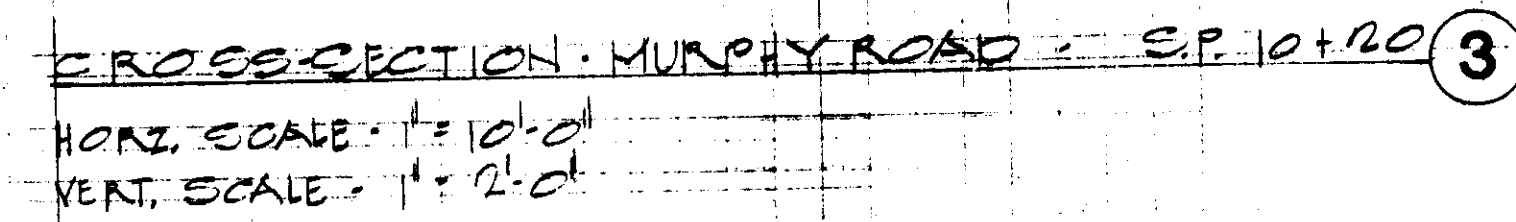
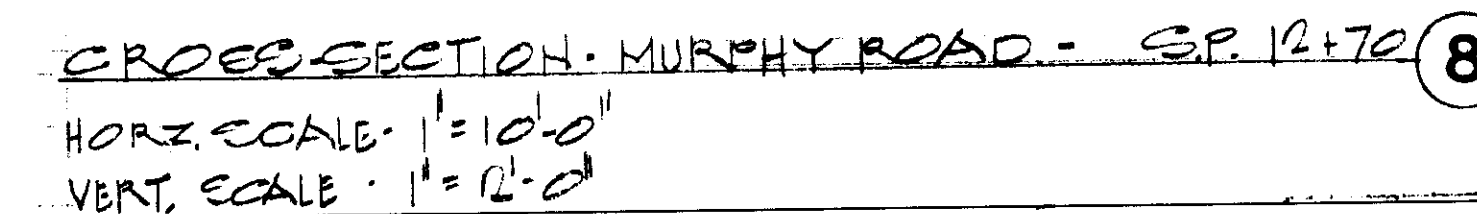
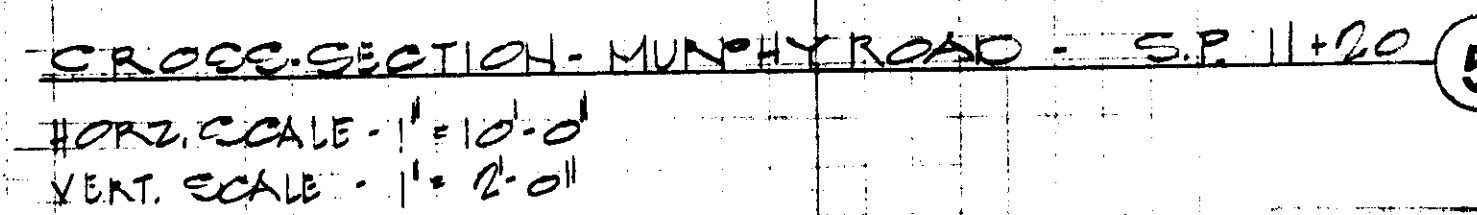
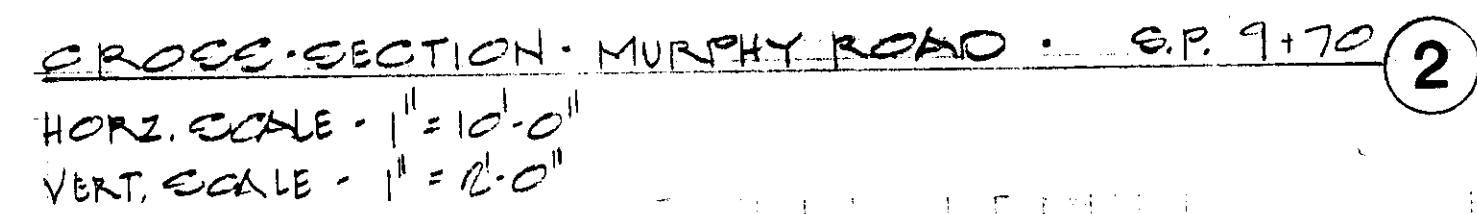
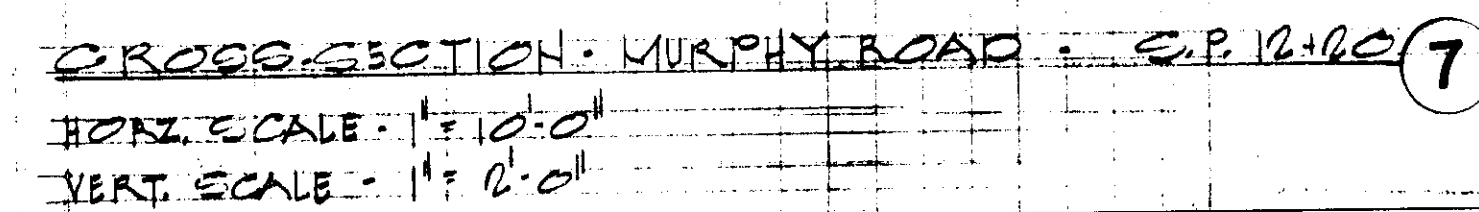
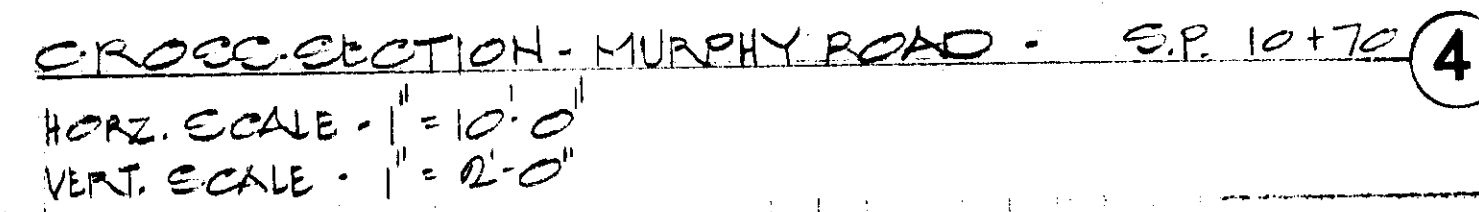


CUT NUMBER:

SU-2299

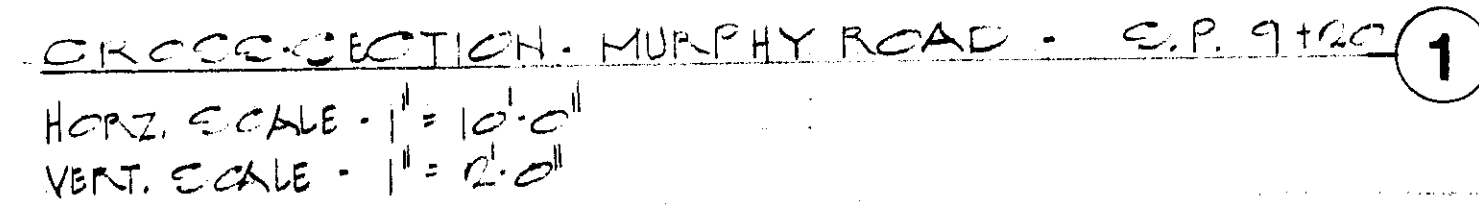

Reviewed by *[Signature]*

70
C
C
C
C

4. #
kchecked

7/6
C
C
C
C
C

50

OFFICE OF STATE FIRE MARSHAL
APPROVED

Approval of this plan does not authorize or approve any omission or deviation from applicable regulations. Final approval is subject to field inspection. One set of approved plans shall be available on the project site at all times.

Reviewed by Shu
11-29-89
Inc #1 3

70
C
C
C
C

4. #
kchecked

7/6
C
C
C
C
C

50


IDENTIFICATION STAMP
Department of General Services
Office of the State Architect
30
Structural Safety Section
Appl. # 52575
Backchecked By

REGISTERED PROFESSIONAL ENGINEER
KENNETH K. KAESTNER
NO.
CE 26565
EXP. 3/31/92
CIVIL
STATE OF CALIFORNIA


一

6


TITLE BLOCK LIB NAME: SW-TB-2442-OFF
MODULES/LAYERS REQ'D:
LIB FILE:
SHEET NUMBER:

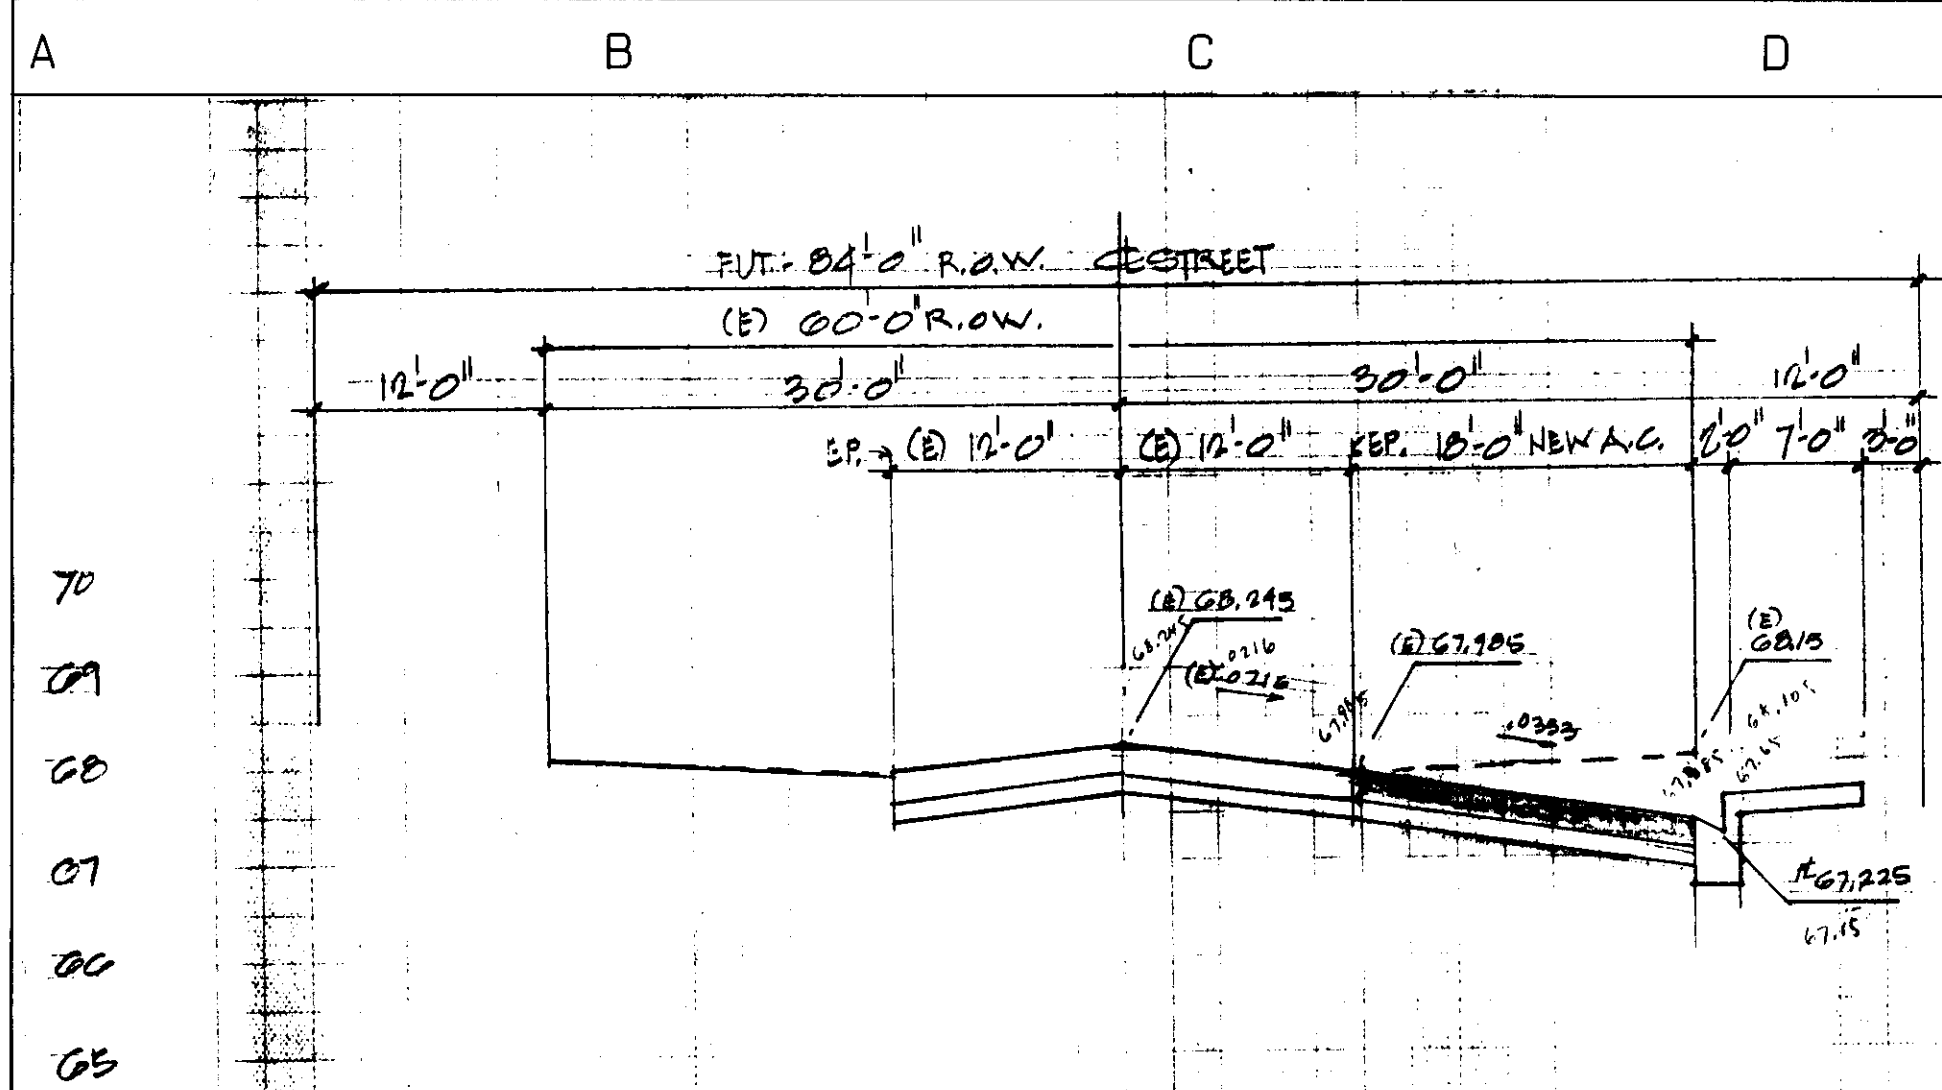

CROSS-SECTION - MURPHY ROAD - S.P. 4+70
HORIZ. SCALE - 1" = 10'-0"
VERT. SCALE - 1" = 2'-0"

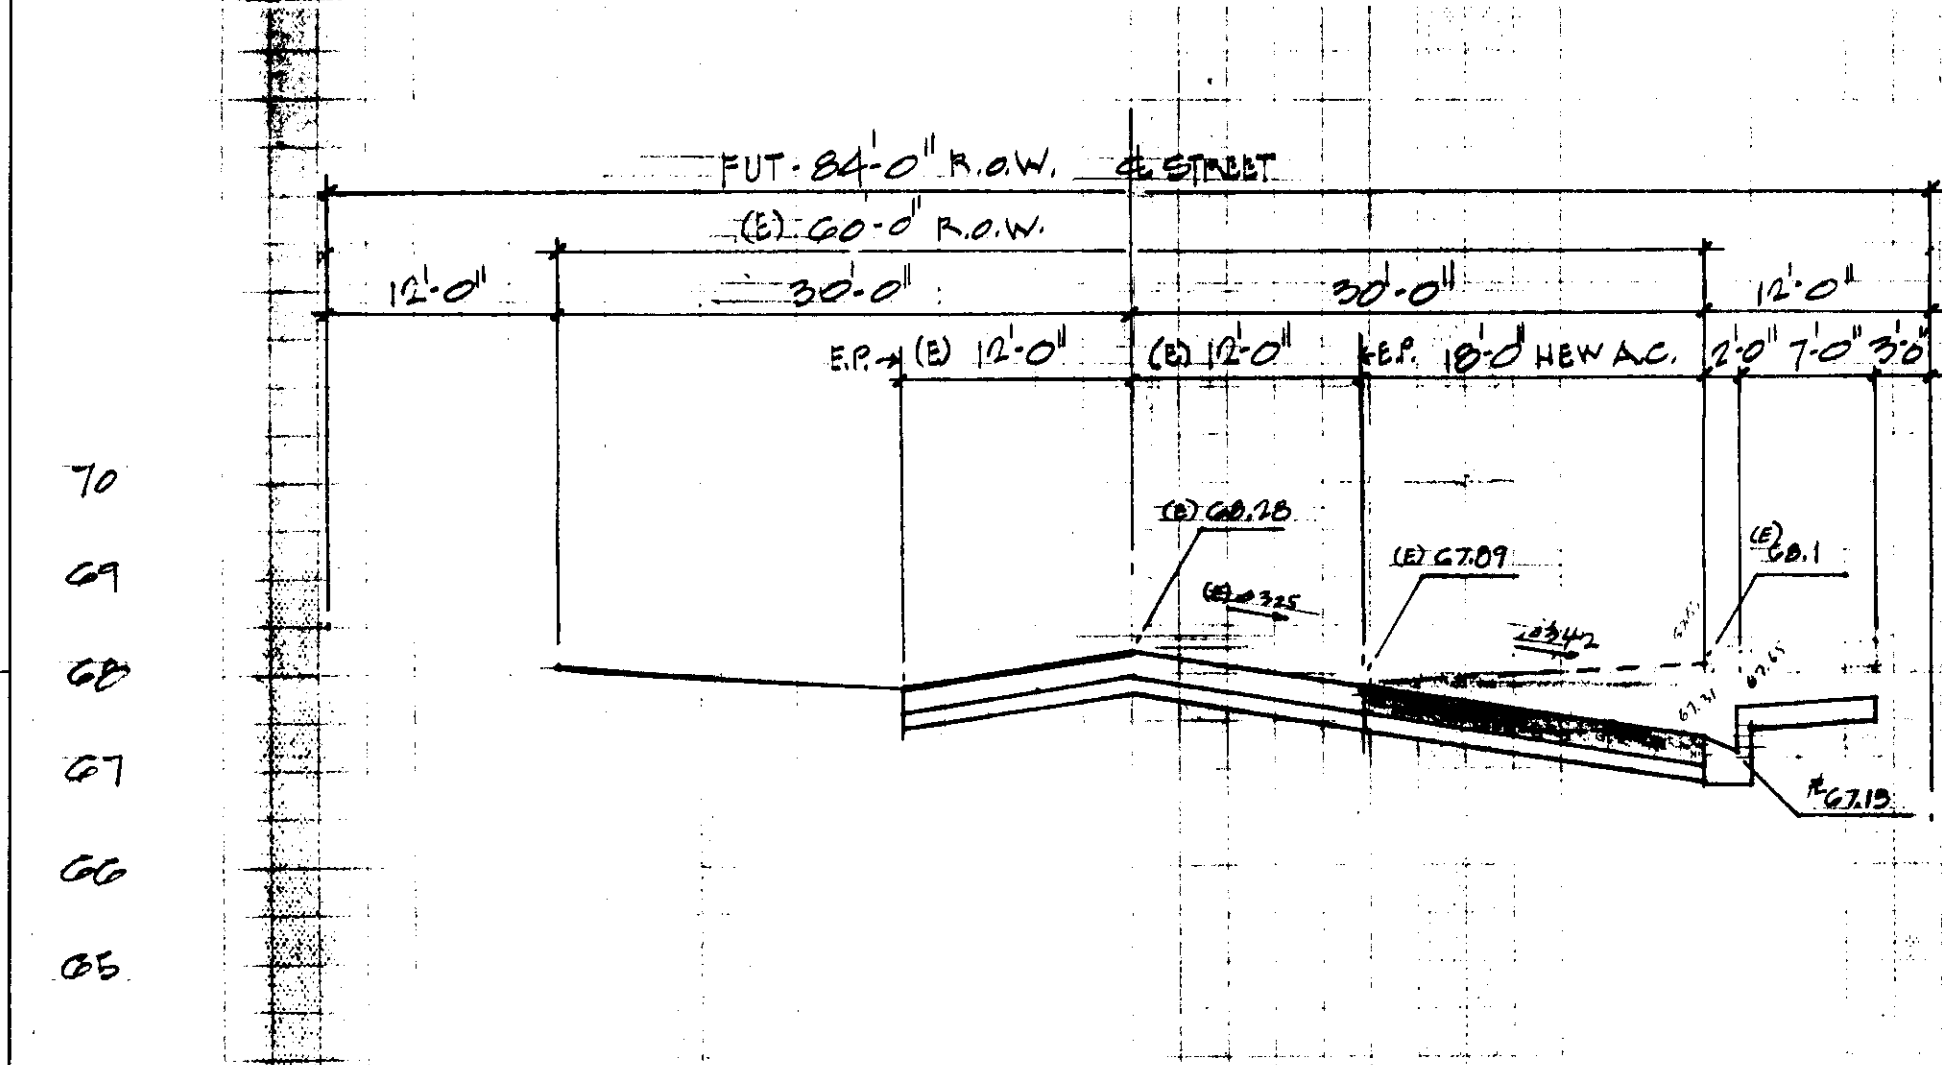

CROSS-SECTION - MURPHY ROAD - S.P. 6+70
HORIZ. SCALE - 1" = 10'-0"
VERT. SCALE - 1" = 2'-0"

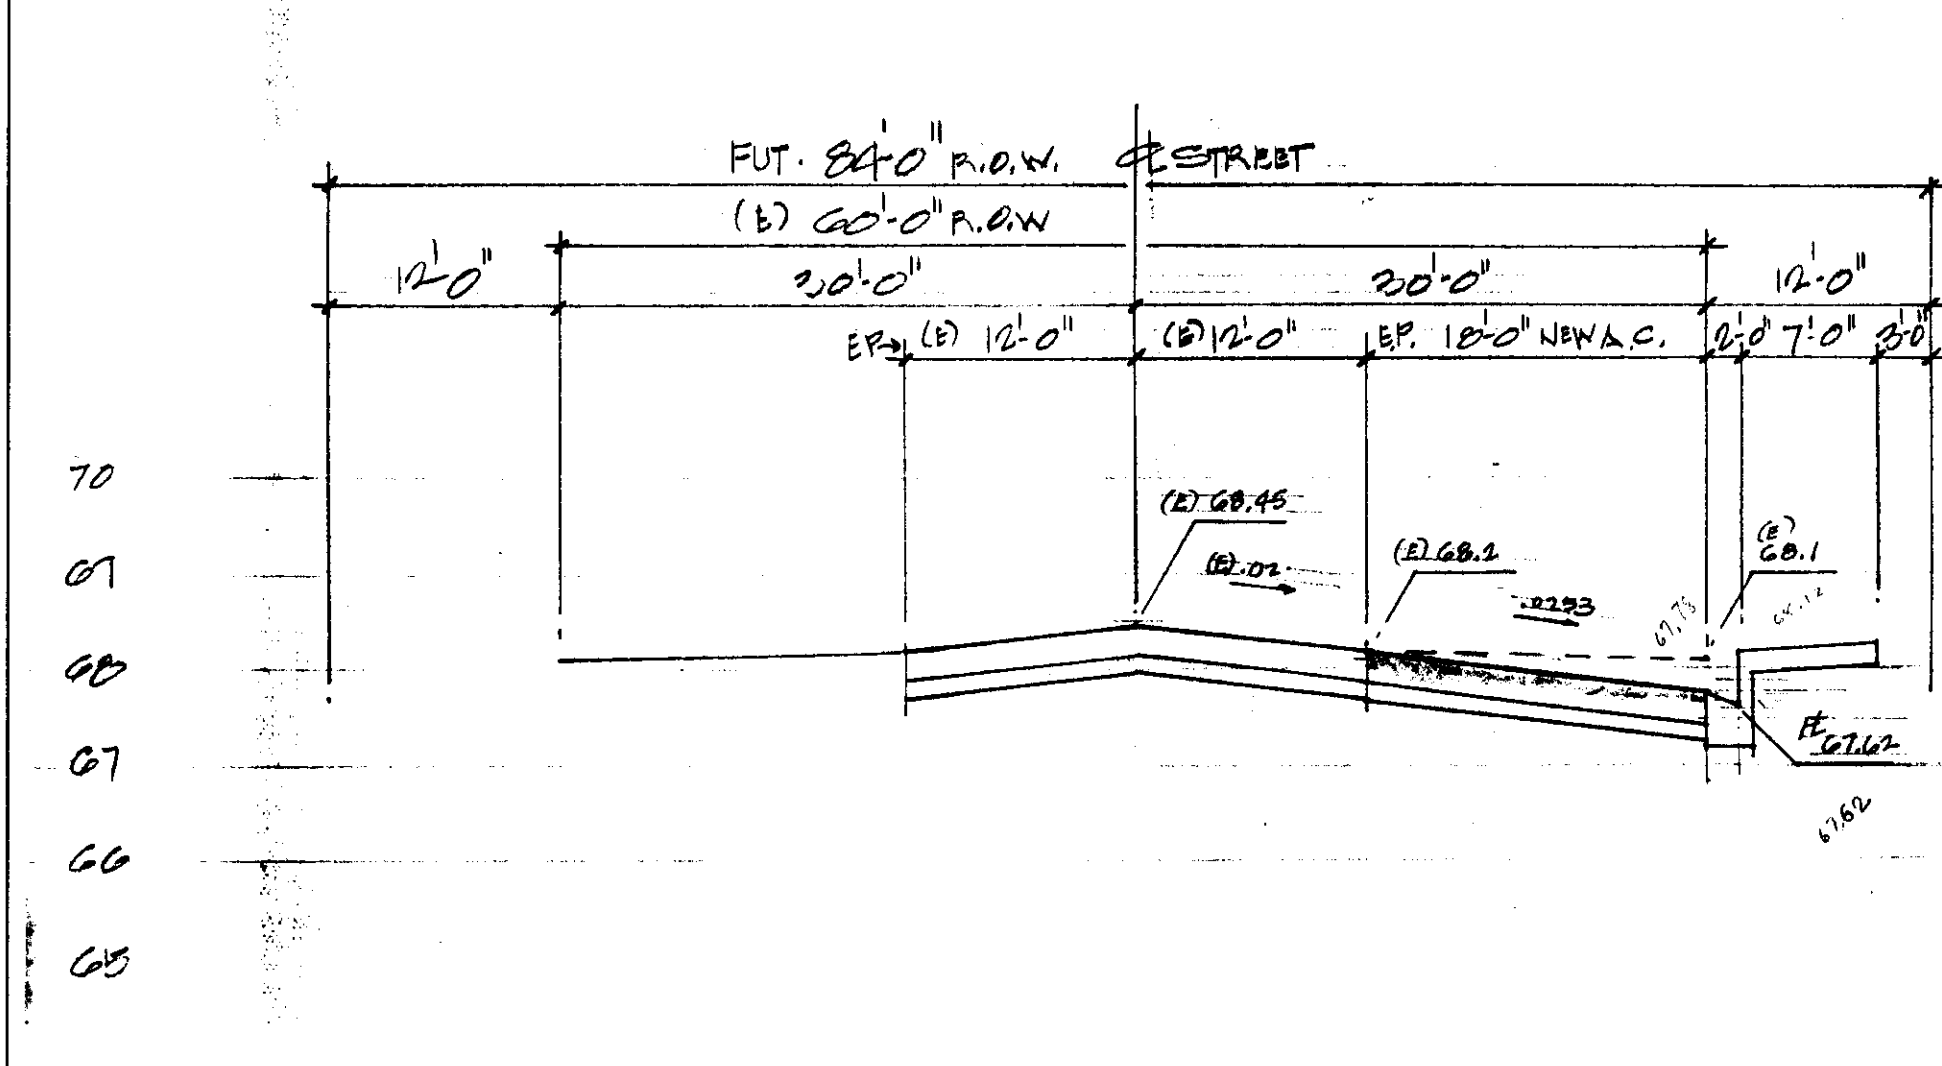


CROSS-SECTION - MURPHY ROAD - S.P. 7+70
HORIZ. SCALE - 1" = 10'-0"
VERT. SCALE - 1" = 2'-0"

NOTE: THE CONTRACTOR SHALL CHECK ALL DIMENSIONS AT THE JOB AND SHALL BE RESPONSIBLE FOR ALL DISCREPANCIES BETWEEN DIMENSIONS OF THE ACTUAL WORK AND THOSE SHOWN IN THE DOCUMENTS OR ARCHITECT'S APPROVED SHOP DRAWINGS.


70
67
66
65

70
67
66
65


70
67
66
65

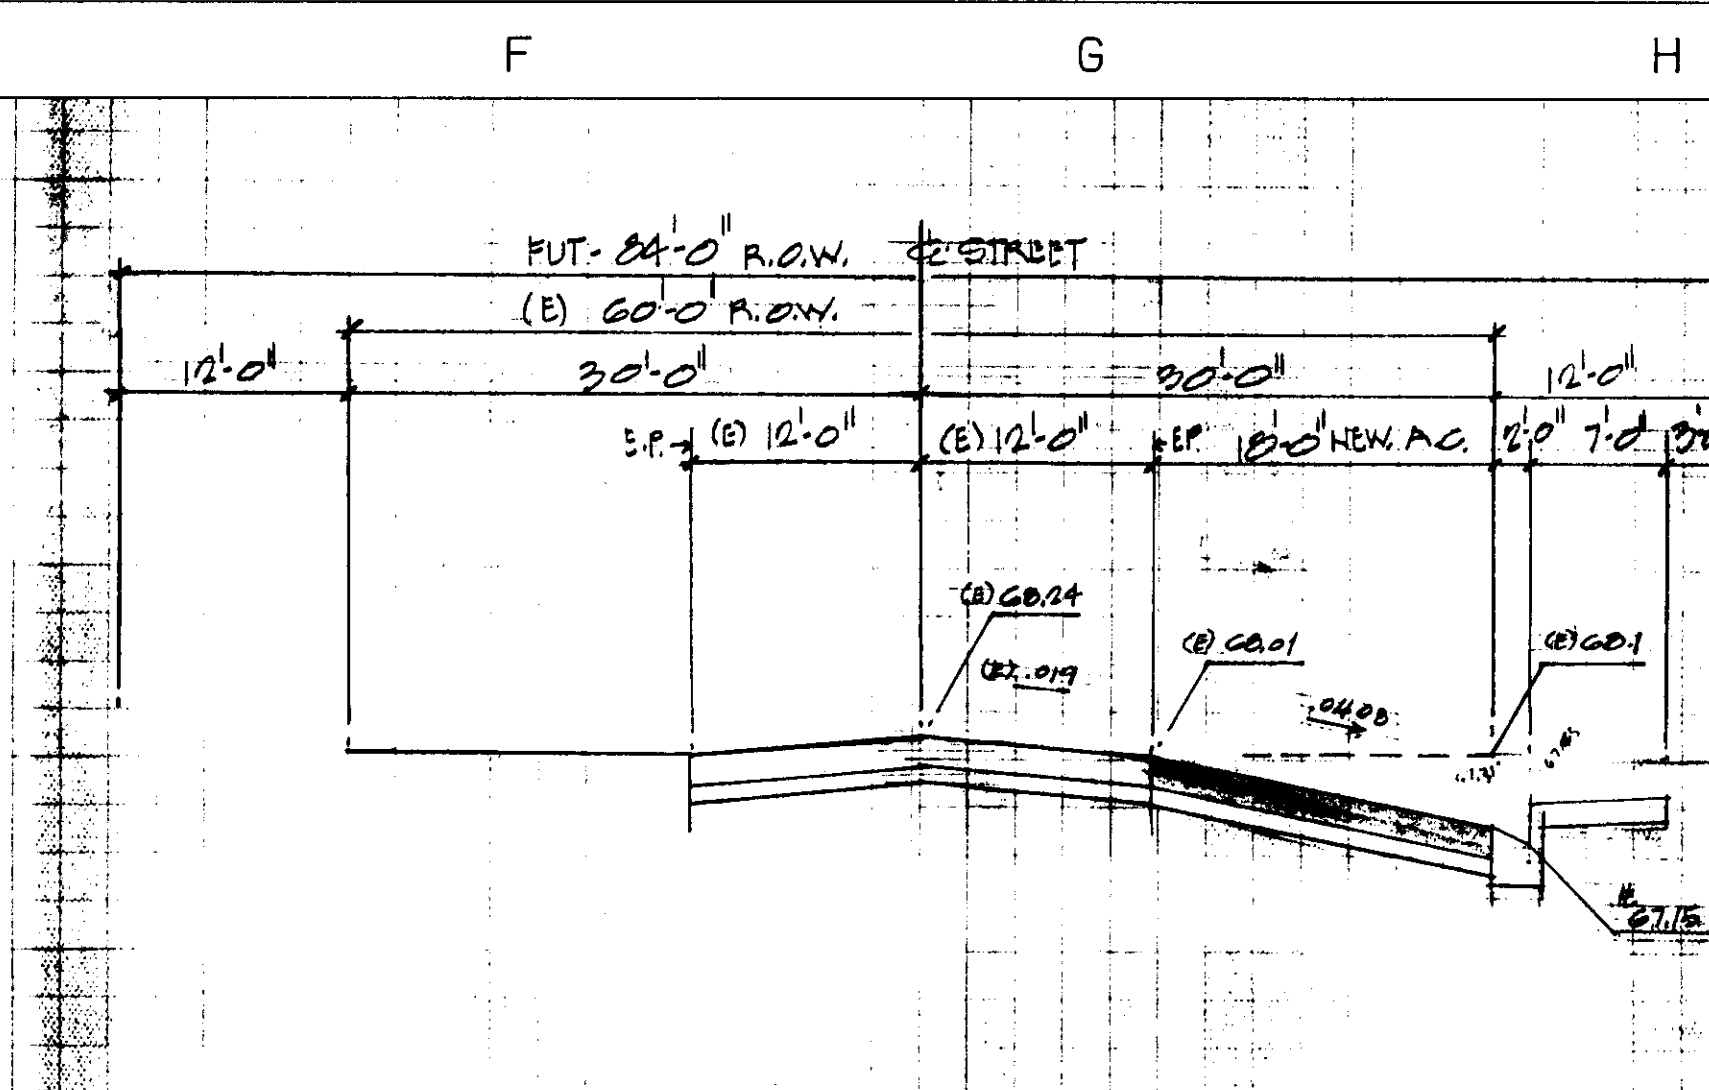

CROSS-SECTION - MURPHY ROAD - S.P. 8+70
HORIZ. SCALE - 1" = 10'-0"
VERT. SCALE - 1" = 2'-0"

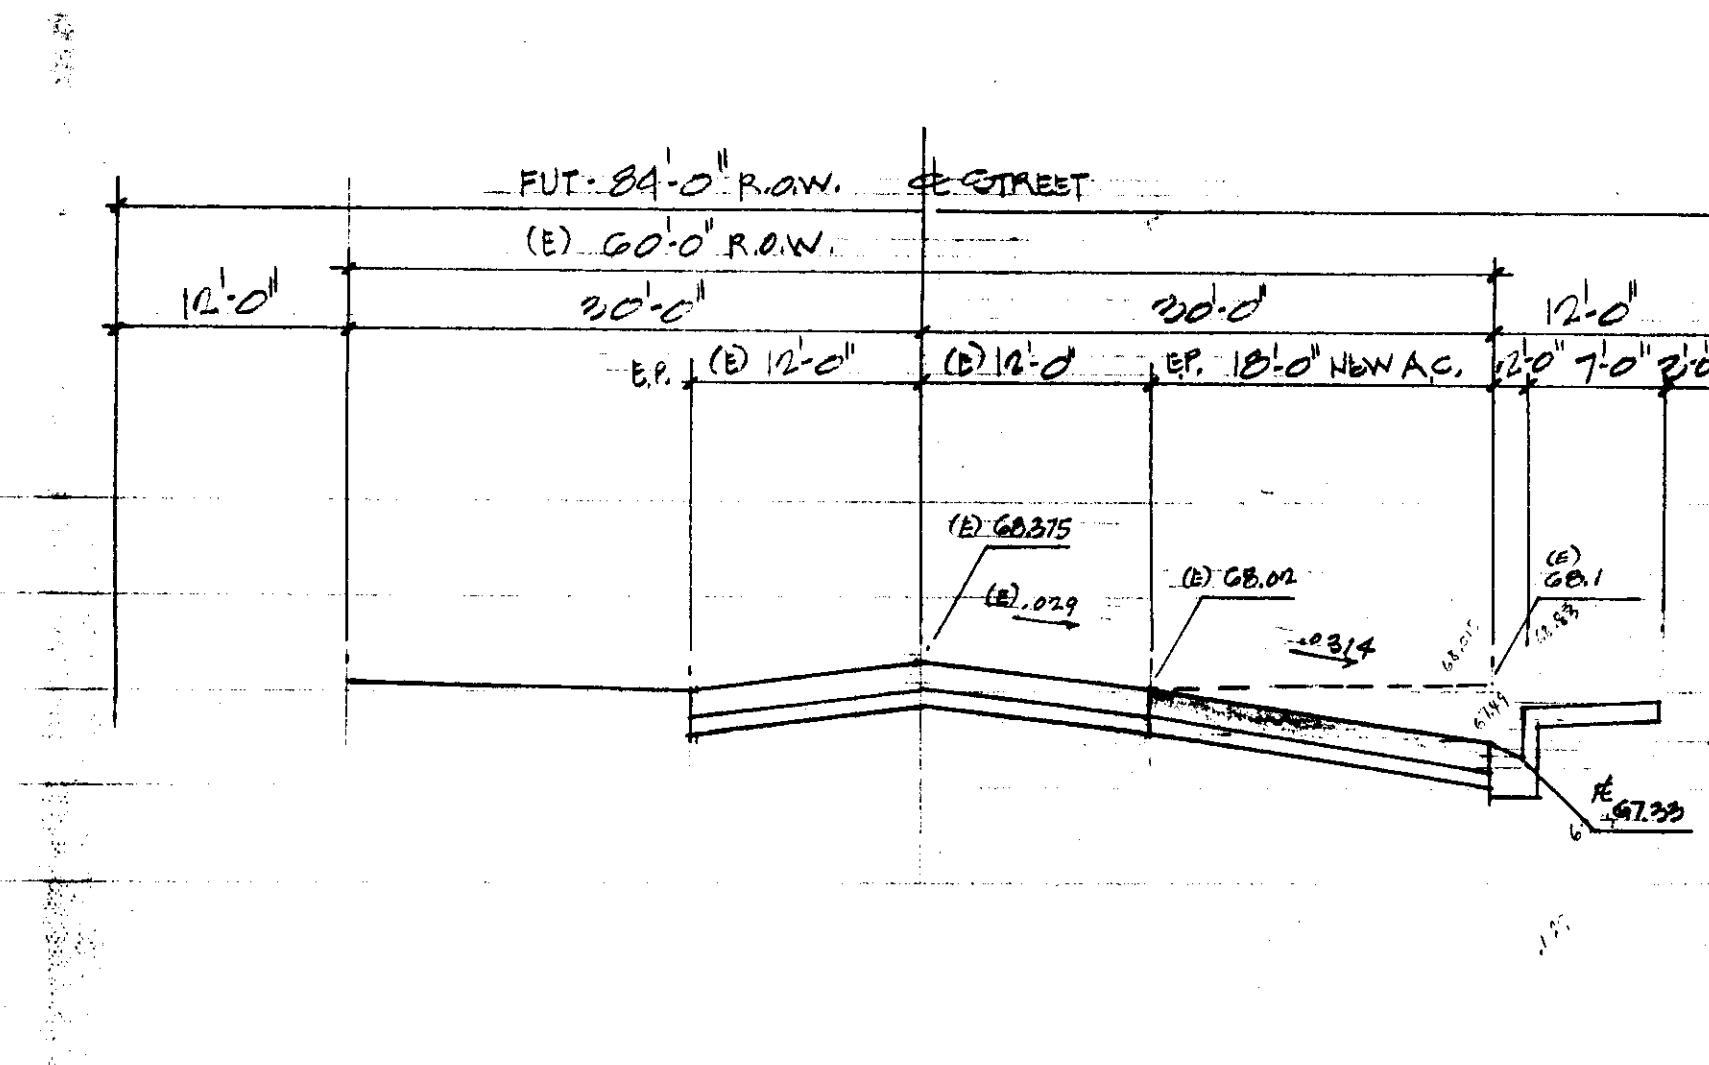

CROSS-SECTION - MURPHY ROAD - S.P. 9+70
HORIZ. SCALE - 1" = 10'-0"
VERT. SCALE - 1" = 2'-0"

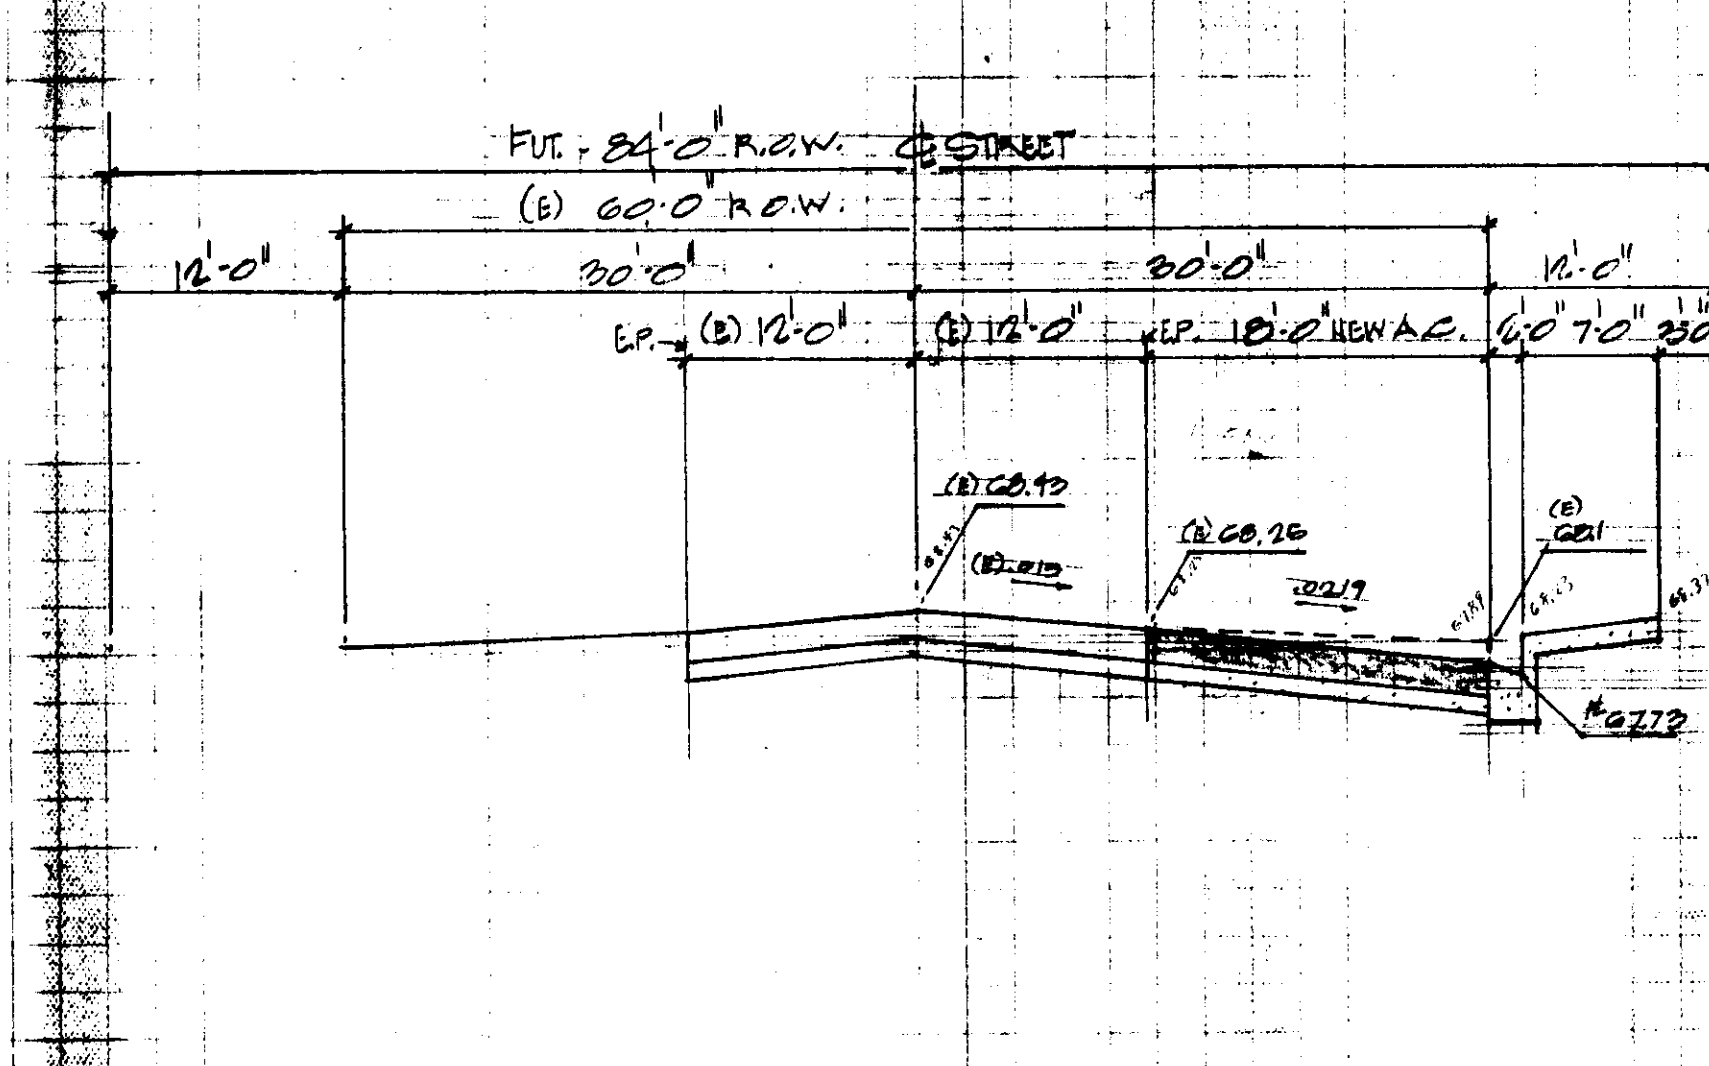


CROSS-SECTION - MURPHY ROAD - S.P. 10+70
HORIZ. SCALE - 1" = 10'-0"
VERT. SCALE - 1" = 2'-0"


70
67
66
65

70
67
66
65


70
67
66
65

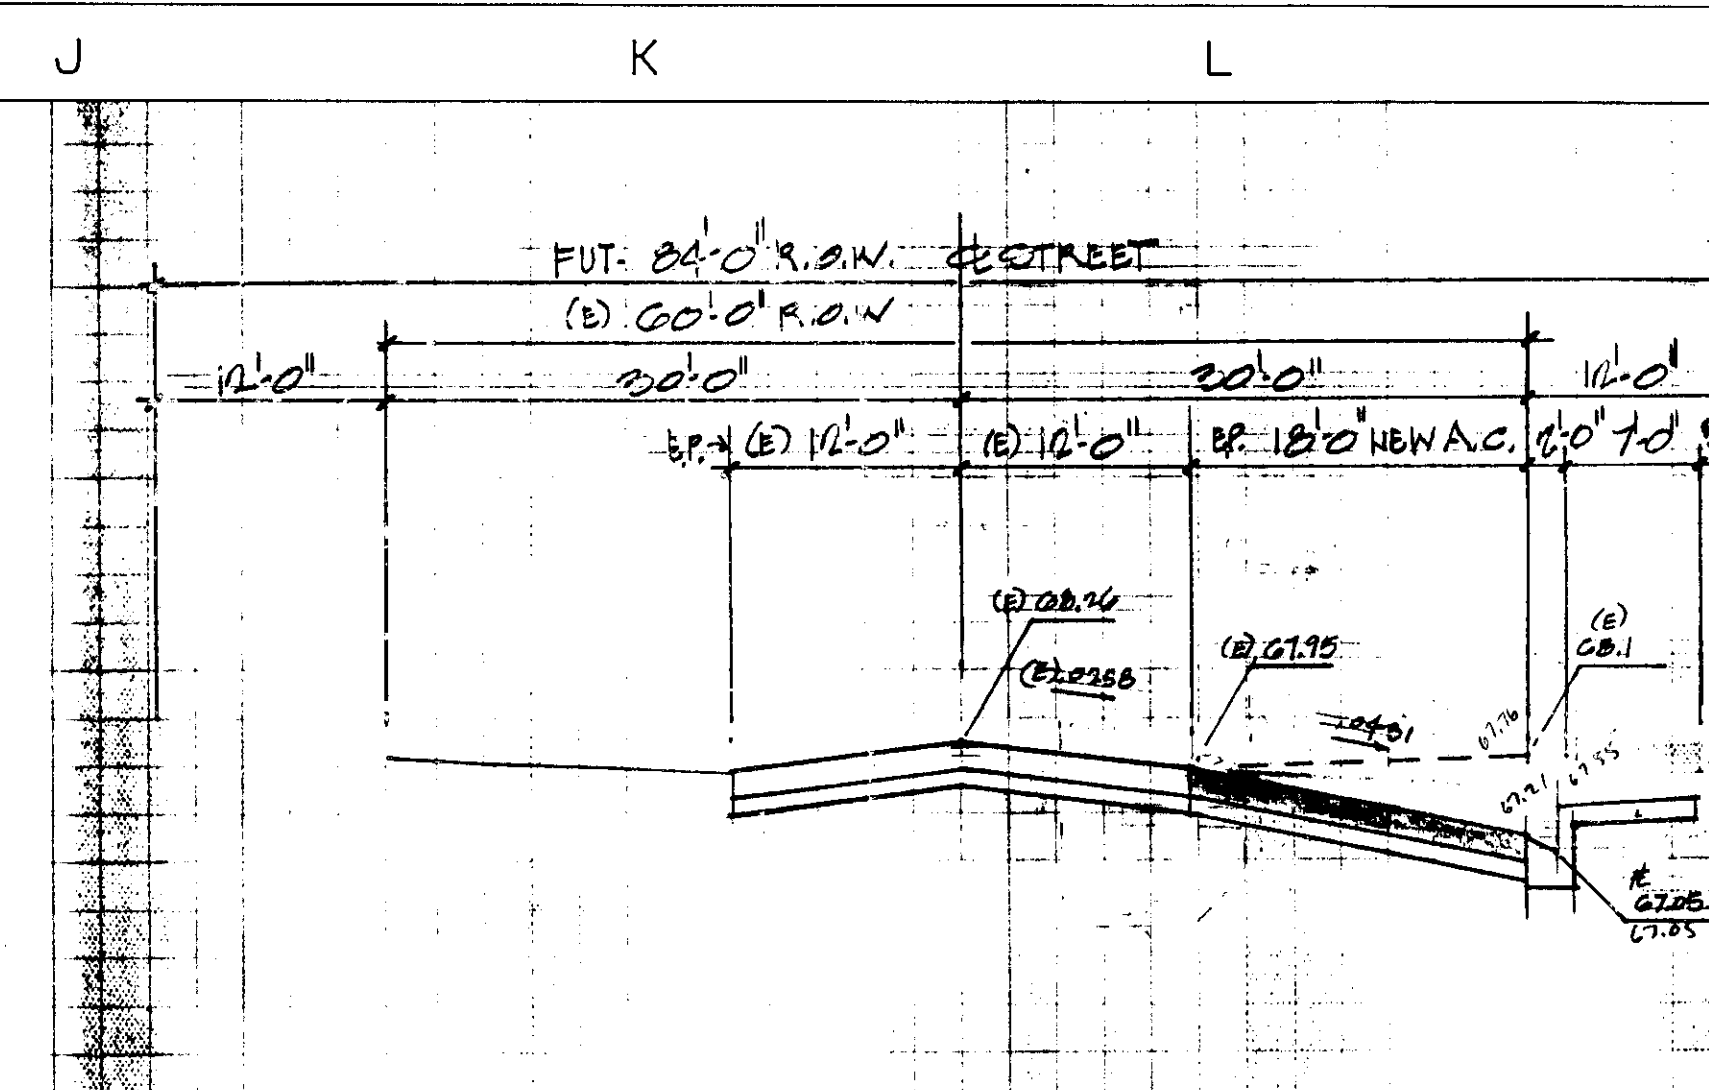

CROSS-SECTION - MURPHY ROAD - S.P. 11+70
HORIZ. SCALE - 1" = 10'-0"
VERT. SCALE - 1" = 2'-0"

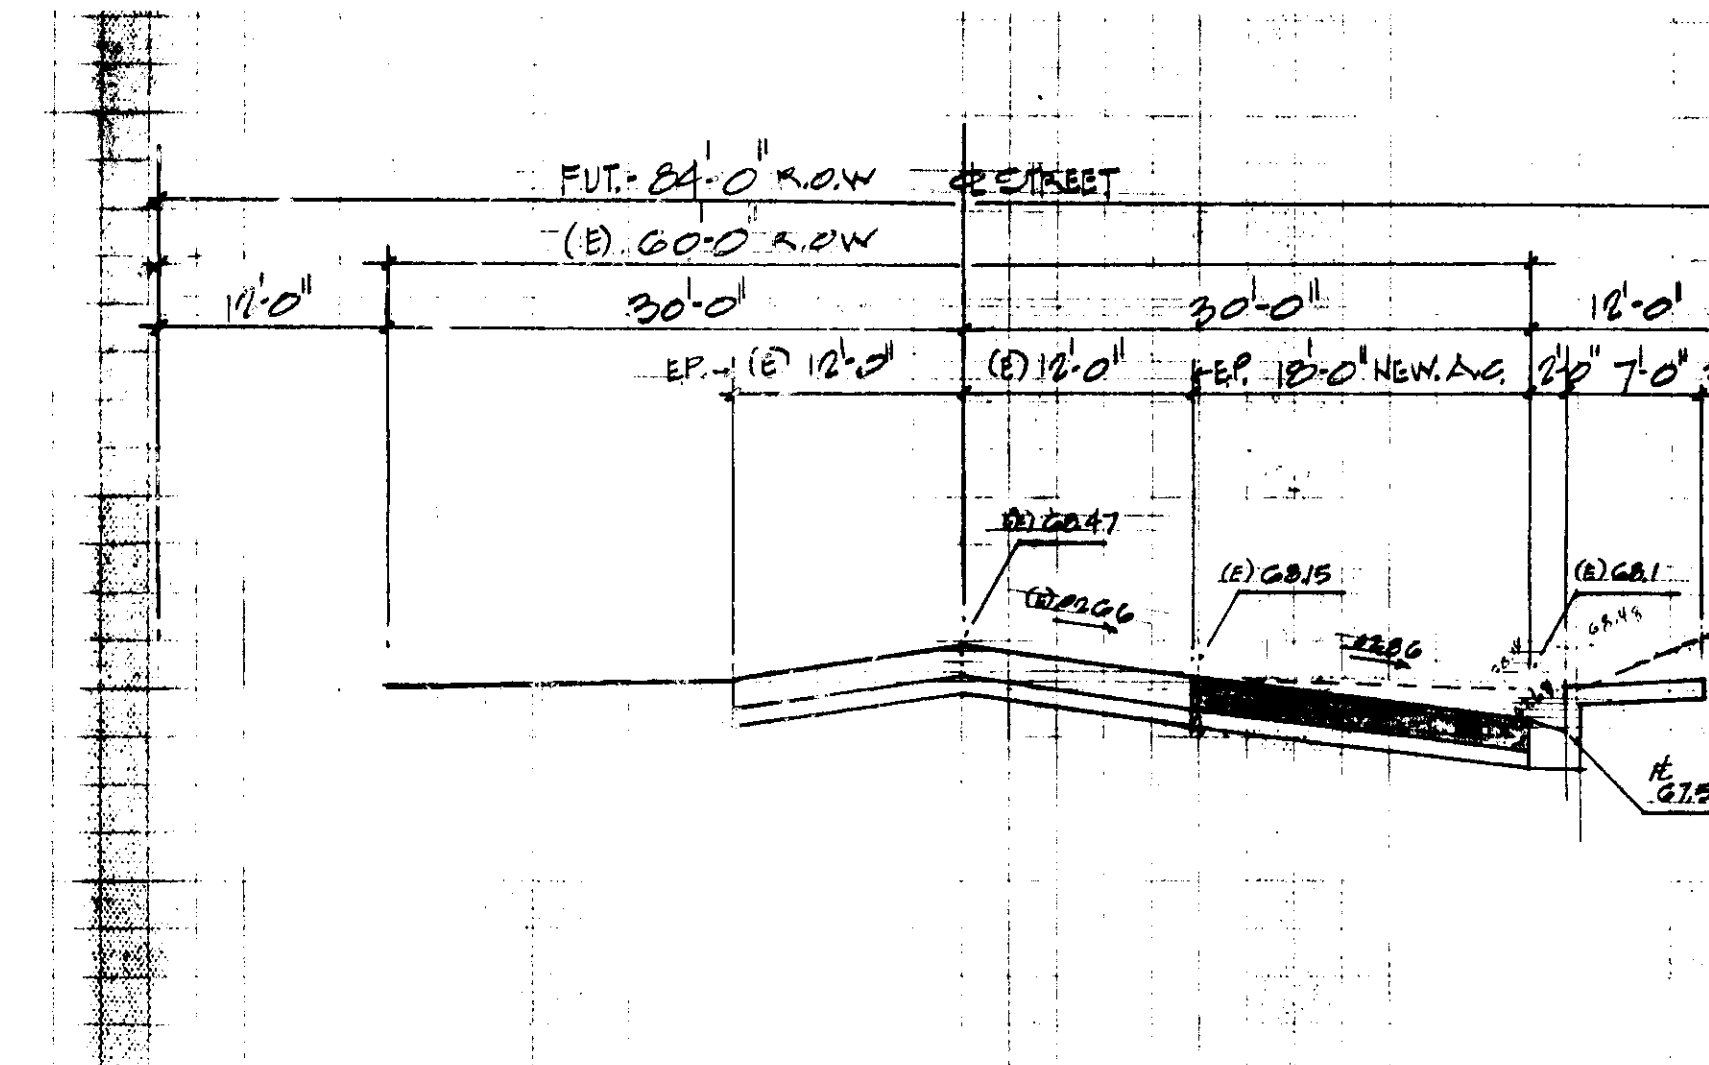

CROSS-SECTION - MURPHY ROAD - S.P. 12+70
HORIZ. SCALE - 1" = 10'-0"
VERT. SCALE - 1" = 2'-0"

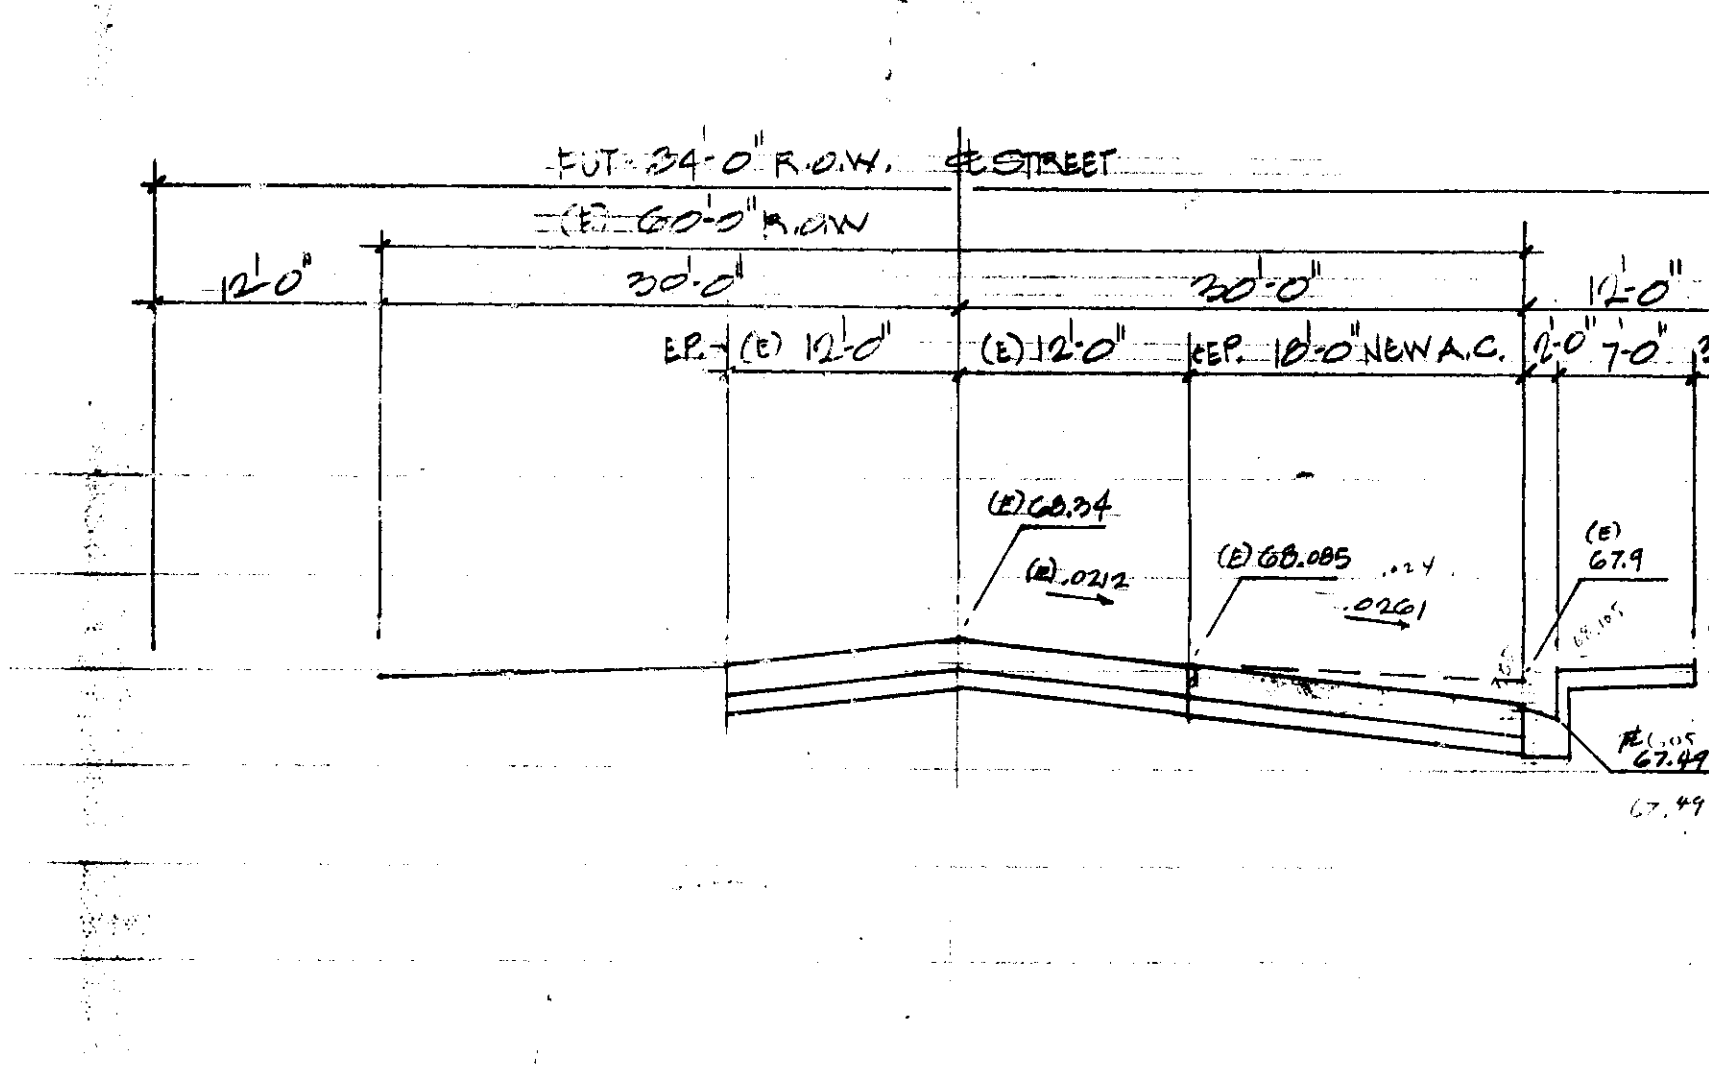


CROSS-SECTION - MURPHY ROAD - S.P. 13+70
HORIZ. SCALE - 1" = 10'-0"
VERT. SCALE - 1" = 2'-0"

70
67
66
65

70
67
66
65

70
67
66
65

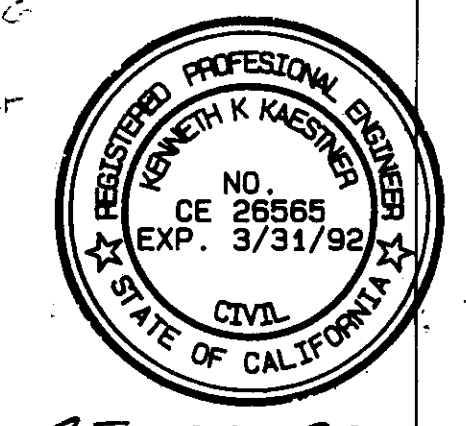

OFFICE OF STATE FIRE MARSHAL
APPROVED

Approval of this plan does not authorize or approve any omission or deviation from applicable regulations. Final approval is subject to field inspection. One set of approved plans shall be available on the project site at all times.

Reviewed by: [Signature]
11/29/81

KAESTNER & ASSOCIATES
ARCHITECTS
1600 SUNRISE AVE. SUITE 3
MERCED, CALIFORNIA 95360
TEL. (209) 384-9212


PROJECT TITLE
SANTOS AVENUE ELEMENTARY SCHOOL
RIPON UNIFIED SCHOOL DISTRICT
SANTOS AVE. & MURPHY ROAD
RIPON, CA.

PROJ. NO.
DATE 11/9/81

DRAWING TITLE
PHASE 1
MURPHY ROAD
CROSS SECTION

SHEET NO.
5

TITLE BLOCK LIB NAME: SYM-TB-242-0FF
MODULE/LAYERS REG'D:
LIB FILE:
SHEET NUMBER:

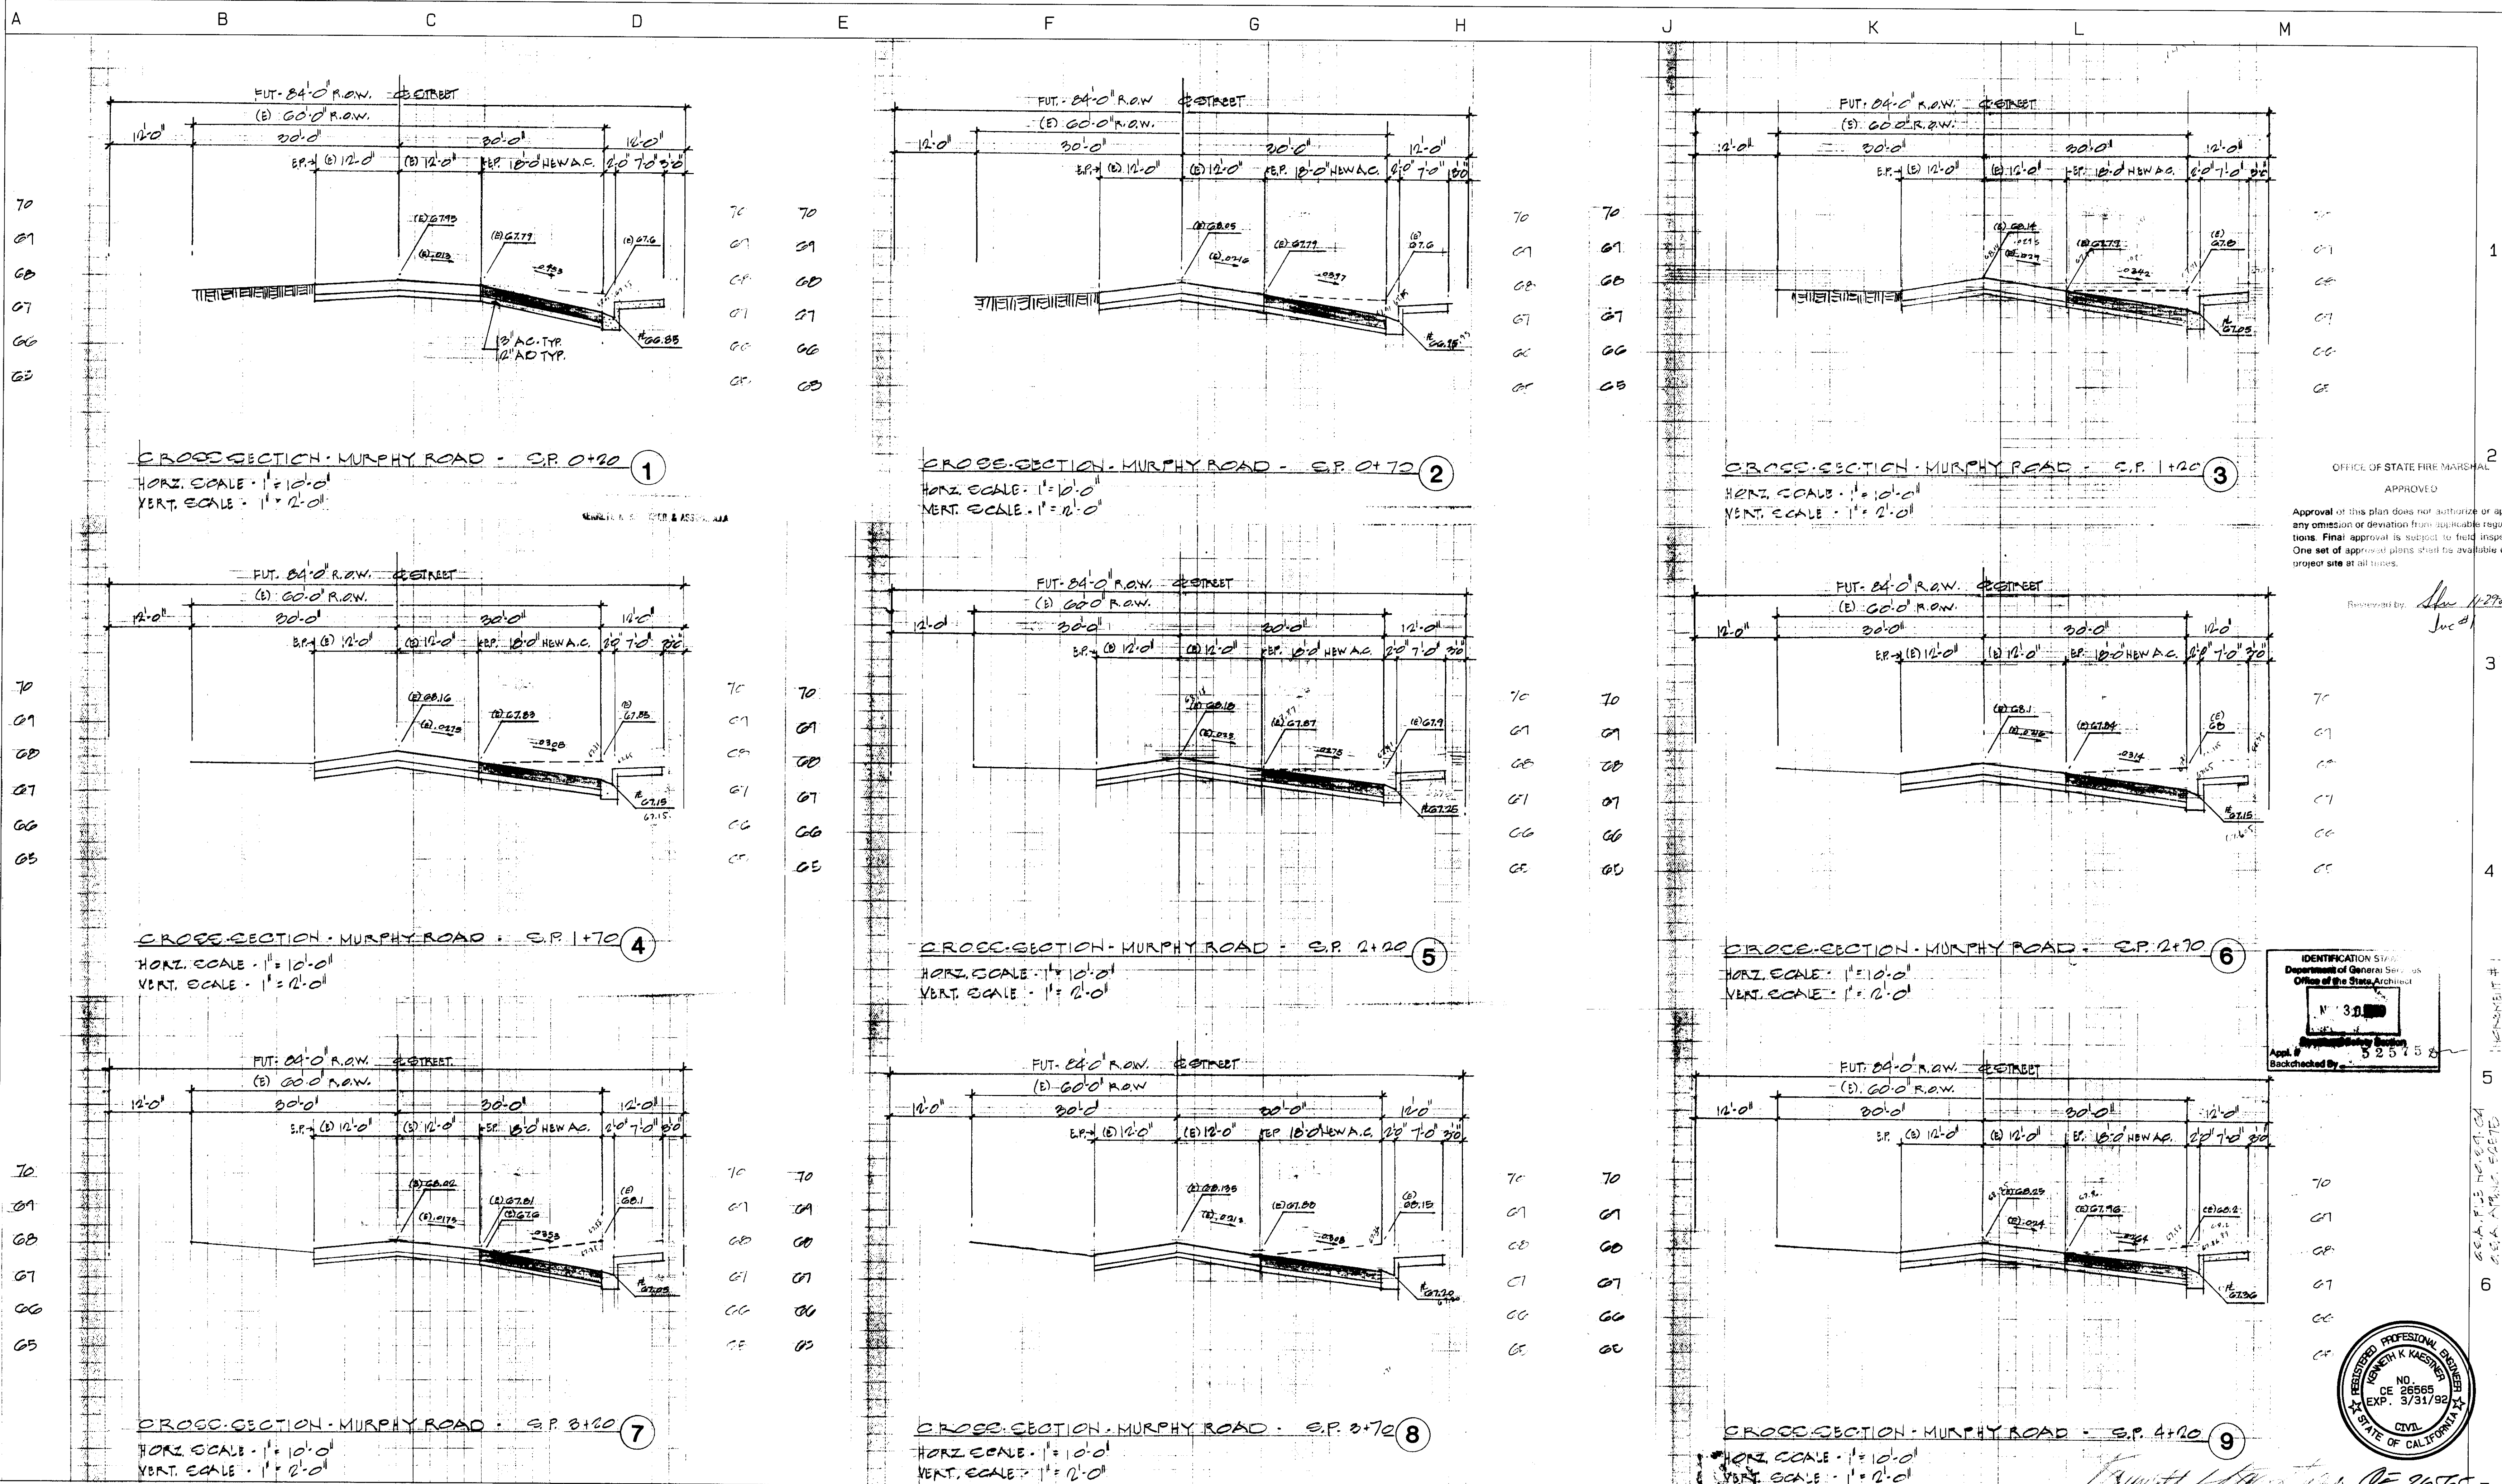



NOTE: THE CONTRACTOR SHALL CHECK ALL DIMENSIONS AT THE JOB AND SHALL BE RESPONSIBLE FOR ALL DISCREPANCIES BETWEEN DIMENSIONS OF THE ACTUAL WORK AND THOSE SHOWN IN THE DOCUMENTS OR ARCHITECT'S APPROVED SHOP DRAWINGS.

THE CONTRACTOR SHALL ALSO BE SOLELY RESPONSIBLE FOR ALL QUANTITIES OF MATERIAL OR EQUIPMENT CALLED FOR TO PROPERLY COMPLETE THE WORK.

OFFICE OF STATE FIRE MARSHAL
APPROVED

Approval of this plan does not authorize or apply any omission or deviation from applicable regulations. Final approval is subject to field inspection. One set of approved plans shall be available on the project site at all times.

Reviewed By: *[Signature]*
Jue 4

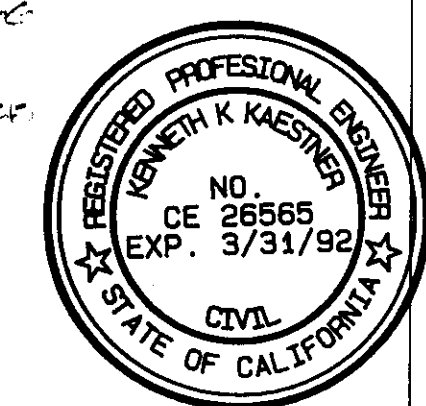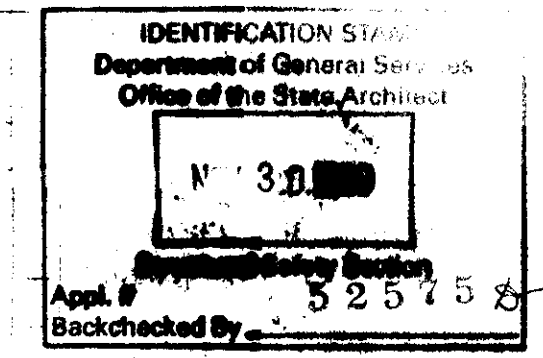

KAESTNER & ASSOCIATES
ARCHITECTS
1600 SUNRISE AVENUE, SUITE 3
MIDCOTO, CALIFORNIA 95350
TEL. (408) 324-3212

5273 MAY 27 1992
INTEGRATION FILE NO. 100

**SANTOS AVENUE ELEMENTARY SCHOOL
RIPON UNIFIED SCHOOL DISTRICT**
SANTOS AVE. & MURPHY ROAD
RIPON, CA.

PROJECT TITLE
PROJ. NO.
DATE 1/5/91

DRAWING TITLE
**PHASE 1
MURPHY ROAD
CROSS SECTIONS**

SHEET NO.
4

90-2302

TITLE BLOCK LIB NAME: SW-TB-2442-0FF

MODULES/LAYERS REQ'D.:

LIB. FILE:

SHT. NUMBER:

A B C D E F G H J K L M

1

2

3

4

5

6

7

OFFICE OF STATE FIRE MARSHAL
APPROVED

Approval of this plan does not authorize or approve
any omission or deviation from applicable regula-
tions. Final approval is subject to field inspection.
One set of approved plans shall be available on the
project site at all times.

Reviewed by: *Jan 11-2989*
Jue #1

KAESTNER & ASSOCIATES
ARCHITECTS
ENGINEERS
1800 SANFORD AVE. SUITE 3
MODESTO, CALIFORNIA 95350
TEL. (209) 924-9512



52570 NOV 29 89
ATTENTION: PER W. J. J. J.

SANTOS AVENUE ELEMENTARY SCHOOL
RIPON UNIFIED SCHOOL DISTRICT
SANTOS AVE. & MURPHY ROAD
RIPON, CA.

PROJ. NO.
DATE 11/6/89


DRAWING TITLE
**STREET
PROFILE**
PHASE 1

SHEET NO.

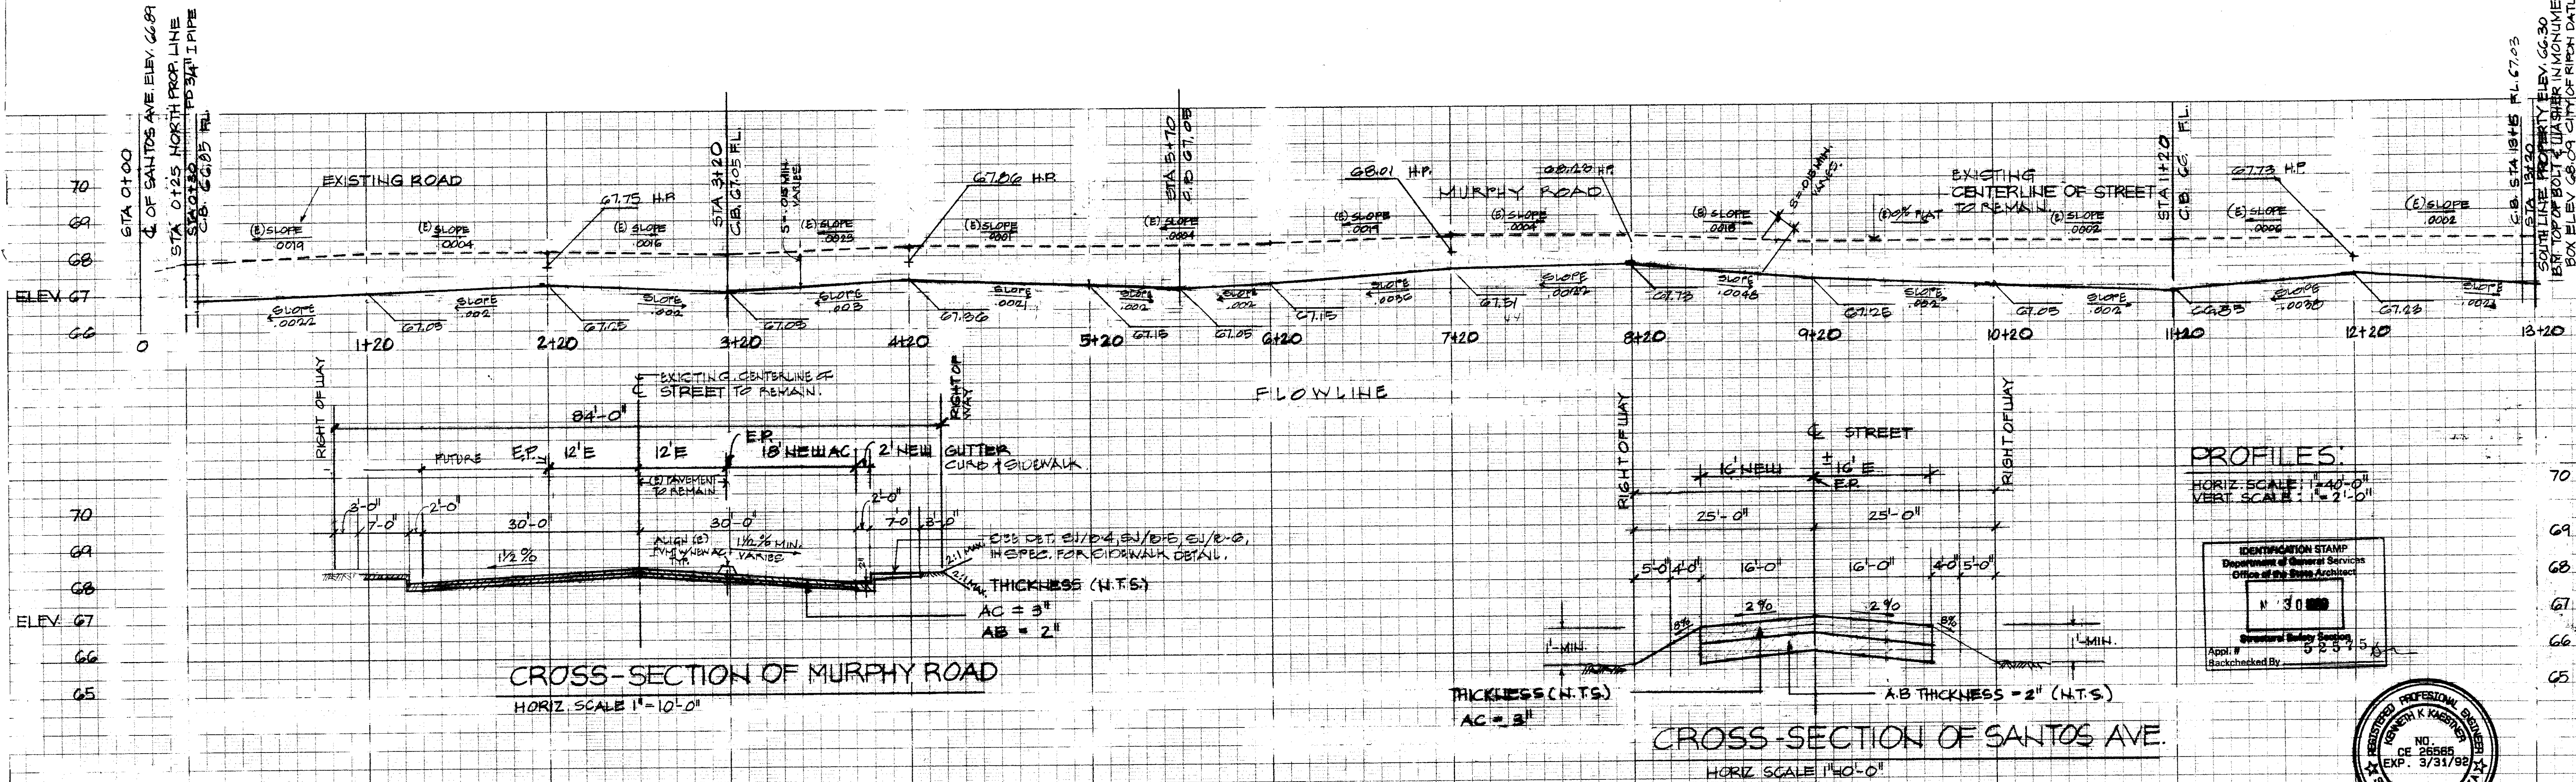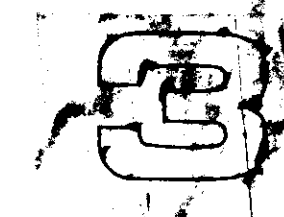


PROFILES:
HORIZ. SCALE: 1"=40'-0"
VERT. SCALE: 1"=2'-0"

IDENTIFICATION STAMP
Department of General Services
Office of the State Architect
N 30 000
App'l. #
Backchecked By

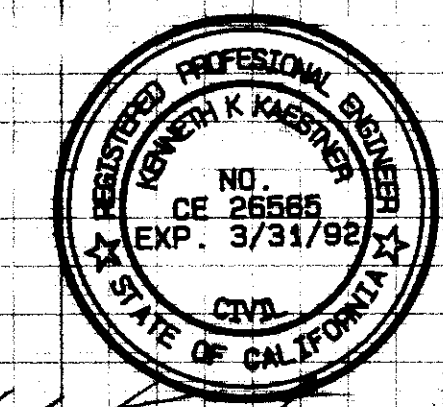

NOTE: THE CONTRACTOR SHALL CHECK ALL DIMENSIONS AT THE JOB
AND SHALL BE RESPONSIBLE FOR ALL DISCREPANCIES BETWEEN
DIMENSIONS OF THE ACTUAL WORK AND THOSE SHOWN IN THE DOCUMENTS
OR ARCHITECT'S APPROVED SHOP DRAWINGS.

THE CONTRACTOR SHALL ALSO BE SOLELY RESPONSIBLE FOR ALL QUANTITIES
OF MATERIAL OR EQUIPMENT CALLED FOR TO PROPERLY COMPLETE THE WORK.

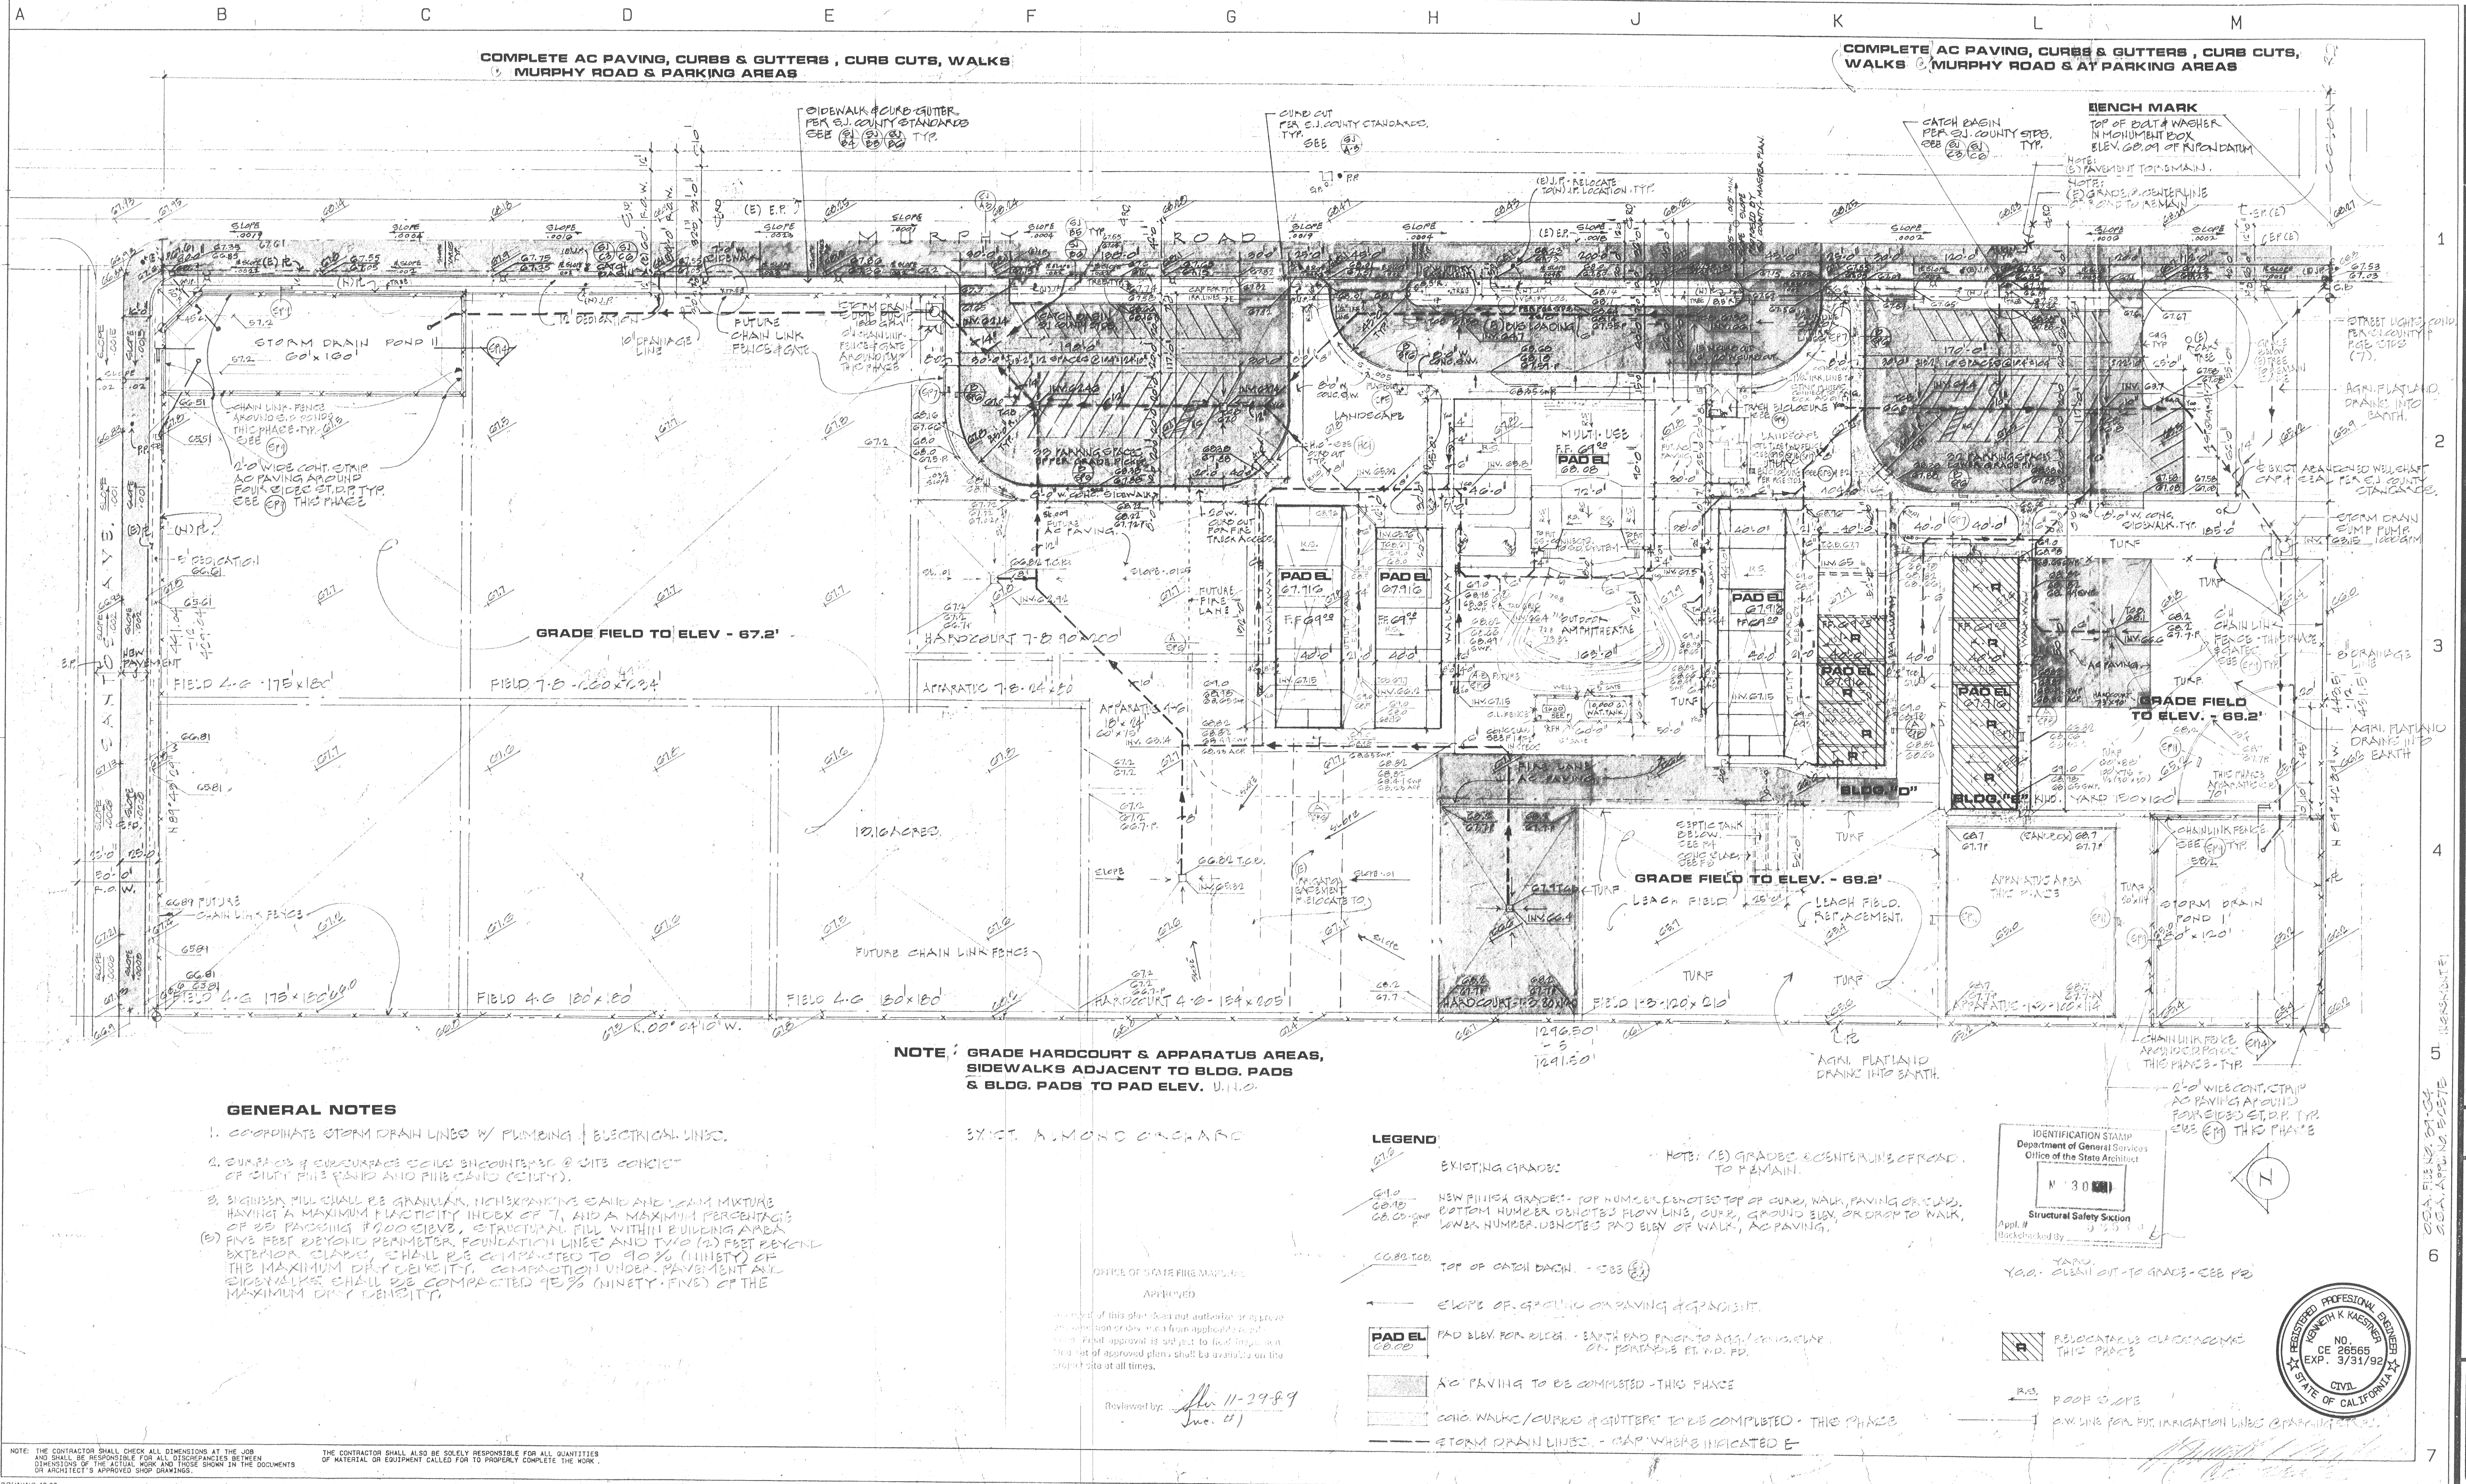


 KAESTNER & ASSOCIATES AIA ARCHITECTS ENGINEERS 1405 S. GATEWAY BLVD. MOUNTAIN VIEW, CALIFORNIA 95969 TEL. (916) 924-9212	
52570 0000 0000 UNIFIED SCHOOL DISTRICT	
PROJECT TITLE	SANTOS AVENUE ELEMENTARY SCHOOL RIPON UNIFIED SCHOOL DISTRICT SANTOS AVE. & MURPHY ROAD RIPON, CA.
PROJ. NO.	
DATE	
DRAWING TITLE SITE GRADING & DRAINAGE PLAN PHASE 1 SCALE: 1"=40'-0"	
SHEET NO. 2	

50-2304

MODULES/LAYERS REQ D.:

SHT. NUMBER:

TITLE BLOCK L

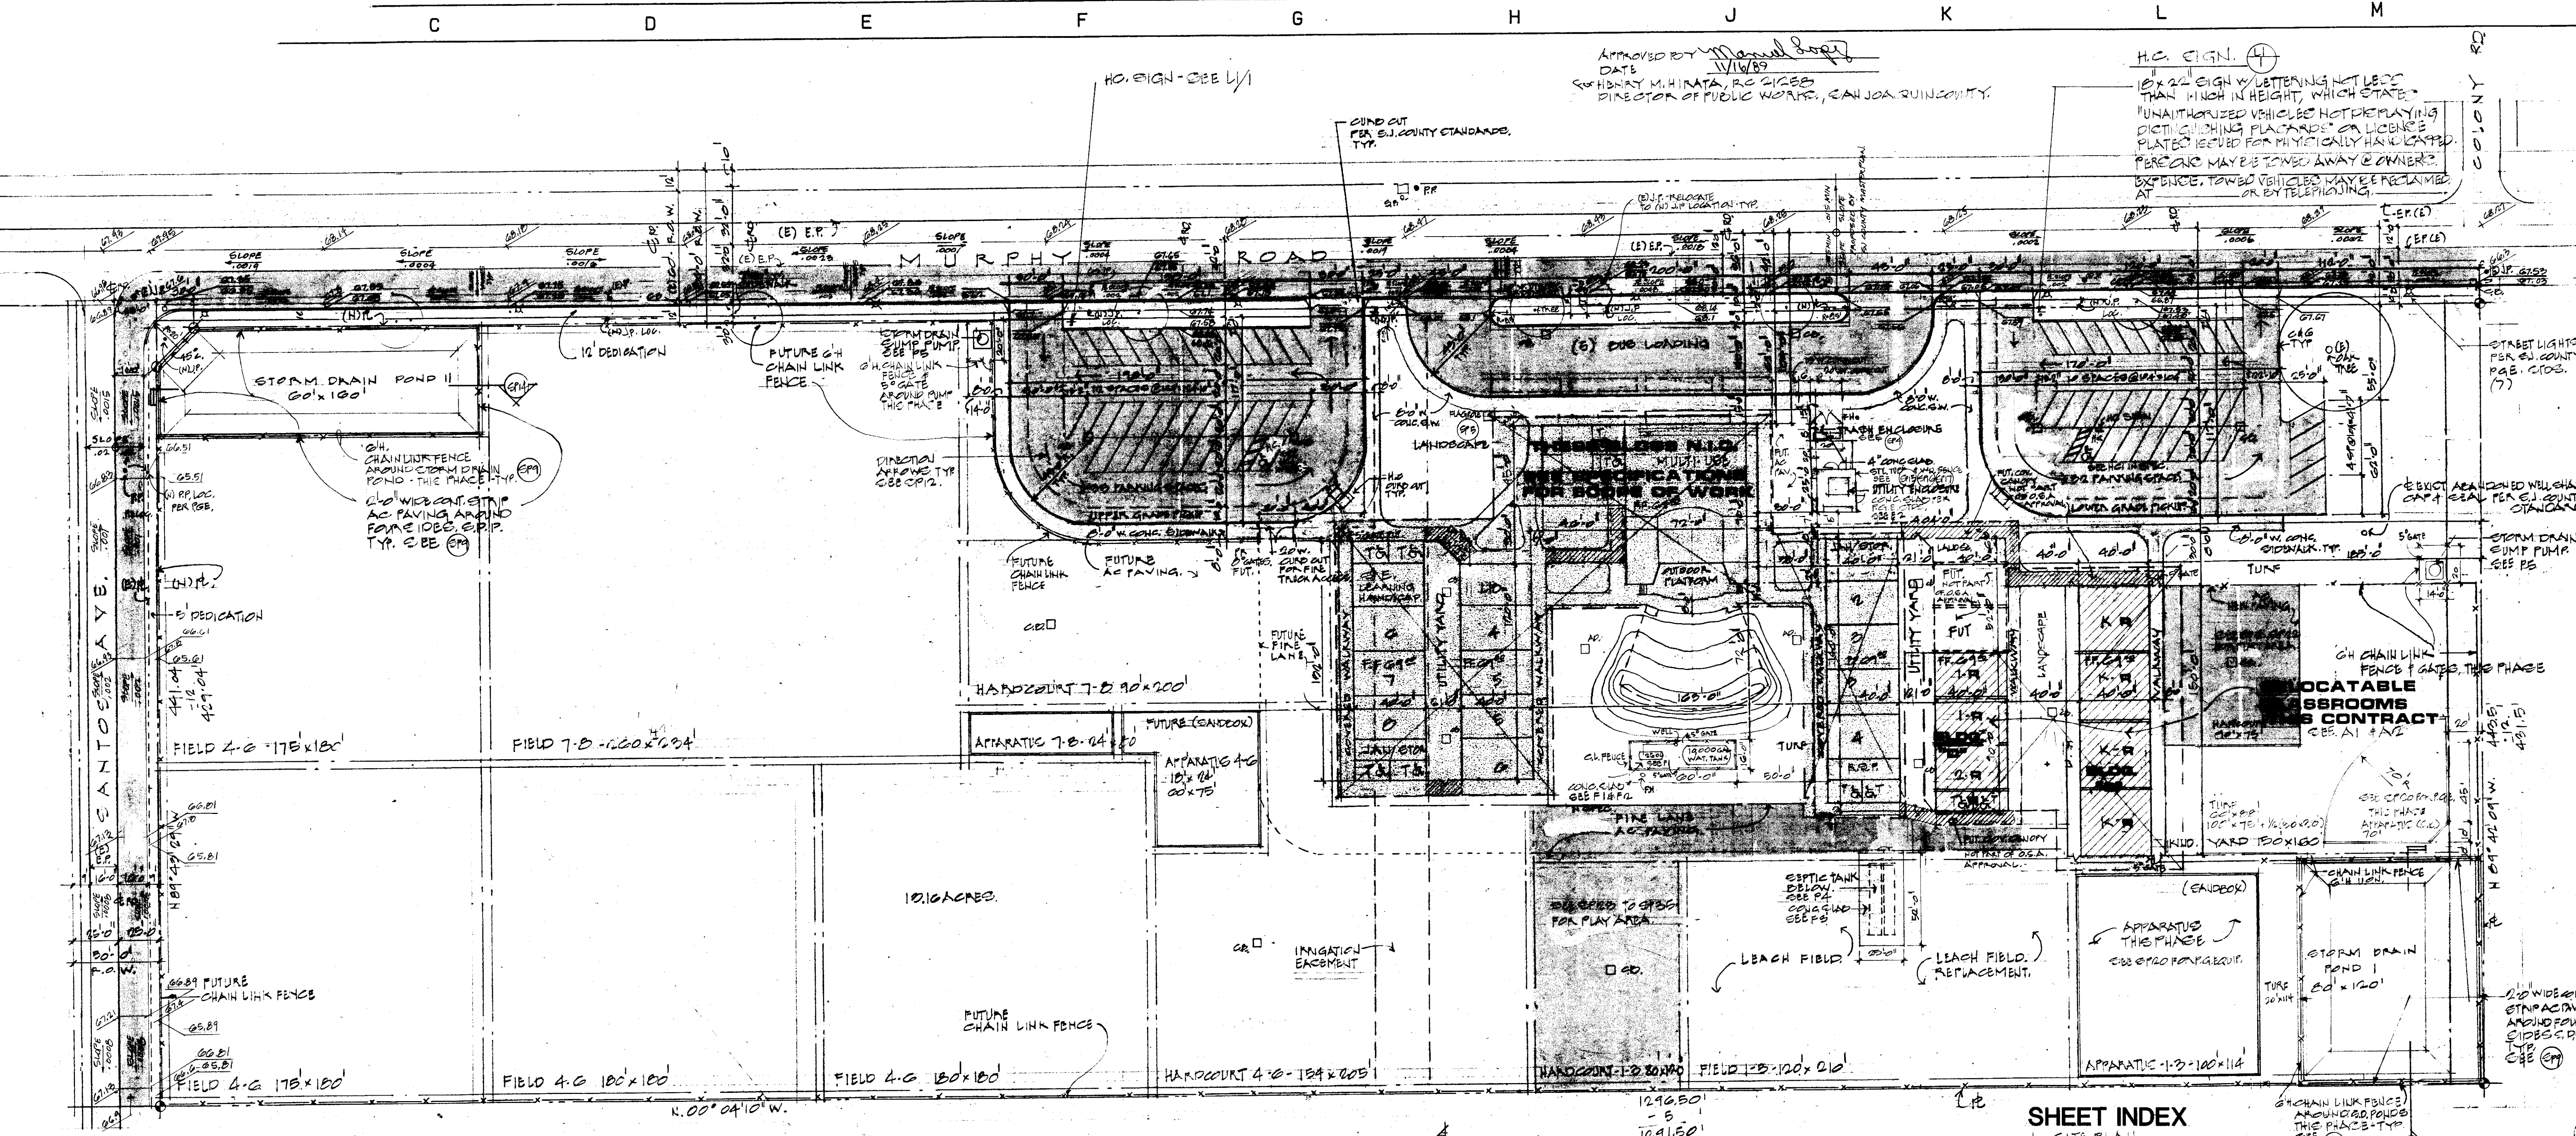

GENERAL NOTES

1. THERE SHALL BE OBSERVATION, TESTING, & INSPECTION DURING THE FOLLOWING:
 - a. SITE PREPARATION
 - b. GRADING
 - c. PLACEMENT OF ENGINEERED FILL
 - d. STAKING
 - e. EXCAVATION
 - f. BACKFILLING & COMPACTION
 - g. FOOTING EXCAVATIONS PRIOR TO PLACEMENT OF REINFORCING STEEL
 - h. CONCRETE AND REINFORCING STEEL
2. SEE C-1 FOR TYPICAL STRUCTURAL NOTES.
3. For each chain link fence gate provide Schlage Padlock with 6 pin removable core which can be keyed with door locks. For quantity and locations see Site Plans, Floor Plan, etc., where shown.
4. AT RELOC CLASSROOM - SEE #B, PG. 6 OF SPECIFICATIONS FOR HARDWARE.
 - a. Provide 3 keys for each lock. Stamp with set indication. Master key to be stamped "DO NOT DUPLICATE"

LEGEND

- AC PAVEMENT TO BE COMPLETED THIS PHASE
- CONC. WALKS/SLABS TO BE COMPLETED THIS PHASE
- FUTURE COVERED CANOPY AREAS.
- FUTURE PDLGS.
- RELOCATABLE CLASSROOMS THIS PHASE
- H.O. ACCESSIBLE RESTROOMS.

EXIST. ALMOND ORCHARD

NOTE: FOR GRADING & DRAINAGE WORK THIS PHASE SEE SHT. 2.

APPROVAL OF THESE PLAN BY THE CALIF. STATE FIRE MARSHAL DOES NOT EMPLY APPROVAL OF LOCATION FUTURE BUILDINGS NOT IN THIS CONTRACT.


BUILDING DATA

OCCUPANCY	E-1
CONSTRUCTION	TYPE "V" - NO HR.
SQUARE FEET - BLDG. "D" - R-CLERK/TOL.	3300 SF.
BLDG. "E" - R-CLERK/TOL.	5700 SF.
TOTAL SQUARE FEET	9120 SF.

OFFICE OF STATE FIRE MARSHAL
APPROVED

Approval of this plan does not authorize or approve any omission or deviation from applicable regulations. Final approval is subject to field inspection. One set of approved plans shall be available on the project site at all times.

Reviewed by *sfw* 11-29-89
June 4

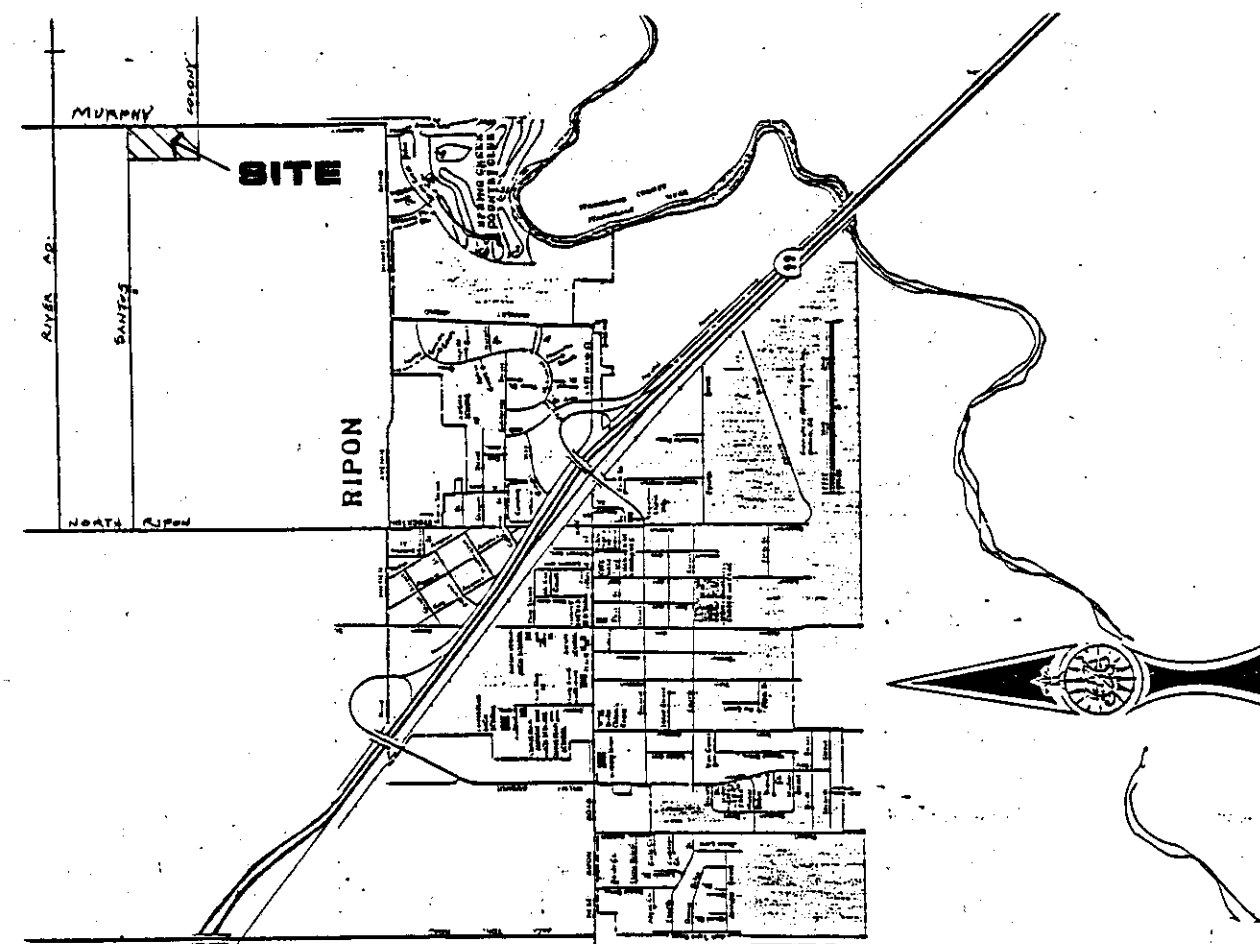

VICINITY MAP

SHEET INDEX

1. SITE PLAN
2. SITE GRADING & DRAINAGE PLAN
3. EXIST. PROPOSED CLOSURE
4. MURPHY ROAD - CROSS SECTION
5. MURPHY ROAD - CROSS SECTION
6. MURPHY ROAD - CROSS SECTION

ARCHITECTURAL


- A1 RELOCATABLE CLASSROOM FLOOR PLAN
- A2 RELOCATABLE KINDERGARTEN CLRM. FLOOR PLAN
- A3 EXTERIOR ELEVATIONS
- A4 INTERIOR ELEVATIONS

STRUCTURAL & TYPICAL NOTES AND DETAILS

- P1 PLUMBING SITE PLAN
- P2 CLASSROOM PLUMBING FLOOR PLAN
- P3 KINDERGARTEN PLUMBING FLOOR PLAN
- P4 PLUMBING SCHEDULES & DETAILS
- P5 PLUMBING SCHEDULES & DETAILS

ELECTRICAL

- E1 SITE ELECTRICAL
- E2 MISCELLANEOUS DETAILS
- E3
- E4 ONE LINE DIAGRAMS, DETAILS
- E5 CLASSROOM RUG FLOOR PLAN
- E6 DETAILS

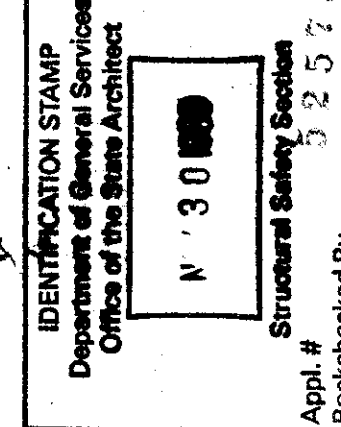

KAESTNER & ASSOCIATES
ARCHITECTS
ENGINEERS
1800 SANBIE AVE. SUITE 3
MUSTO, CALIFORNIA 95554
TEL. (408) 384-2412

52175 JUN 29 1989
Site only

SANTOS AVENUE ELEMENTARY SCHOOL
RIPON UNIFIED SCHOOL DISTRICT
SANTOS AVE. & MURPHY ROAD
RIPON, CA.

PROJECT TITLE

PROJ. NO.
DATE

DRAWING TITLE
PHASE 1
SITE PLAN

SCALE - 1" = 40'-0"

SHEET NO.

1