



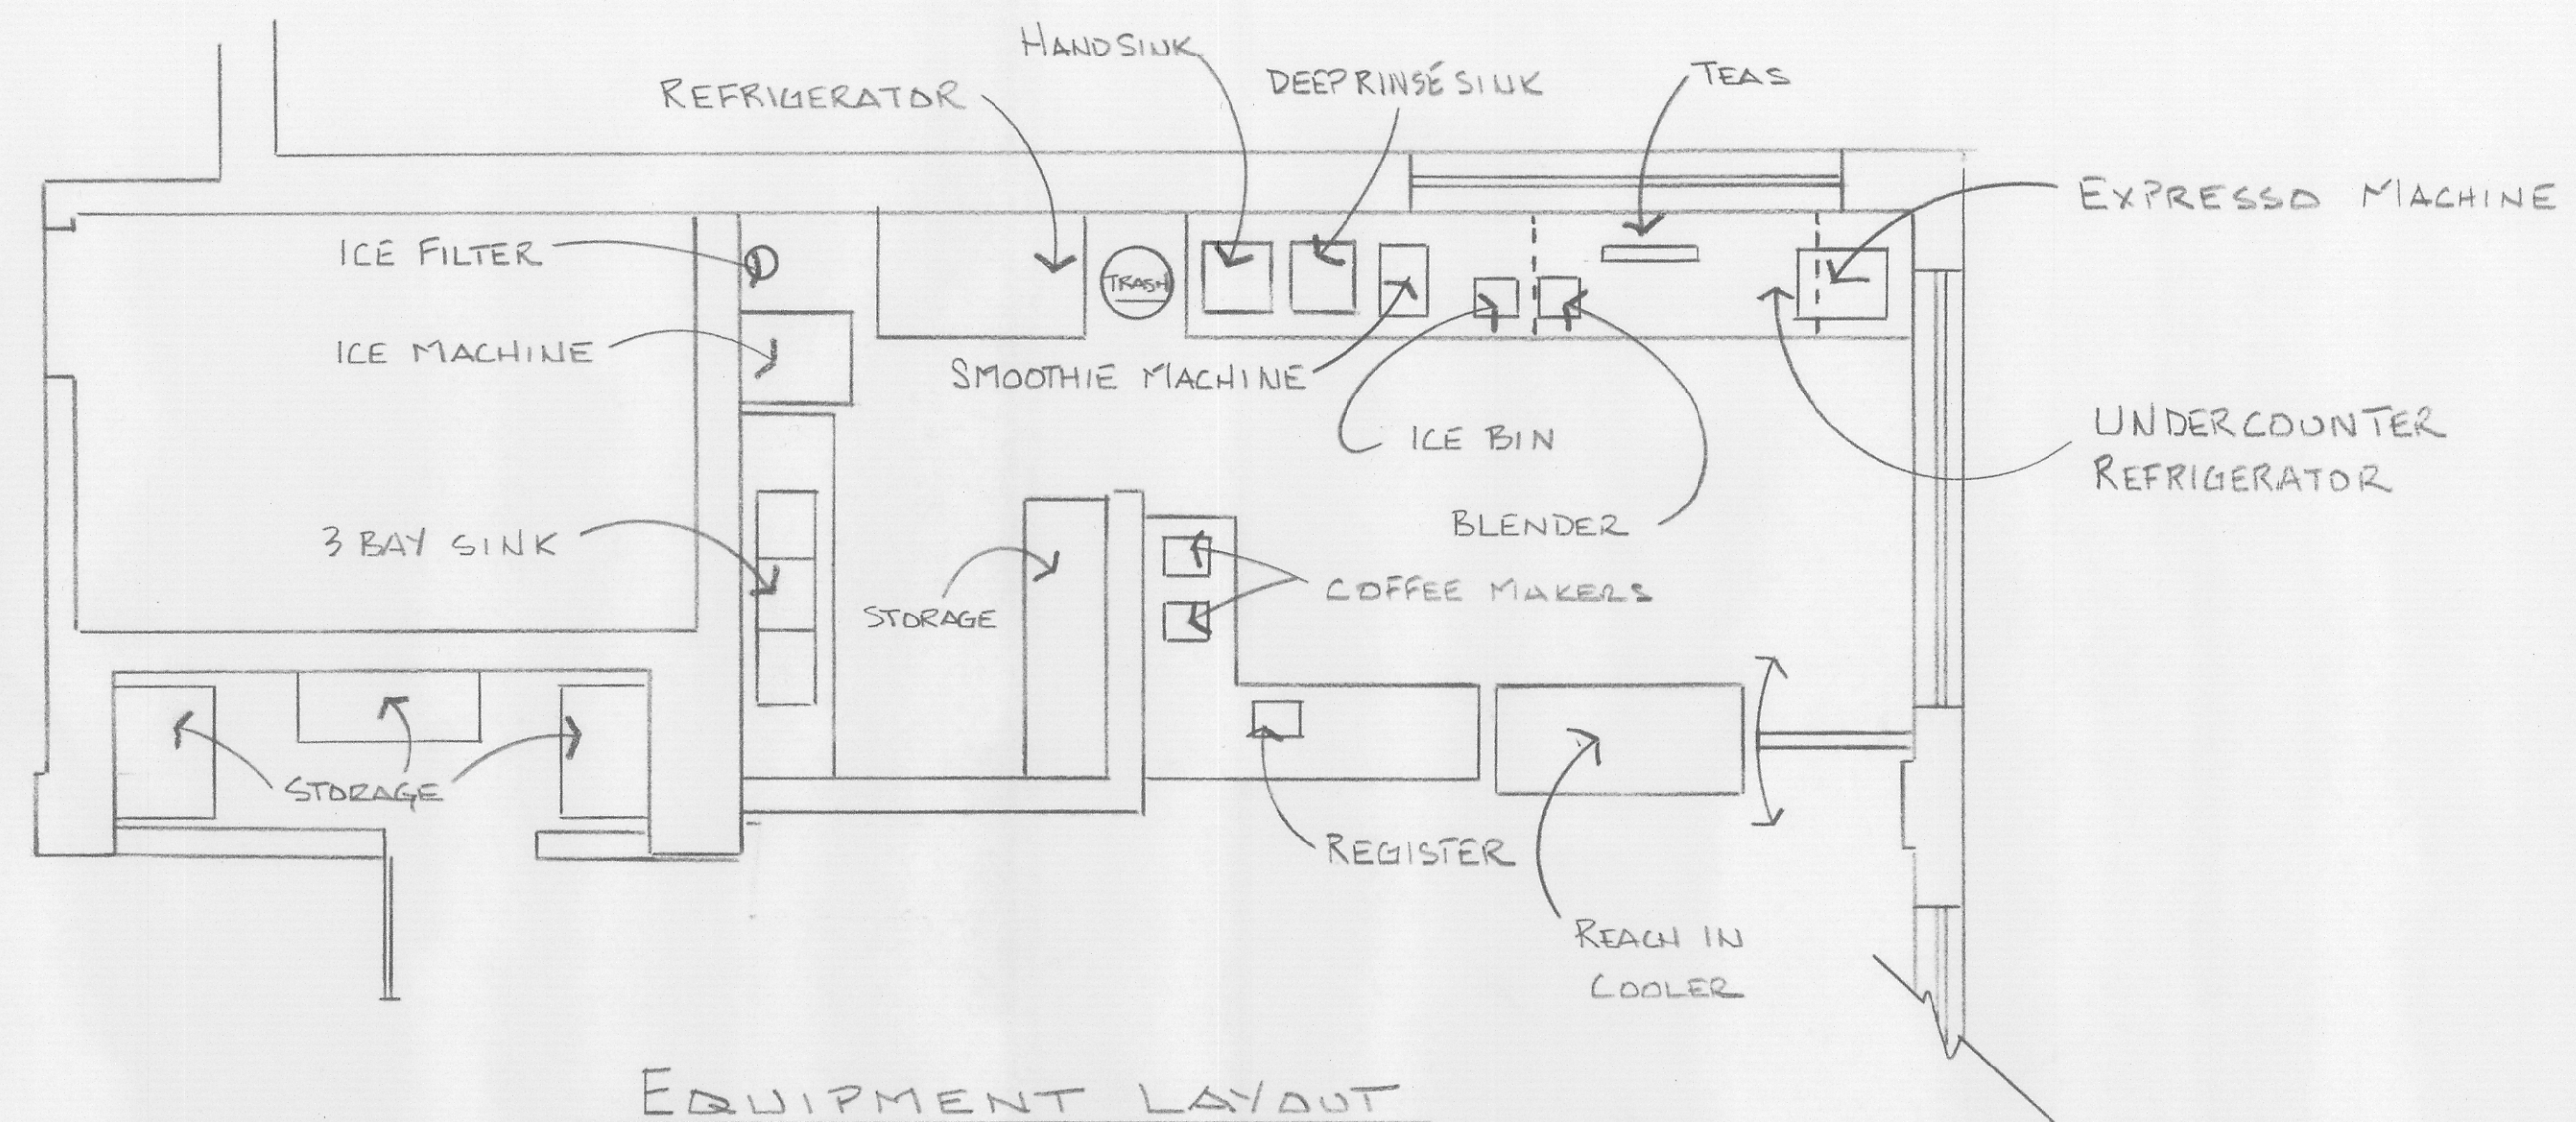

EQUIPMENT LAYOUT

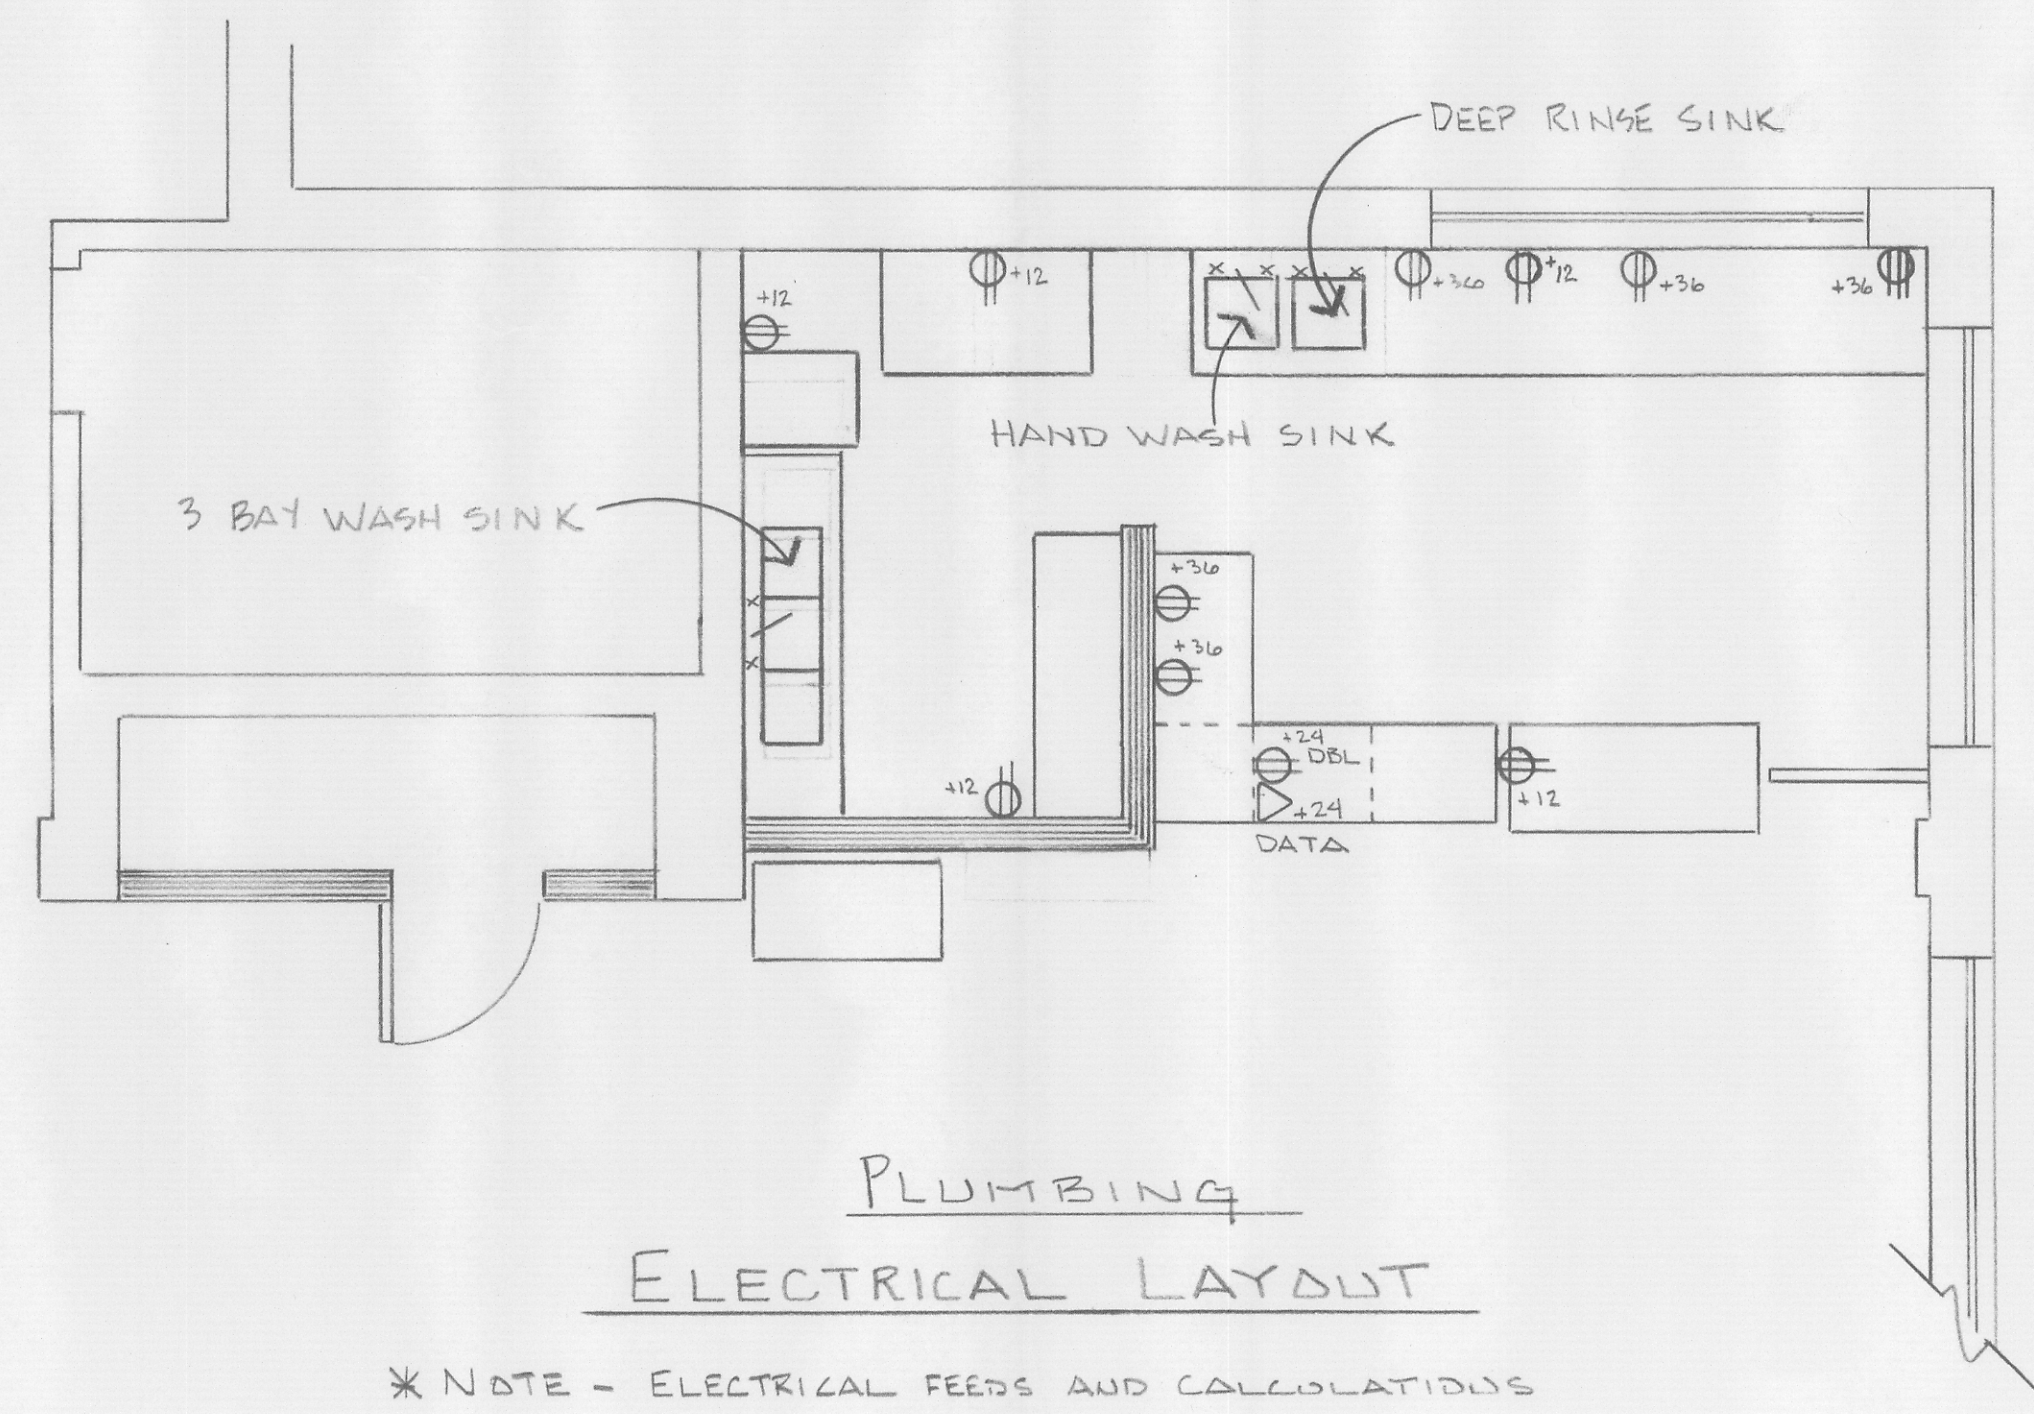

PLUMBING
ELECTRICAL LAYOUT

* NOTE - ELECTRICAL FEEDS AND CALCULATIONS
DONE BY OTHERS. NOT IN THIS PLAN SET.
- WATER AND DRAIN PATH WAY
DONE BY OTHERS.

NEW WALL

* ALL 110V OUTLETS 20 AMP.
* ALL 220V OUTLETS 30 AMP

GOLEMAN CAFE		
SCALE: 1/4" = 1'-0"	APPROVED BY:	DRAWN BY BOBROW
DATE:		REVISED
THESE DRAWINGS ARE FOR REFERENCE ONLY, NOT INTENDED FOR CONSTRUCTION PURPOSES.		
DRAWING NUMBER		A-2